 




SITE PLAN
SCALE: 1"=10'


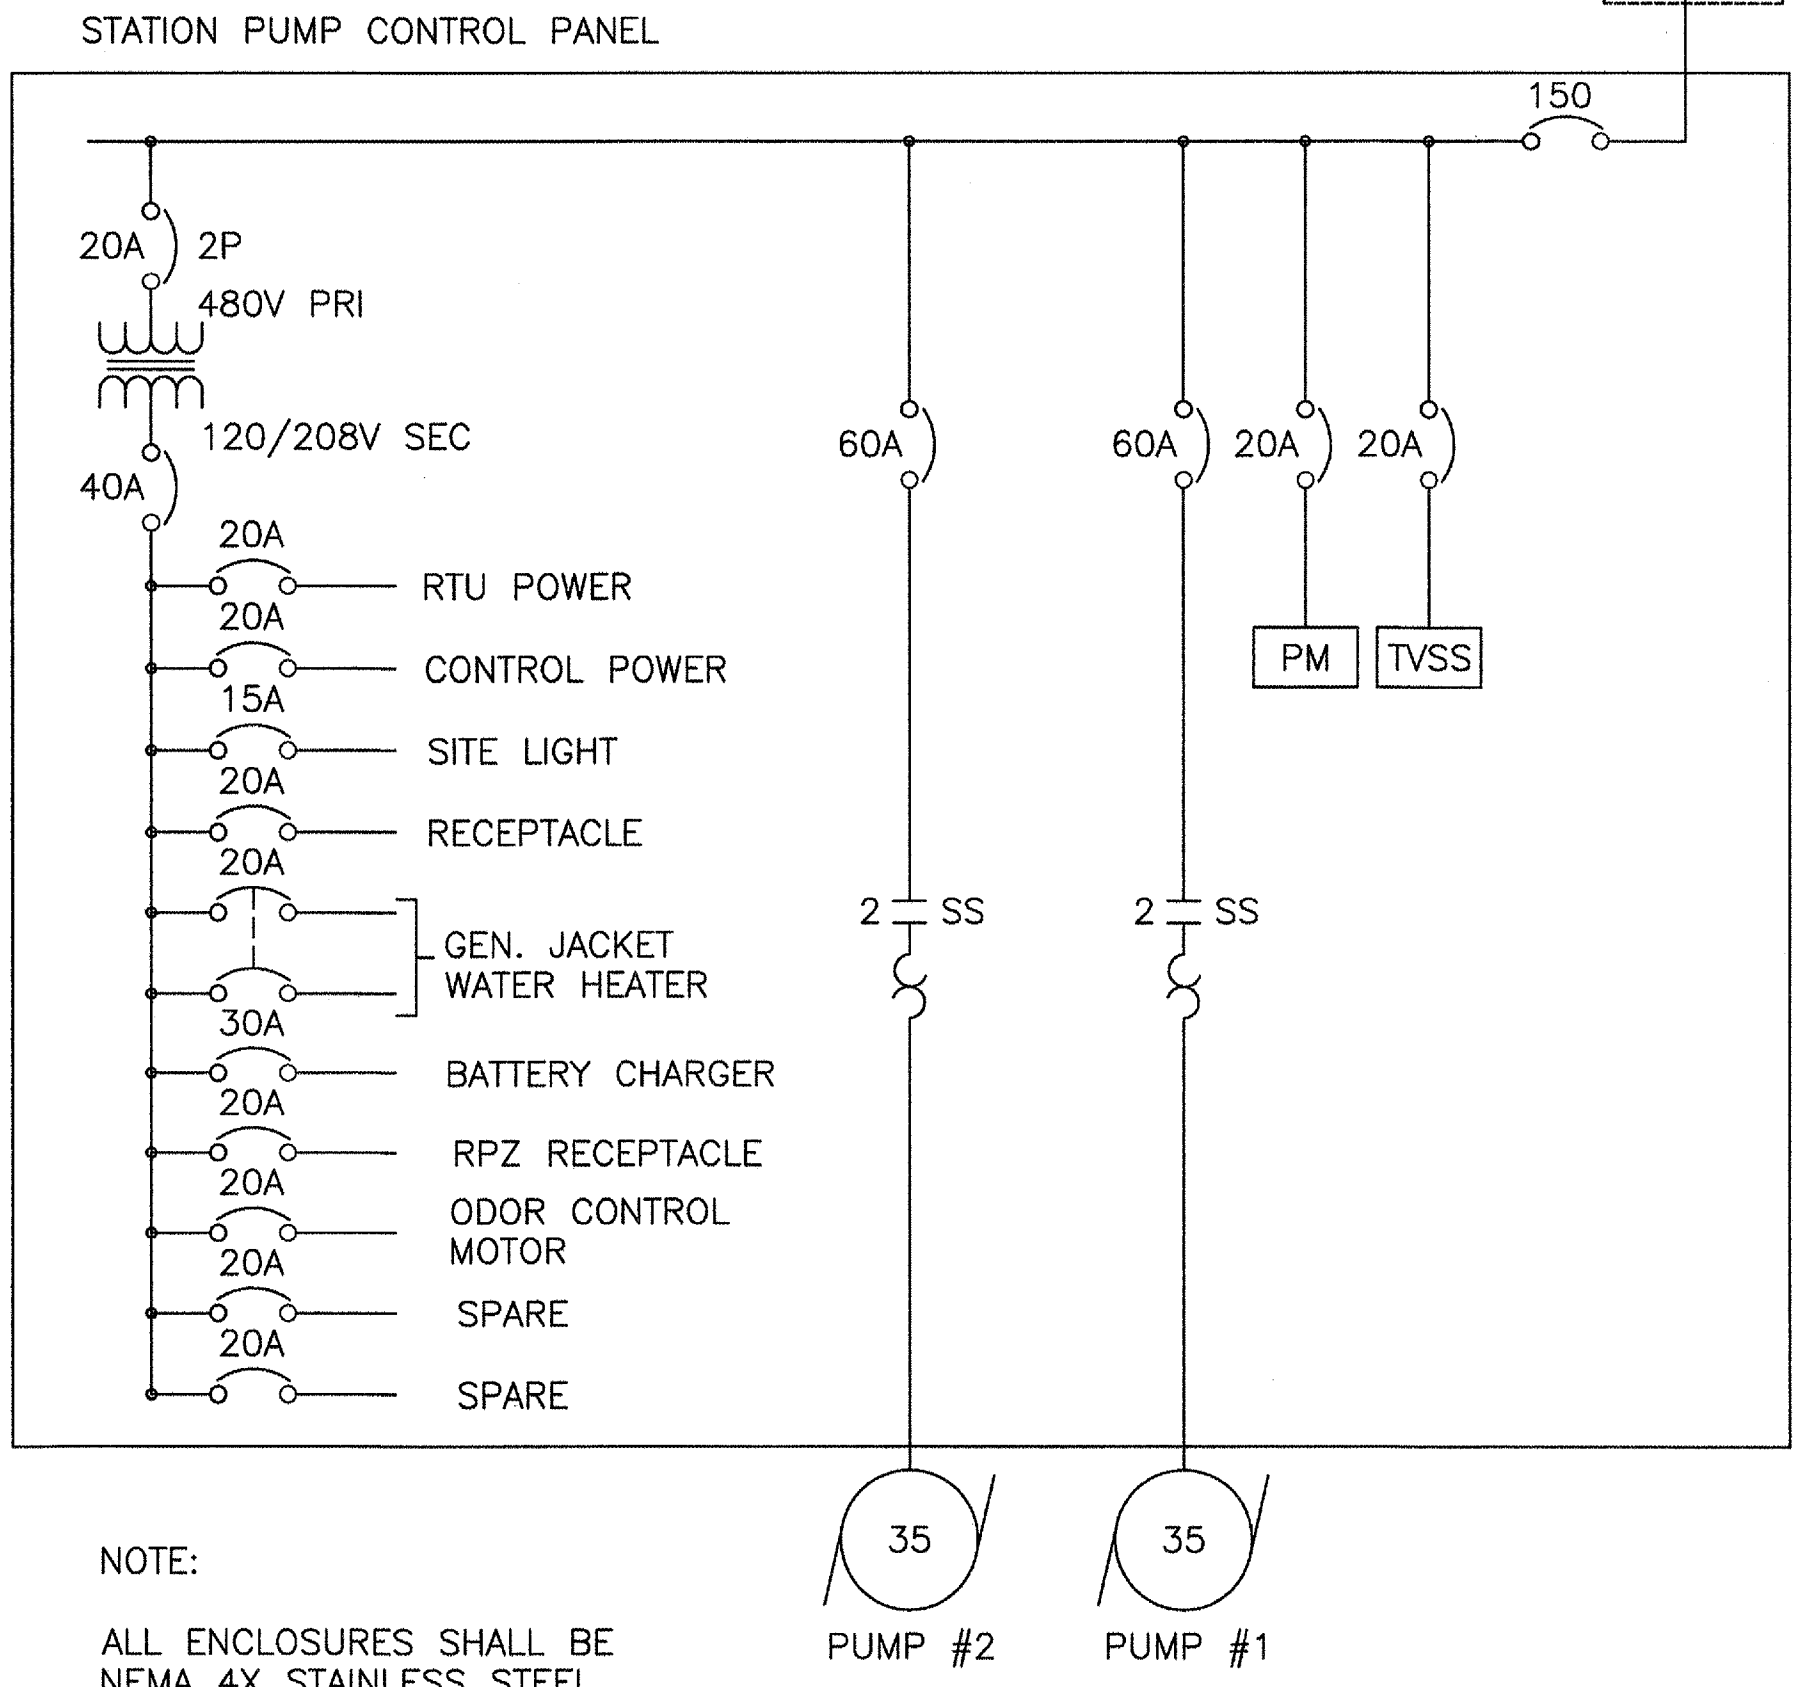


NOTES:

1. LIGHT FIXTURE TYPE 'OA' SHALL BE 150W HIGH PRESSURE SODIUM FULL CUT OFF TYPE III DISTRIBUTION SHOW BOX FIXTURE MOUNTED ON AN 18' SQUARE STEEL POLE. FIXTURE SHALL BE PROVIDED WITH A HOUSE SIDE SHIELD, FLAT POLYCARBONATE LENS, PHOTOCELL AND BE FOR OPERATION AT 120 V. FIXTURE AND POLE SHALL BE BRONZE IN COLOR.
2. IN COORDINATION WITH DEXTER FORTSON AND ASSOCIATES THE CONTRACTOR SHALL PROVIDE PTS AND CTS AT THE LINE SIDE OF THE MAIN CIRCUIT BREAKER AND AT THE EMERGENCY POWER INPUT TO THE AUTOMATIC TRANSFER SWITCH TO PROVIDE STATION VOLTAGE, PHASE TO PHASE, PHASE TO GROUND AND CURRENT IN EACH PHASE FOR INPUT TO THE ARTU.

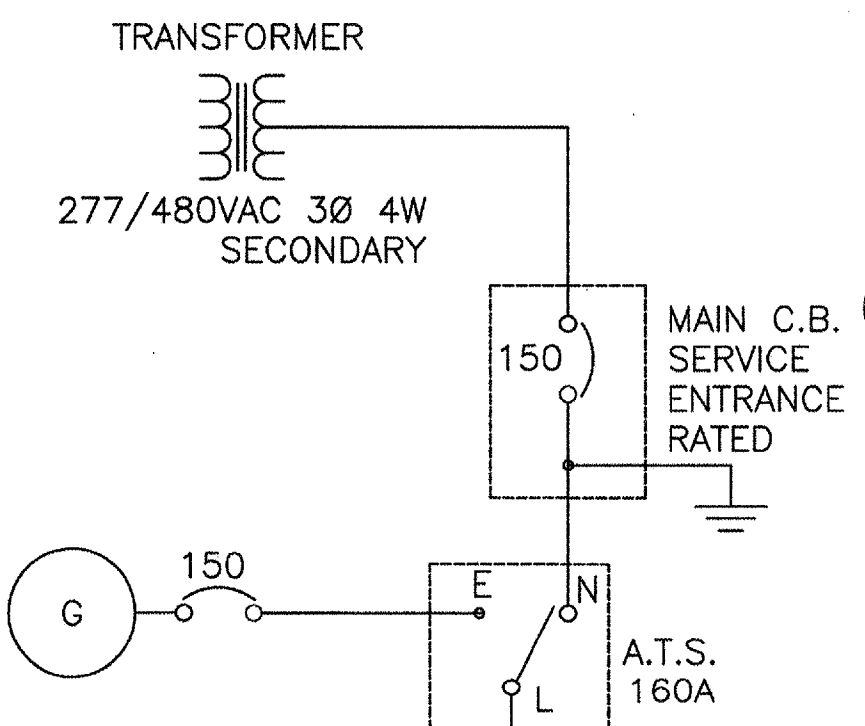

NOTE:
ALL ENCLOSURES SHALL BE NEMA 4X STAINLESS STEEL

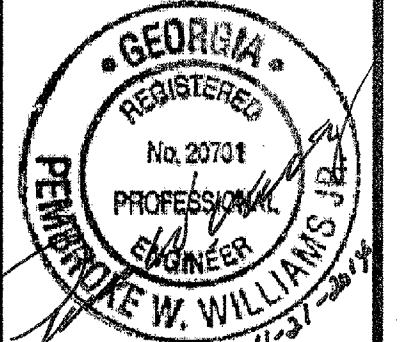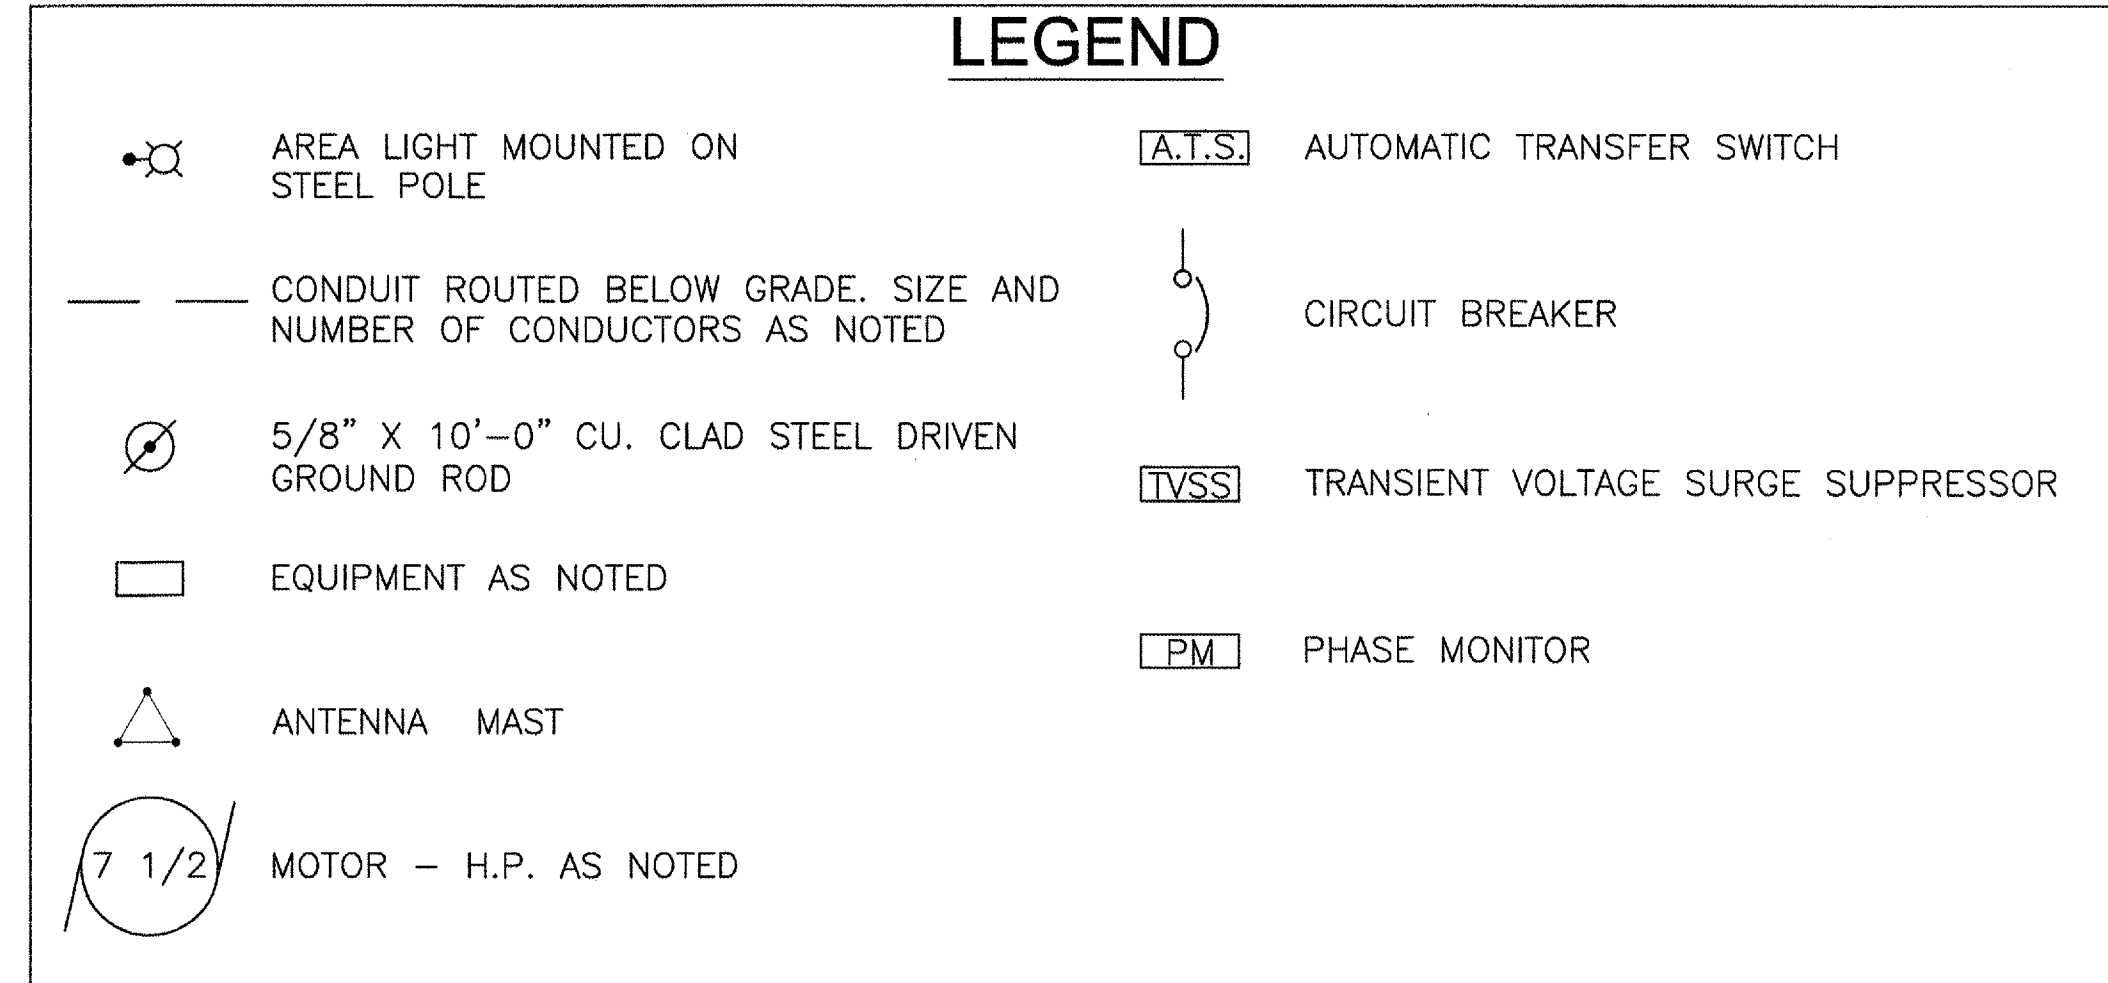

ATKINS

192 Anderson Street, Suite 150
Marietta, Ga 30060
P: 770-422-1902 F: 770-426-5316

PROJ. NO.	100034005	DESIGNED BY	PWW	DRAWN BY	JAL	CHECKED BY	PWW	APPROVED BY	PWW	DATE	AUGUST, 2013	SCALE	AS NOTED
REVISION		COMMENTS											
1		REVISED LIFT STATION PROPERTY								10-14-13			
2		REVISED LIFT STATION PROPERTY								11-18-13			
3		REVISED LIFT STATION PROPERTY								02-28-14			

CHEROKEE COUNTY WATER & SEWERAGE AUTHORITY
HOLLY SPRINGS
DOWNTOWN SANITARY SEWER SYSTEM

ONE LINE DIAGRAM AND LEGEND

WILLIAMS CONSULTING ENGINEERING, PC
901 Pinehurst Cove,
Woodstock, Georgia 30188
Phone: (770) 926-1239