

ATKINS



192 Anderson Street, Suite 150
Marietta, Ga 30060
P: 770-422-1902 F: 770-426-5316

PROJ. NO.	DATE	REVISION
100034005	12-23-13	
DESIGNED BY: W.F.L.		
DRAWN BY: M.R.T.		
CHECKED BY: W.F.L.		
APPROVED BY: W.F.L.		
DATE: AUGUST, 2013		
SCALE: AS SHOWN		

CHEROKEE COUNTY WATER & SEWERAGE AUTHORITY
HOLLY SPRINGS
DOWNTOWN SANITARY SEWER SYSTEM
EROSION CONTROL PLAN

SHEET NO.
EC-02

File Name: S:\CHEROKEECOWSA\PROJECTS\100034005 HOLLY SPRINGS SEWER\15_PLANS\EROSION CONTROL PLAN.DWG[Tab:EC-02]Plotter: December 31, 2013 4:29pm

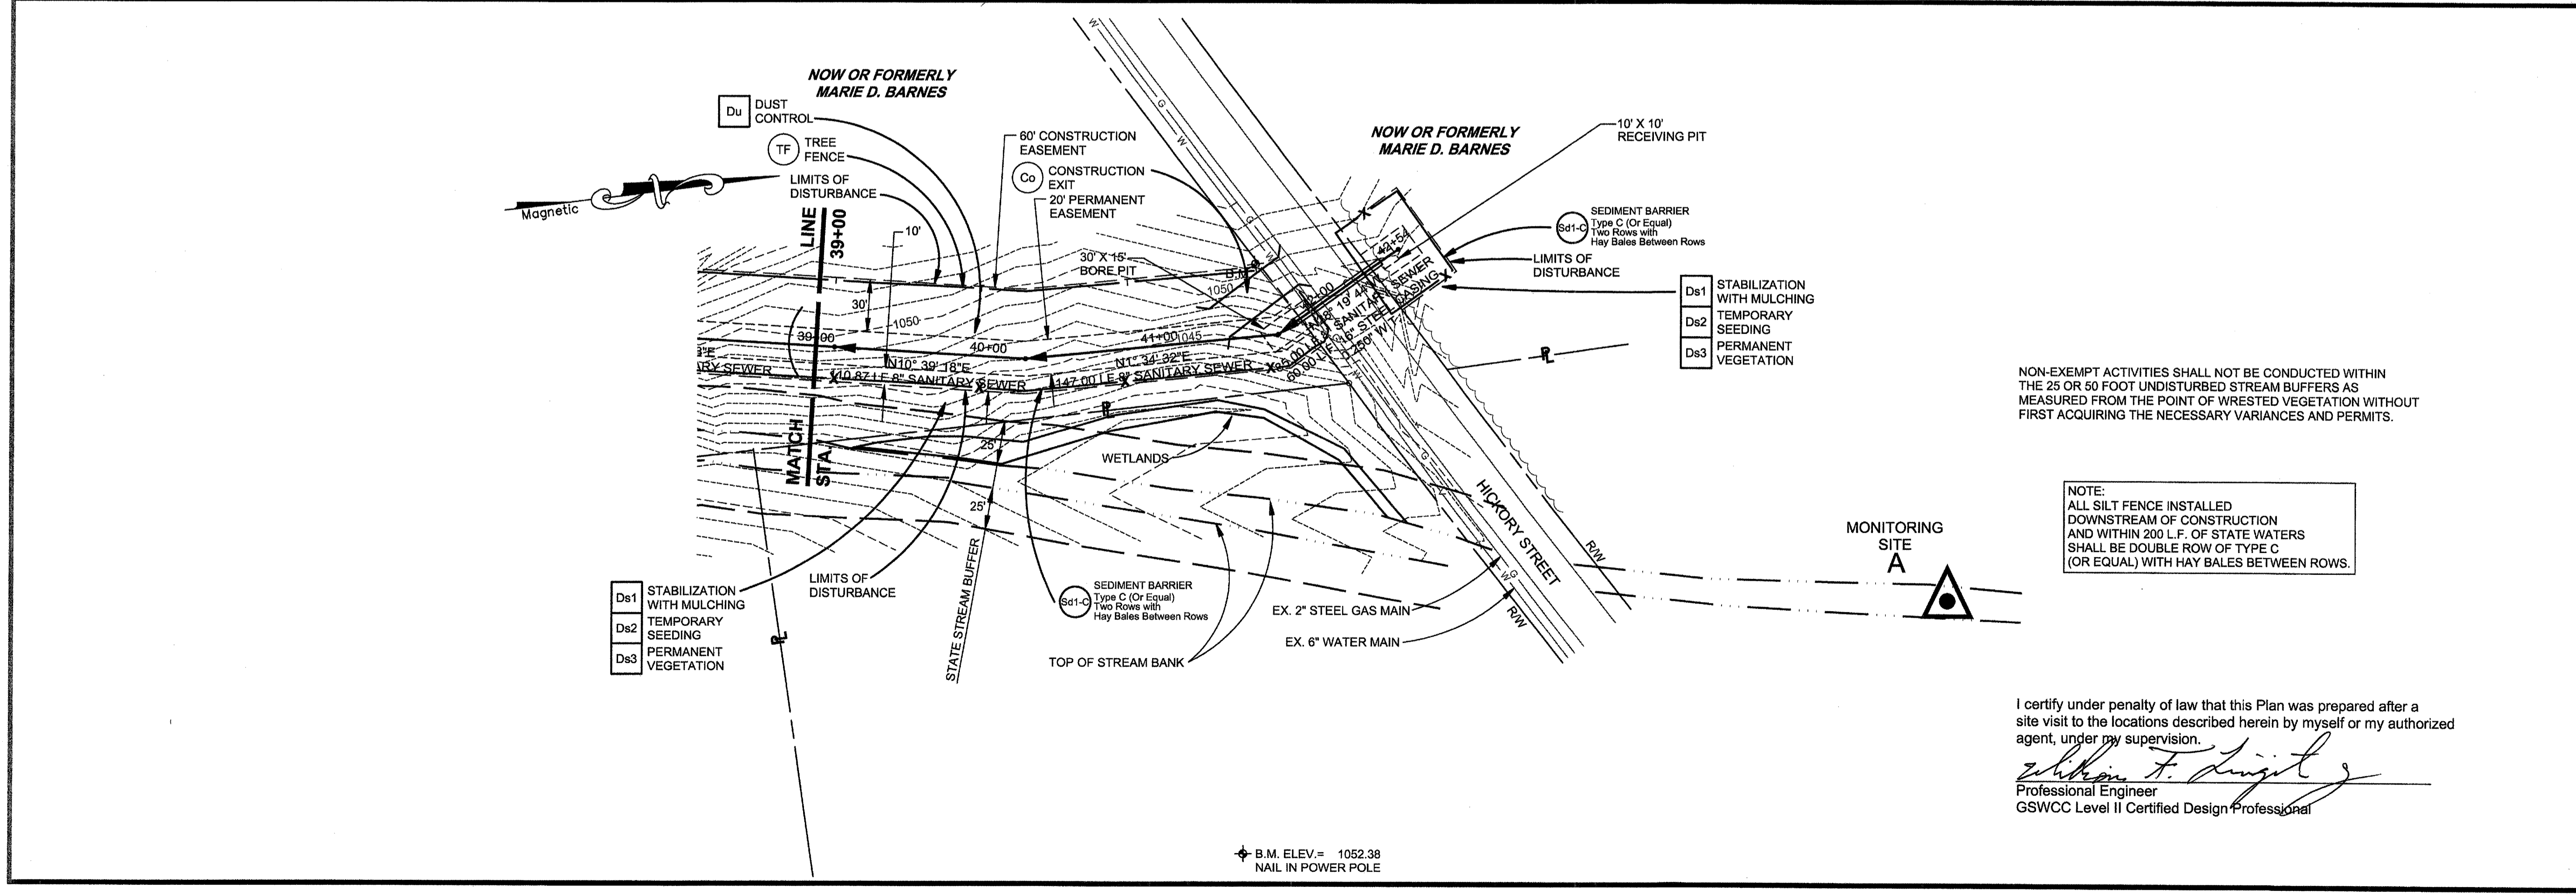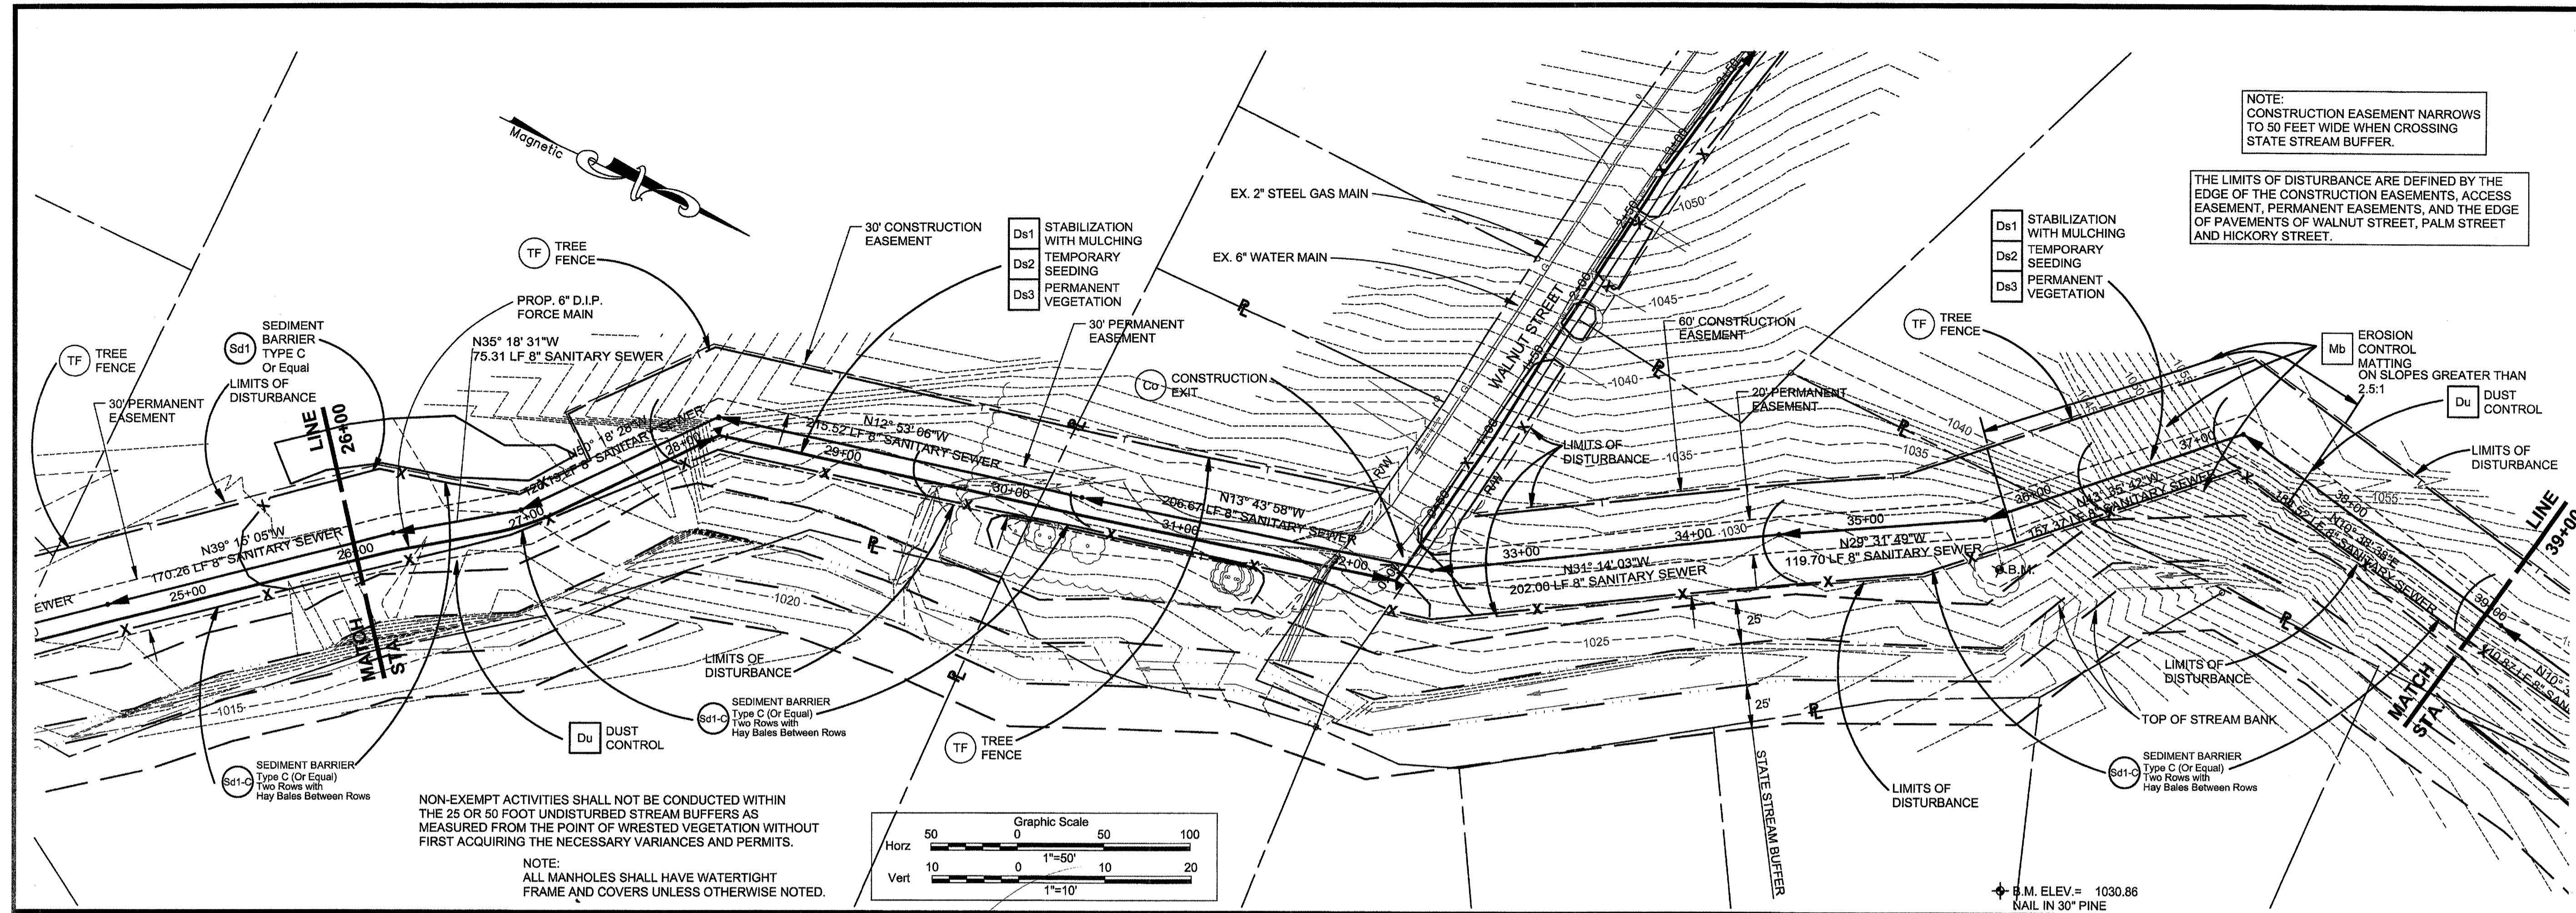

I certify under penalty of law that this Plan was prepared after a site visit to the locations described herein by myself or my authorized agent, under my supervision.
William F. Livingston
Professional Engineer
GSWCC Level II Certified Design Professional