


10/17/2014 3:51:24 PM P:\IER\11740200-11740-10003\CAD\SHEETFILES\TREATMENT PLANT\WTP-G-0006-OVERALL PROCESS FLOW DIAGRAM.DWG - EVANS, JON

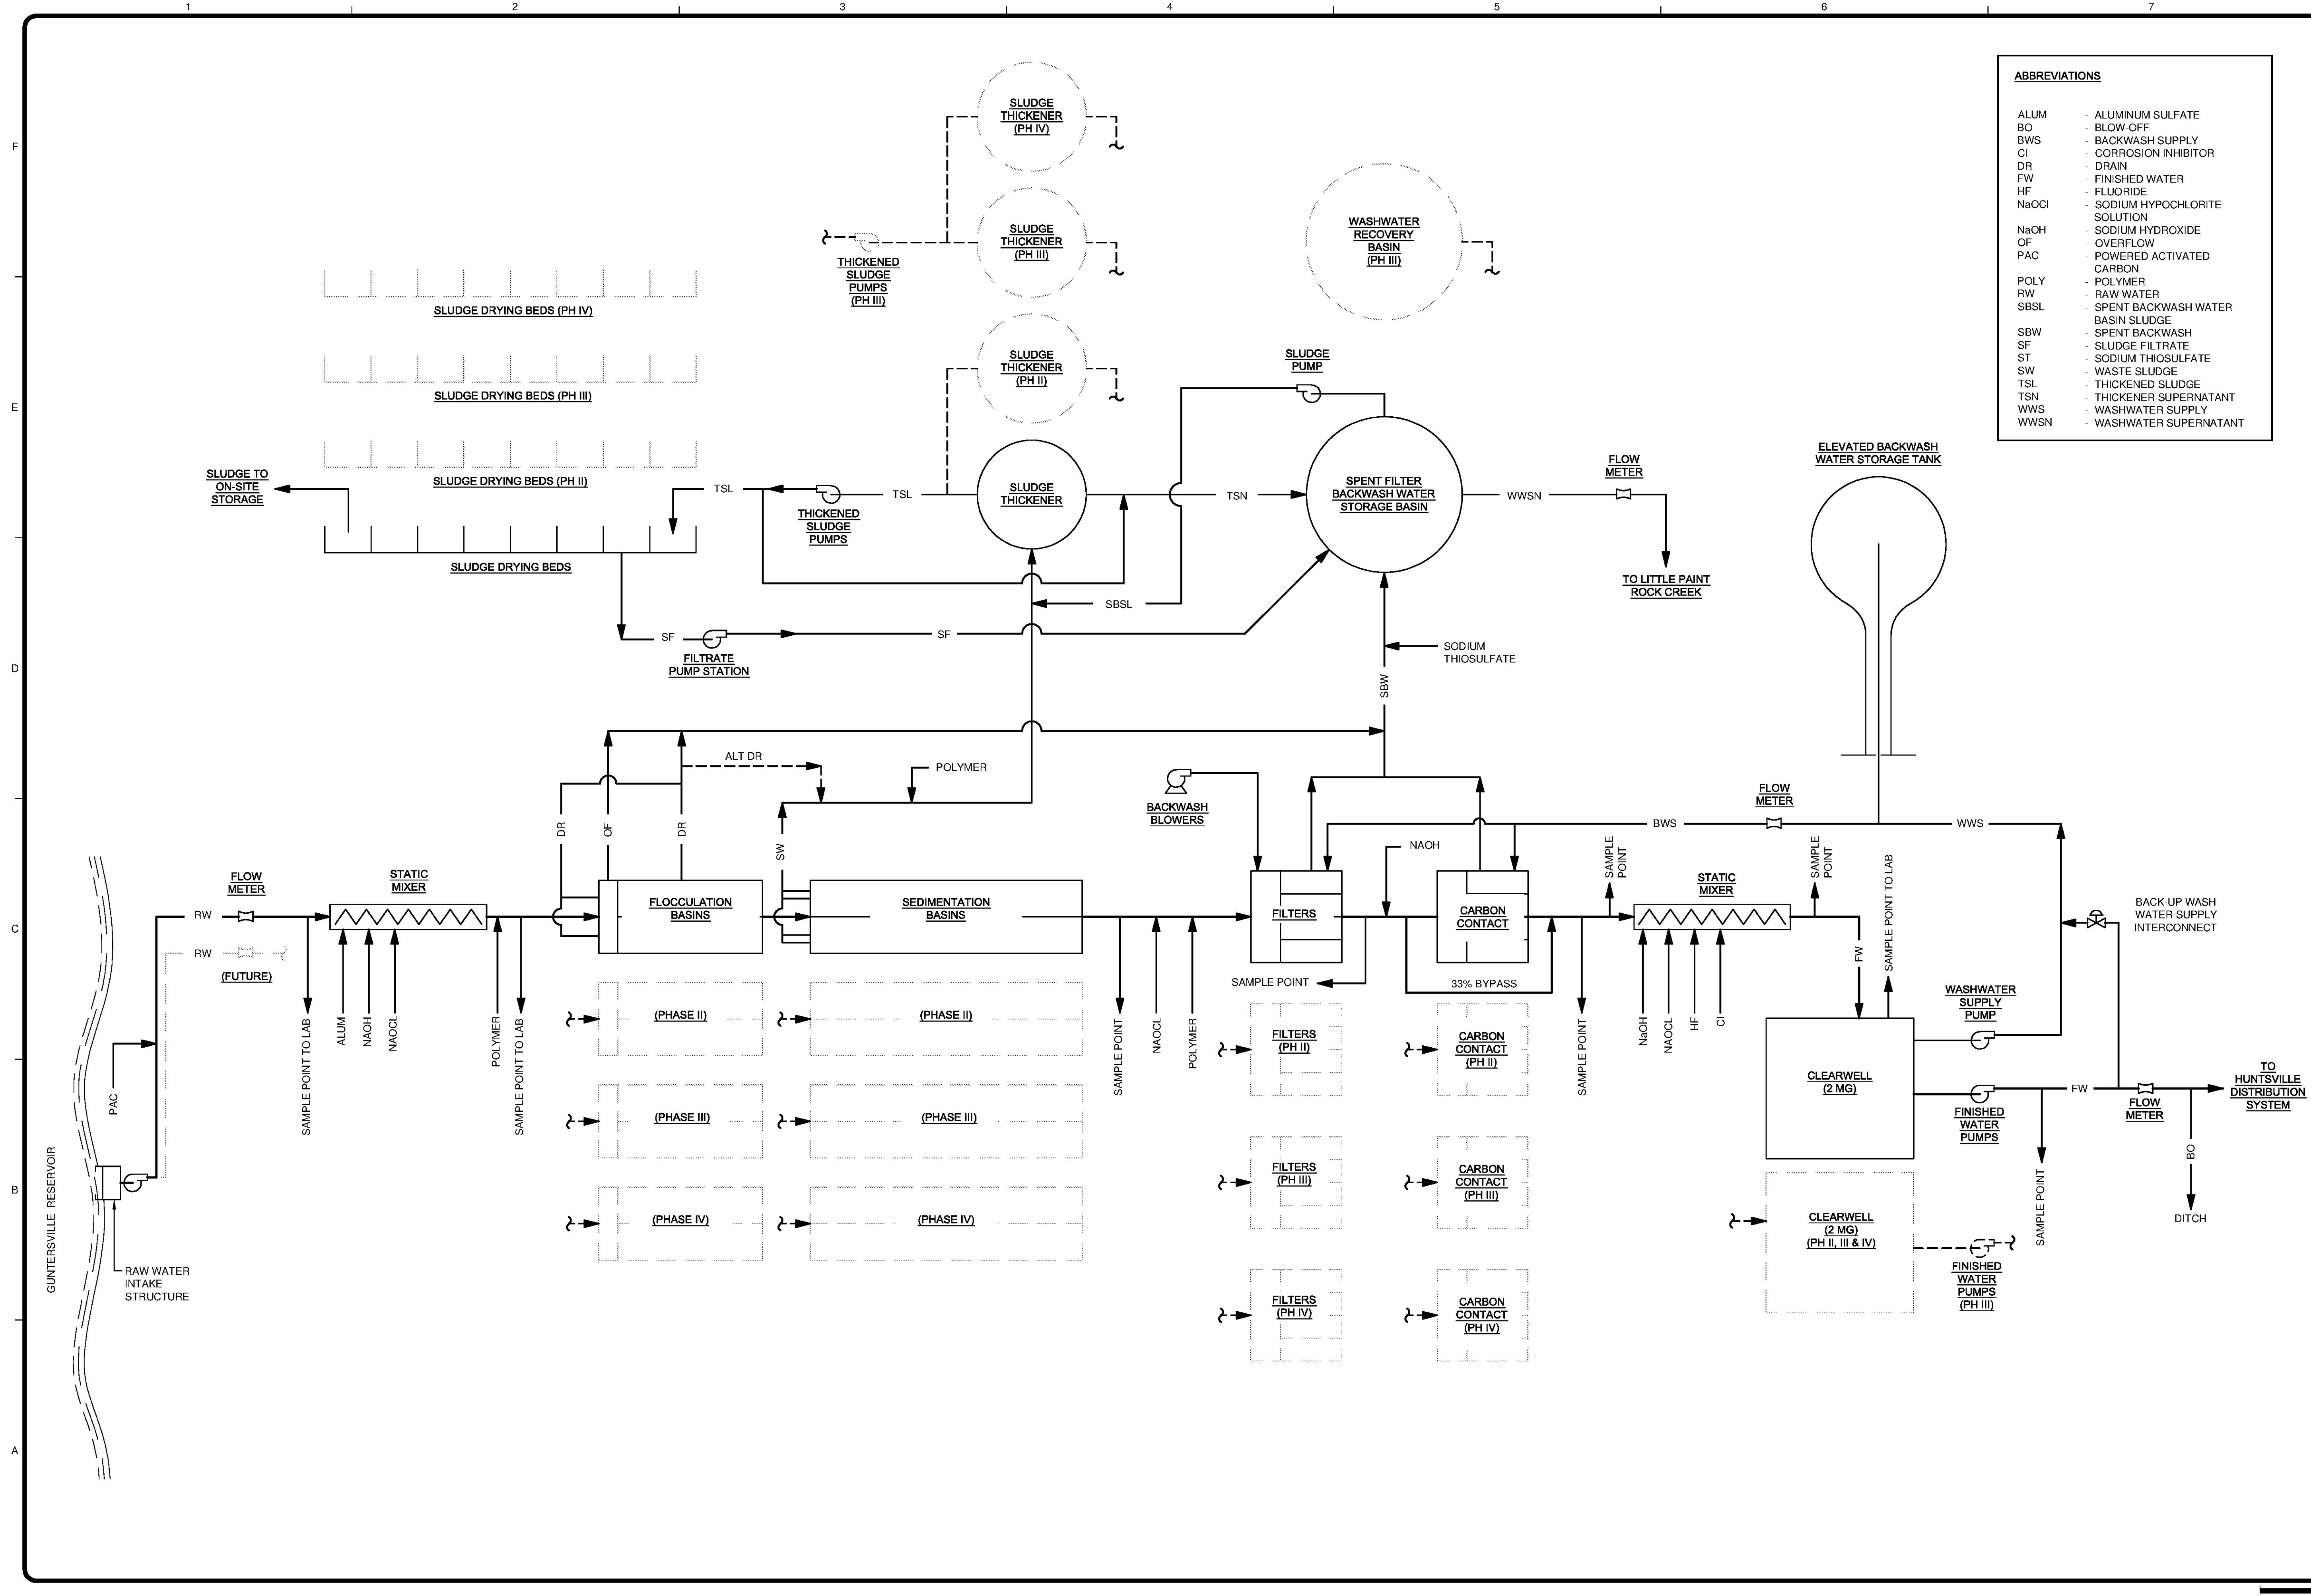

Copyright: Tetra Tech

TETRA TECH

www.tetra-tech.com

101 QUALITY CIRCLE, SUITE 140
HUNTSVILLE, ALABAMA 35806
PHONE: (256) 424-4077 FAX: (256) 424-4097

BY	DATE	DESCRIPTION

HUNTSVILLE UTILITIES
SOUTHEAST WATER TREATMENT PLANT

**OVERALL
PROCESS FLOW DIAGRAM**

Project No.: 200-11740-10003

Designed By: JPT

Drawn By: SGN

Checked By: JEC

G-0006

Bar Measures 1 inch