



10/1/2014 1:32:18 PM - I:\ERS\181\FS\1\PROJECTS\IER11740\200-11740-10003\CAD\SHEETFILES\TREATMENT PLANT\TP C-1101 TO C-1104 EXISTING CONDITIONS.DWG - REYES, HECTOR

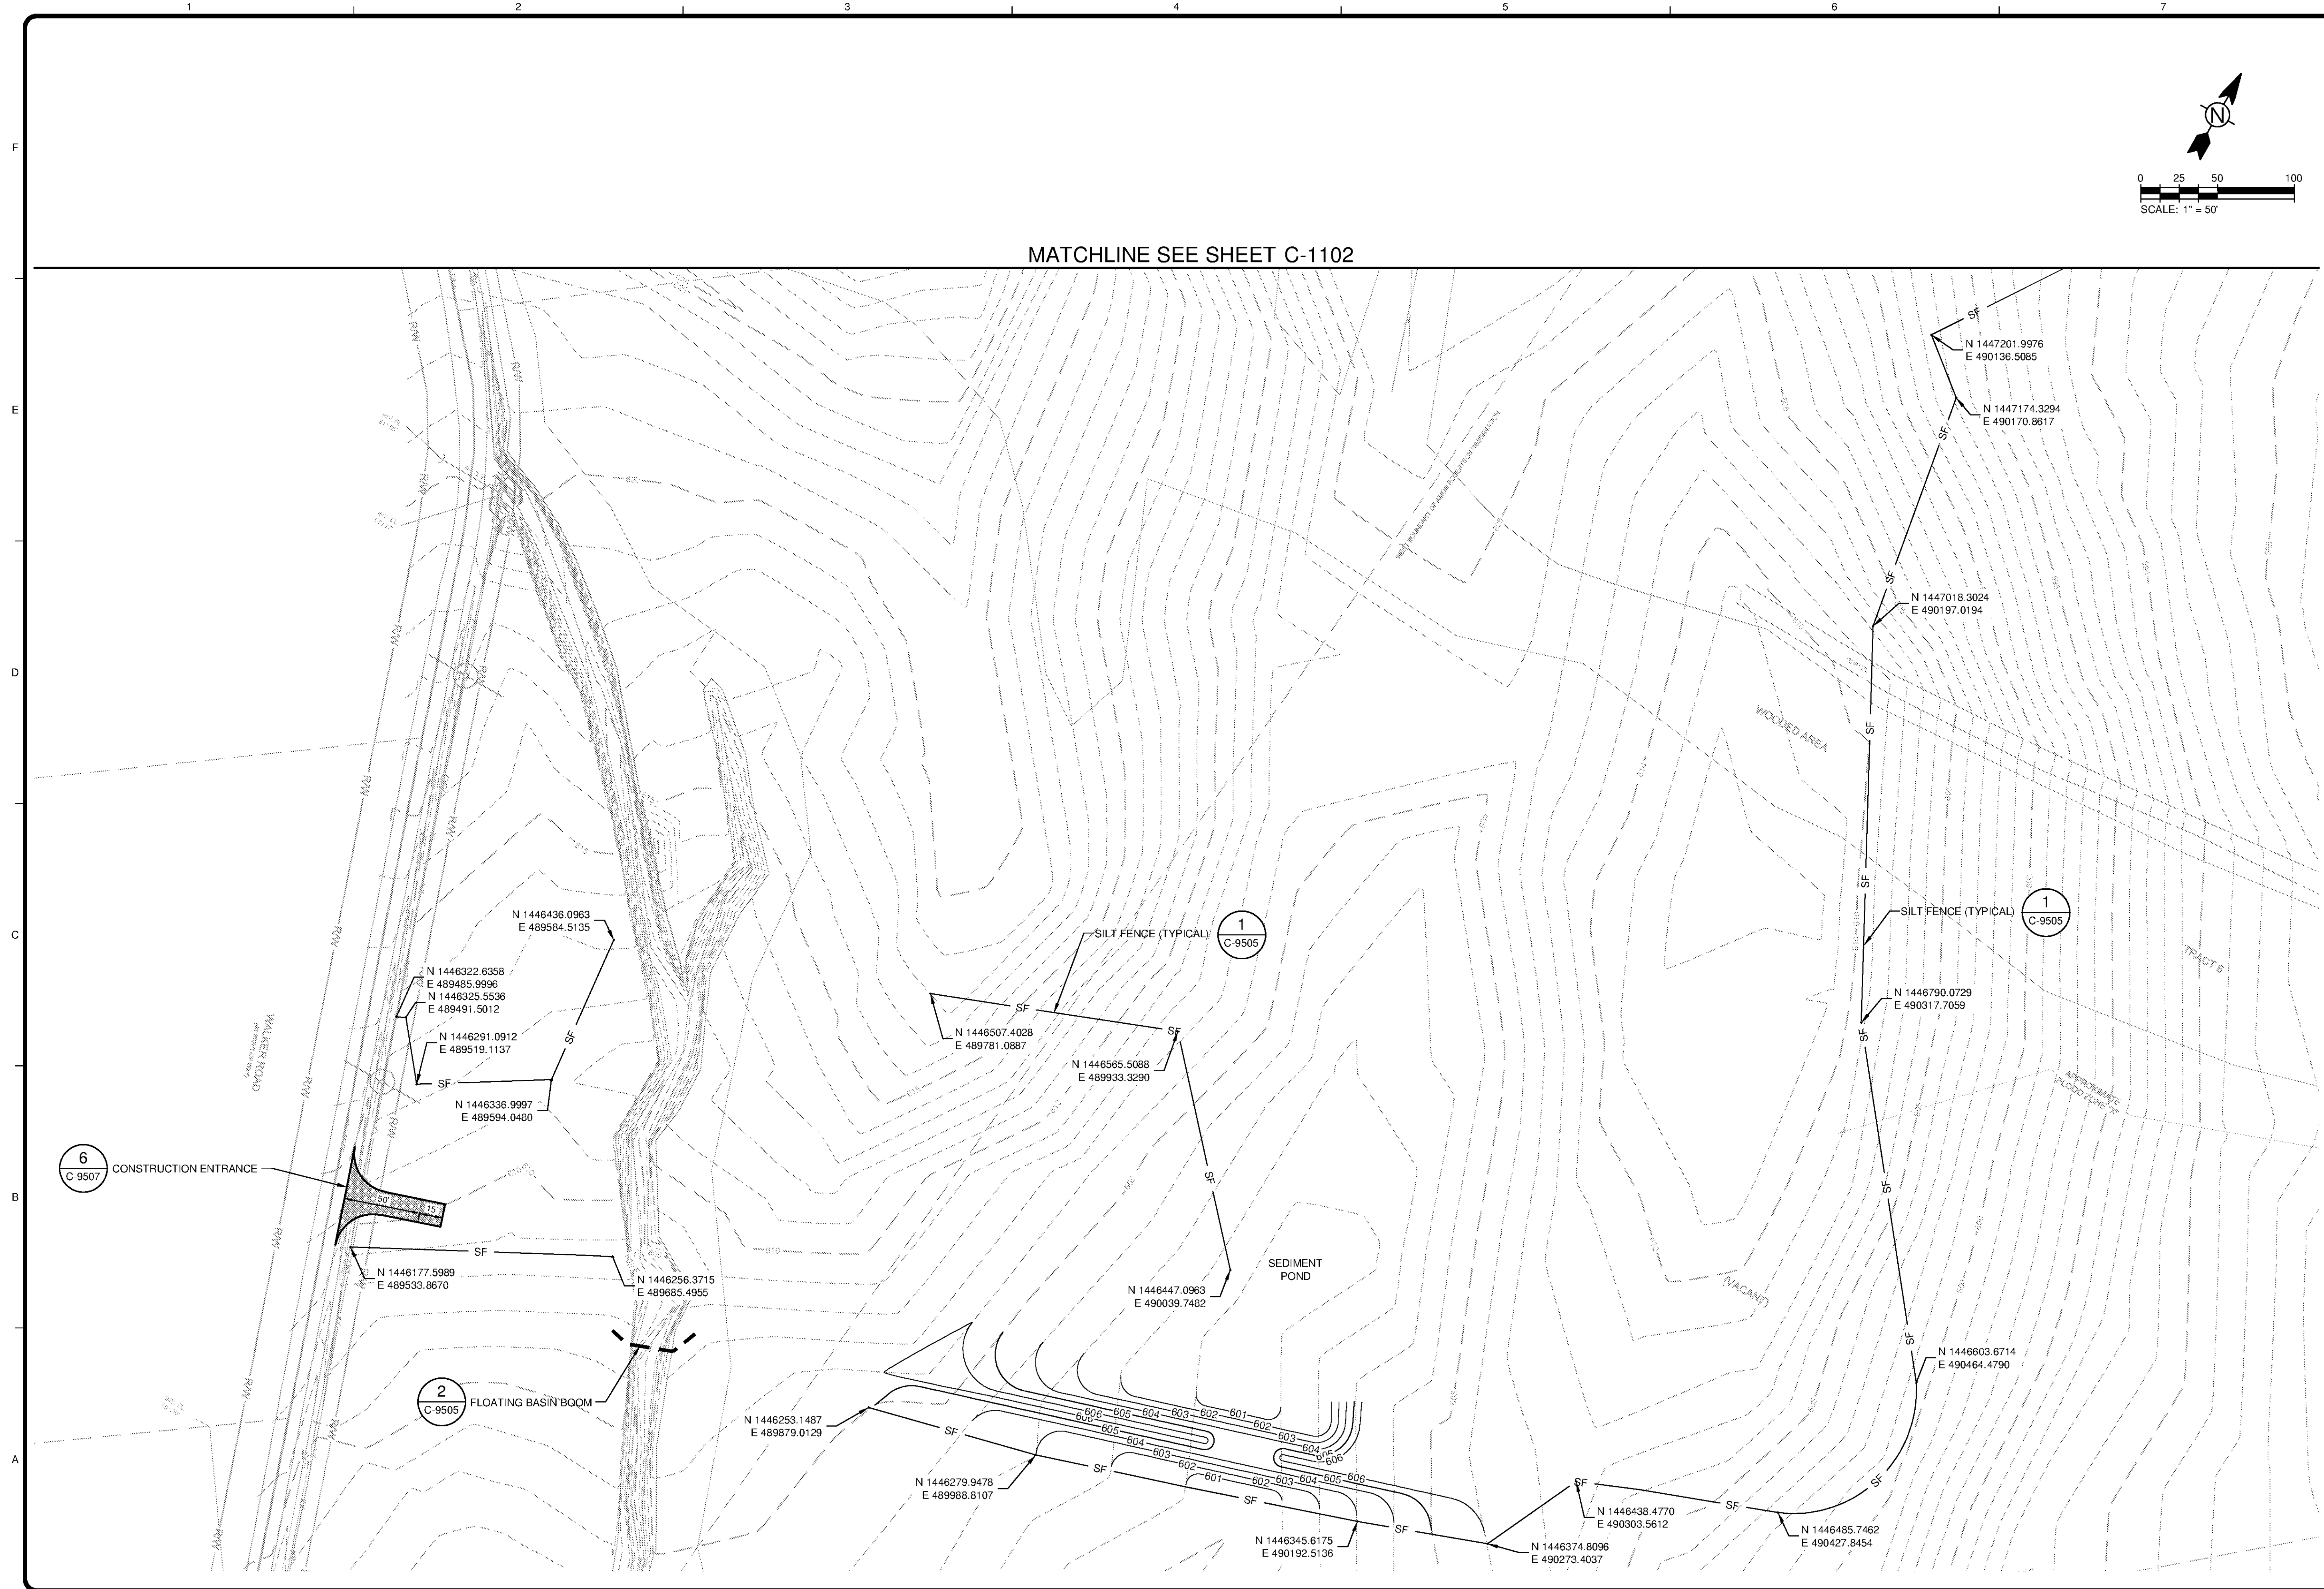

MATCHLINE SEE SHEET C-1102

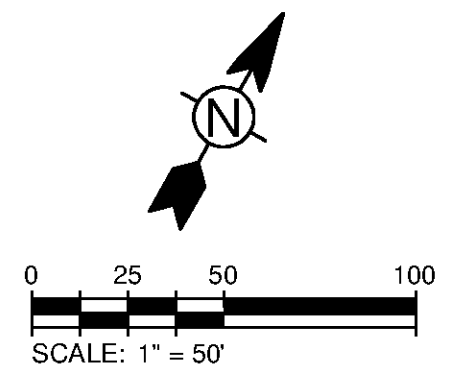

TETRA TECH
www.tetra.tech.com
101 QUALITY CIRCLE, SUITE 140
HUNTSVILLE, ALABAMA 35806
PHONE: (256) 424-4077 FAX: (256) 424-4097

BID SET
[Signature]
10/24/14

MARK	DATE	DESCRIPTION	BY

HUNTSVILLE UTILITIES
SOUTHEAST WATER TREATMENT PLANT
**EXISTING CONDITIONS,
DEMOLITION &
EROSION CONTROL**

Project No.: 200-11740-10003
Designed By: JRW
Drawn By: JWD
Checked By: JPT

C-1101

Bar Measures 1 inch

Copyright Tetra Tech