
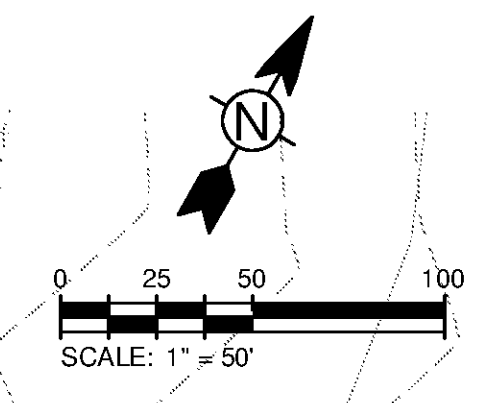


10/1/2014 1:30:38 PM - \\ERS161FS1\PROJECTS\IER11740\200-11740-10003\CAD\SHEETFILES\TREATMENT PLANT\TP C-1101 TO C-1104 EXISTING CONDITIONS.DWG - REYES, HECTOR

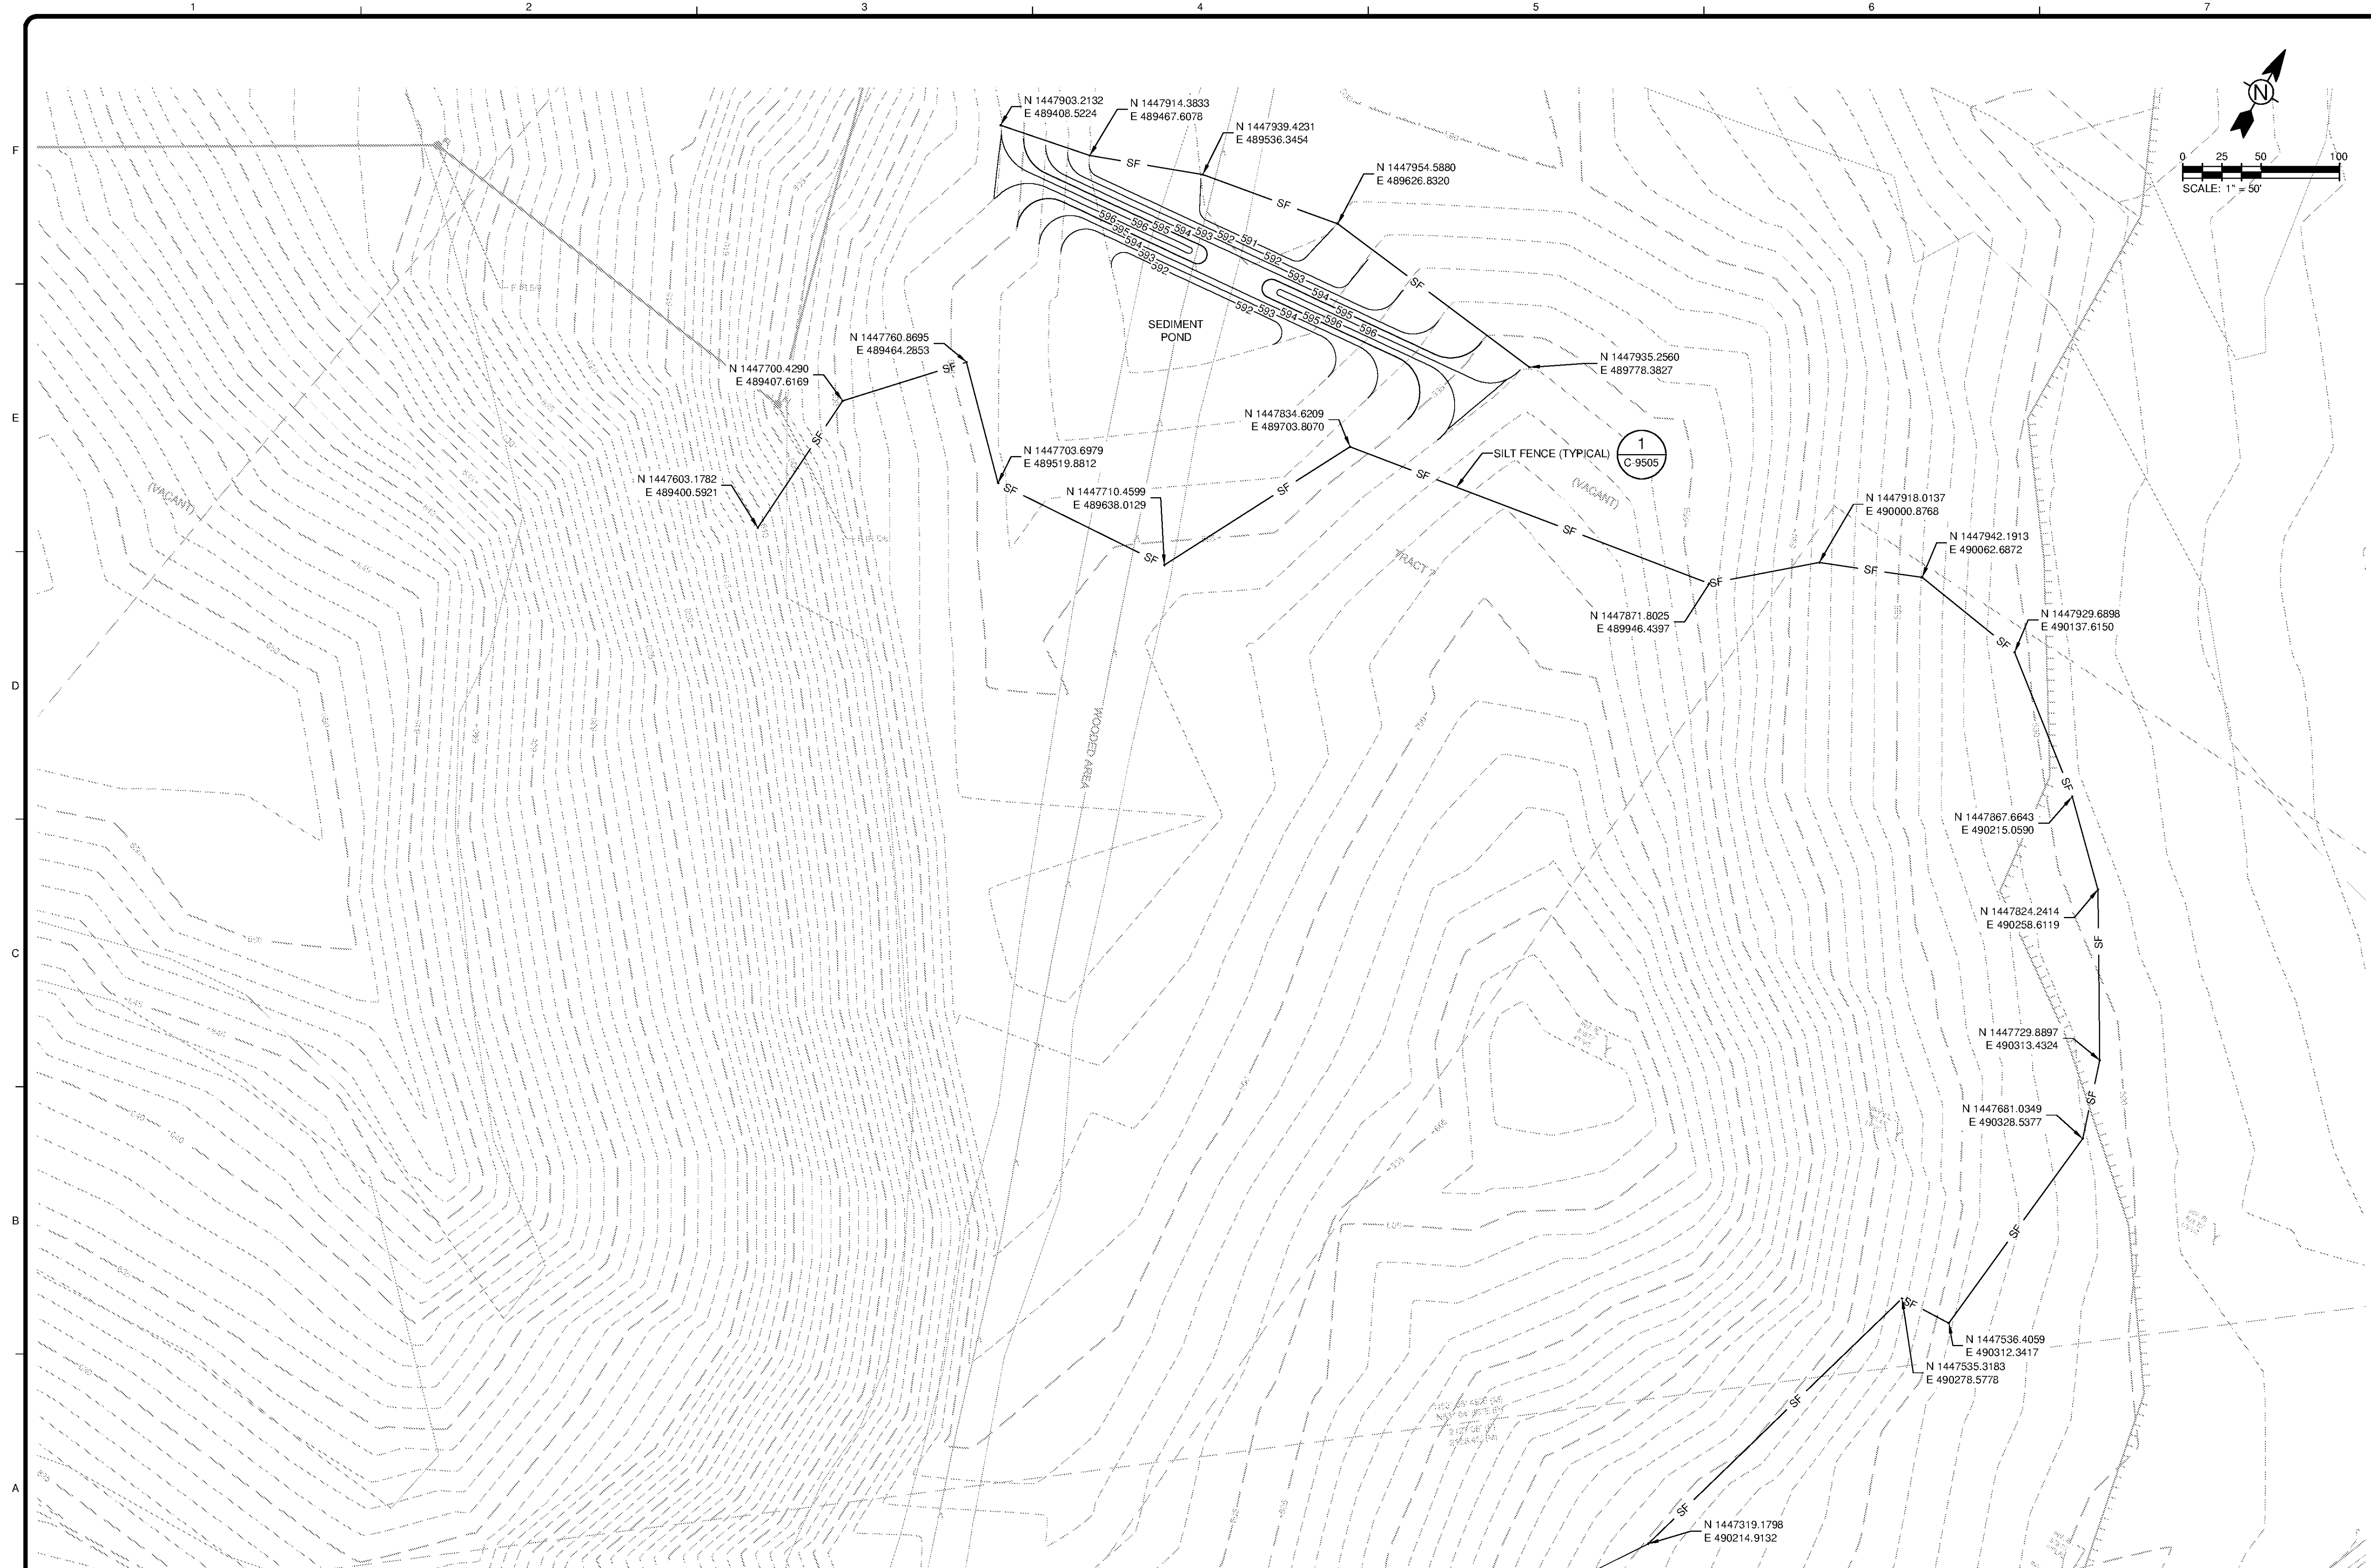

**TETRA TECH**  
www.tetrattech.com  
101 QUALITY CIRCLE, SUITE 140  
HUNTSVILLE, ALABAMA 35806  
PHONE: (256) 424-4077 FAX: (256) 424-4097

BID SET  
*[Signature]*  
10/24/14

MARK	DATE	DESCRIPTION	BY

HUNTSVILLE UTILITIES  
SOUTHEAST WATER TREATMENT PLANT  
EXISTING CONDITIONS,  
DEMOLITION &  
EROSION CONTROL

Project No.: 200-11740-10003  
Designed By: JRW  
Drawn By: WDV  
Checked By: JPT

**C-1102**

MATCHLINE SEE SHEET C-1101

Bar Measures 1 inch

Copyright Tetra Tech