

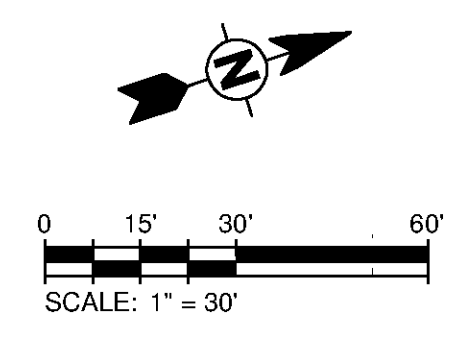


10/6/2014 2:16:24 PM - \\ERS\81\FS\PROJECTS\11740\200-11740-10003\CAD\SHEETFILES\TREATMENT PLANT\WP-C-1108 TO C-1109 ENTRANCE RD PLANS AND PROFILES.DWG - SANFORD, CHADWICK

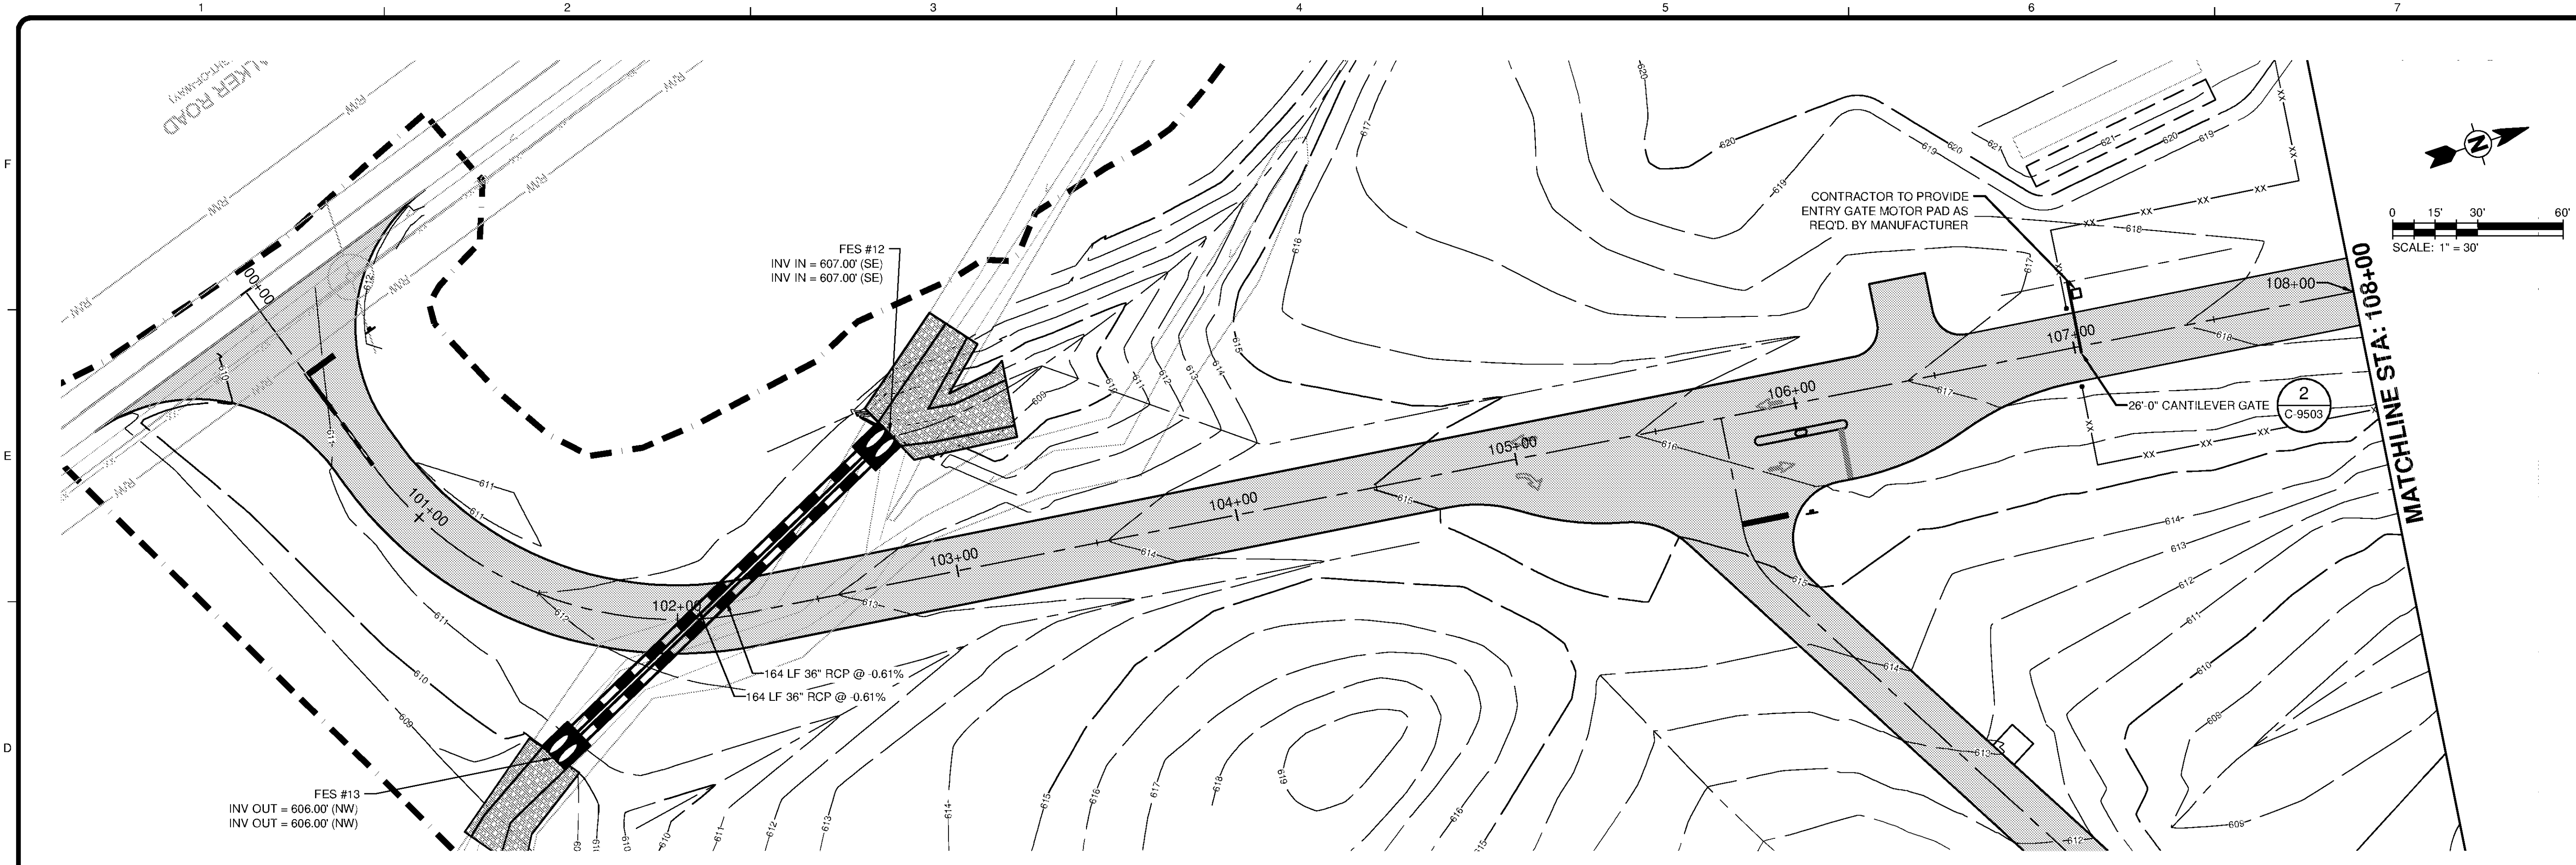

TETRA TECH
 www.tetra-tech.com
 101 QUALITY CIRCLE, SUITE 140
 HUNTSVILLE, ALABAMA 35806
 PHONE: (256) 424-4077 FAX: (256) 424-4097

BID SET
 [Signature]
 10/24/14

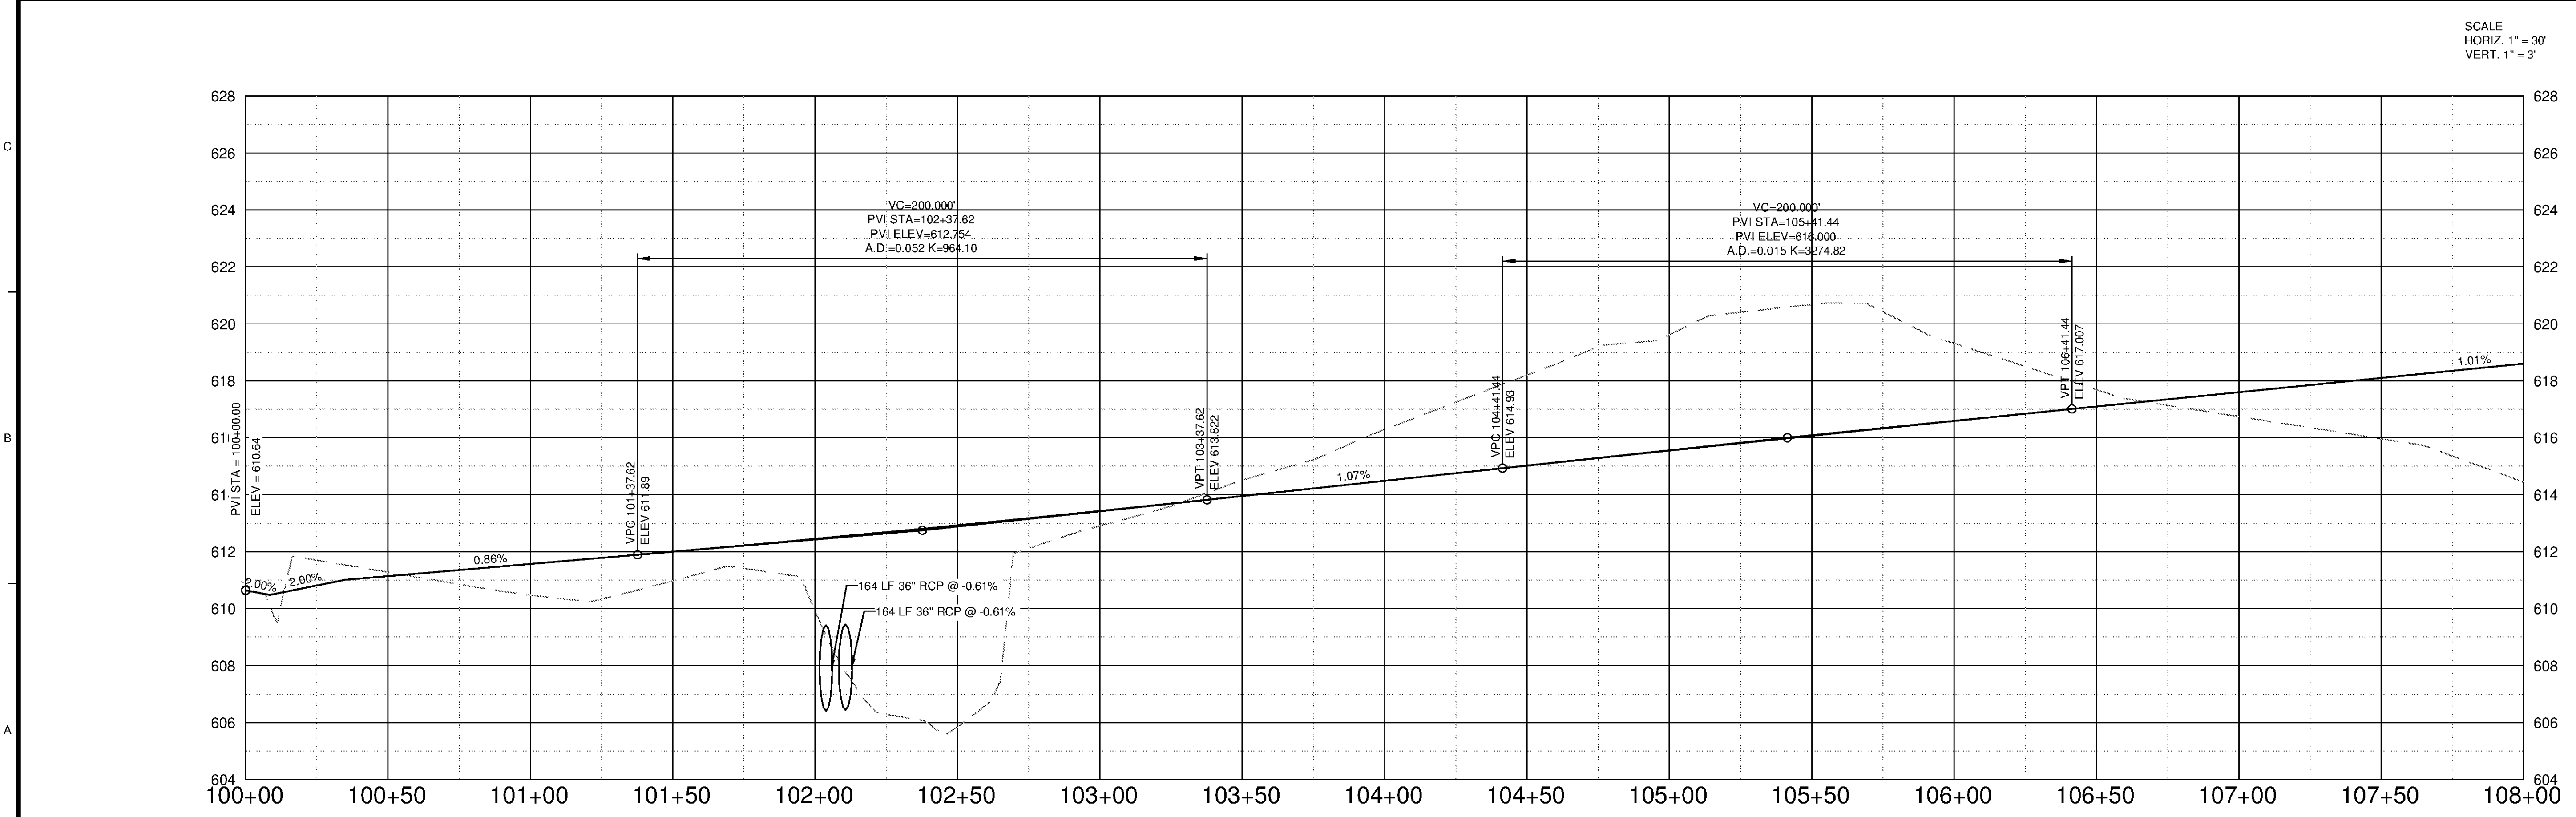

SCALE
 HORIZ. 1" = 30'
 VERT. 1" = 3'

BY	DATE	DESCRIPTION

HUNTSVILLE UTILITIES
 SOUTHEAST WATER TREATMENT PLANT
**WTP ENTRANCE RD
 PLAN AND PROFILE**

Project No.: 200-11740-10003
 Designed By: JRW
 Drawn By: JWD
 Checked By: JPT

C-1108