




10/1/2014 2:28:26 PM - \\ERS\61\F5\PROJECTS\1740\200-11740-10003\CAD\SHEETFILES\TREATMENT PLANT\TP C-1110 NORTH RD PLAN AND PROFILE.DWG - REYES, HECTOR

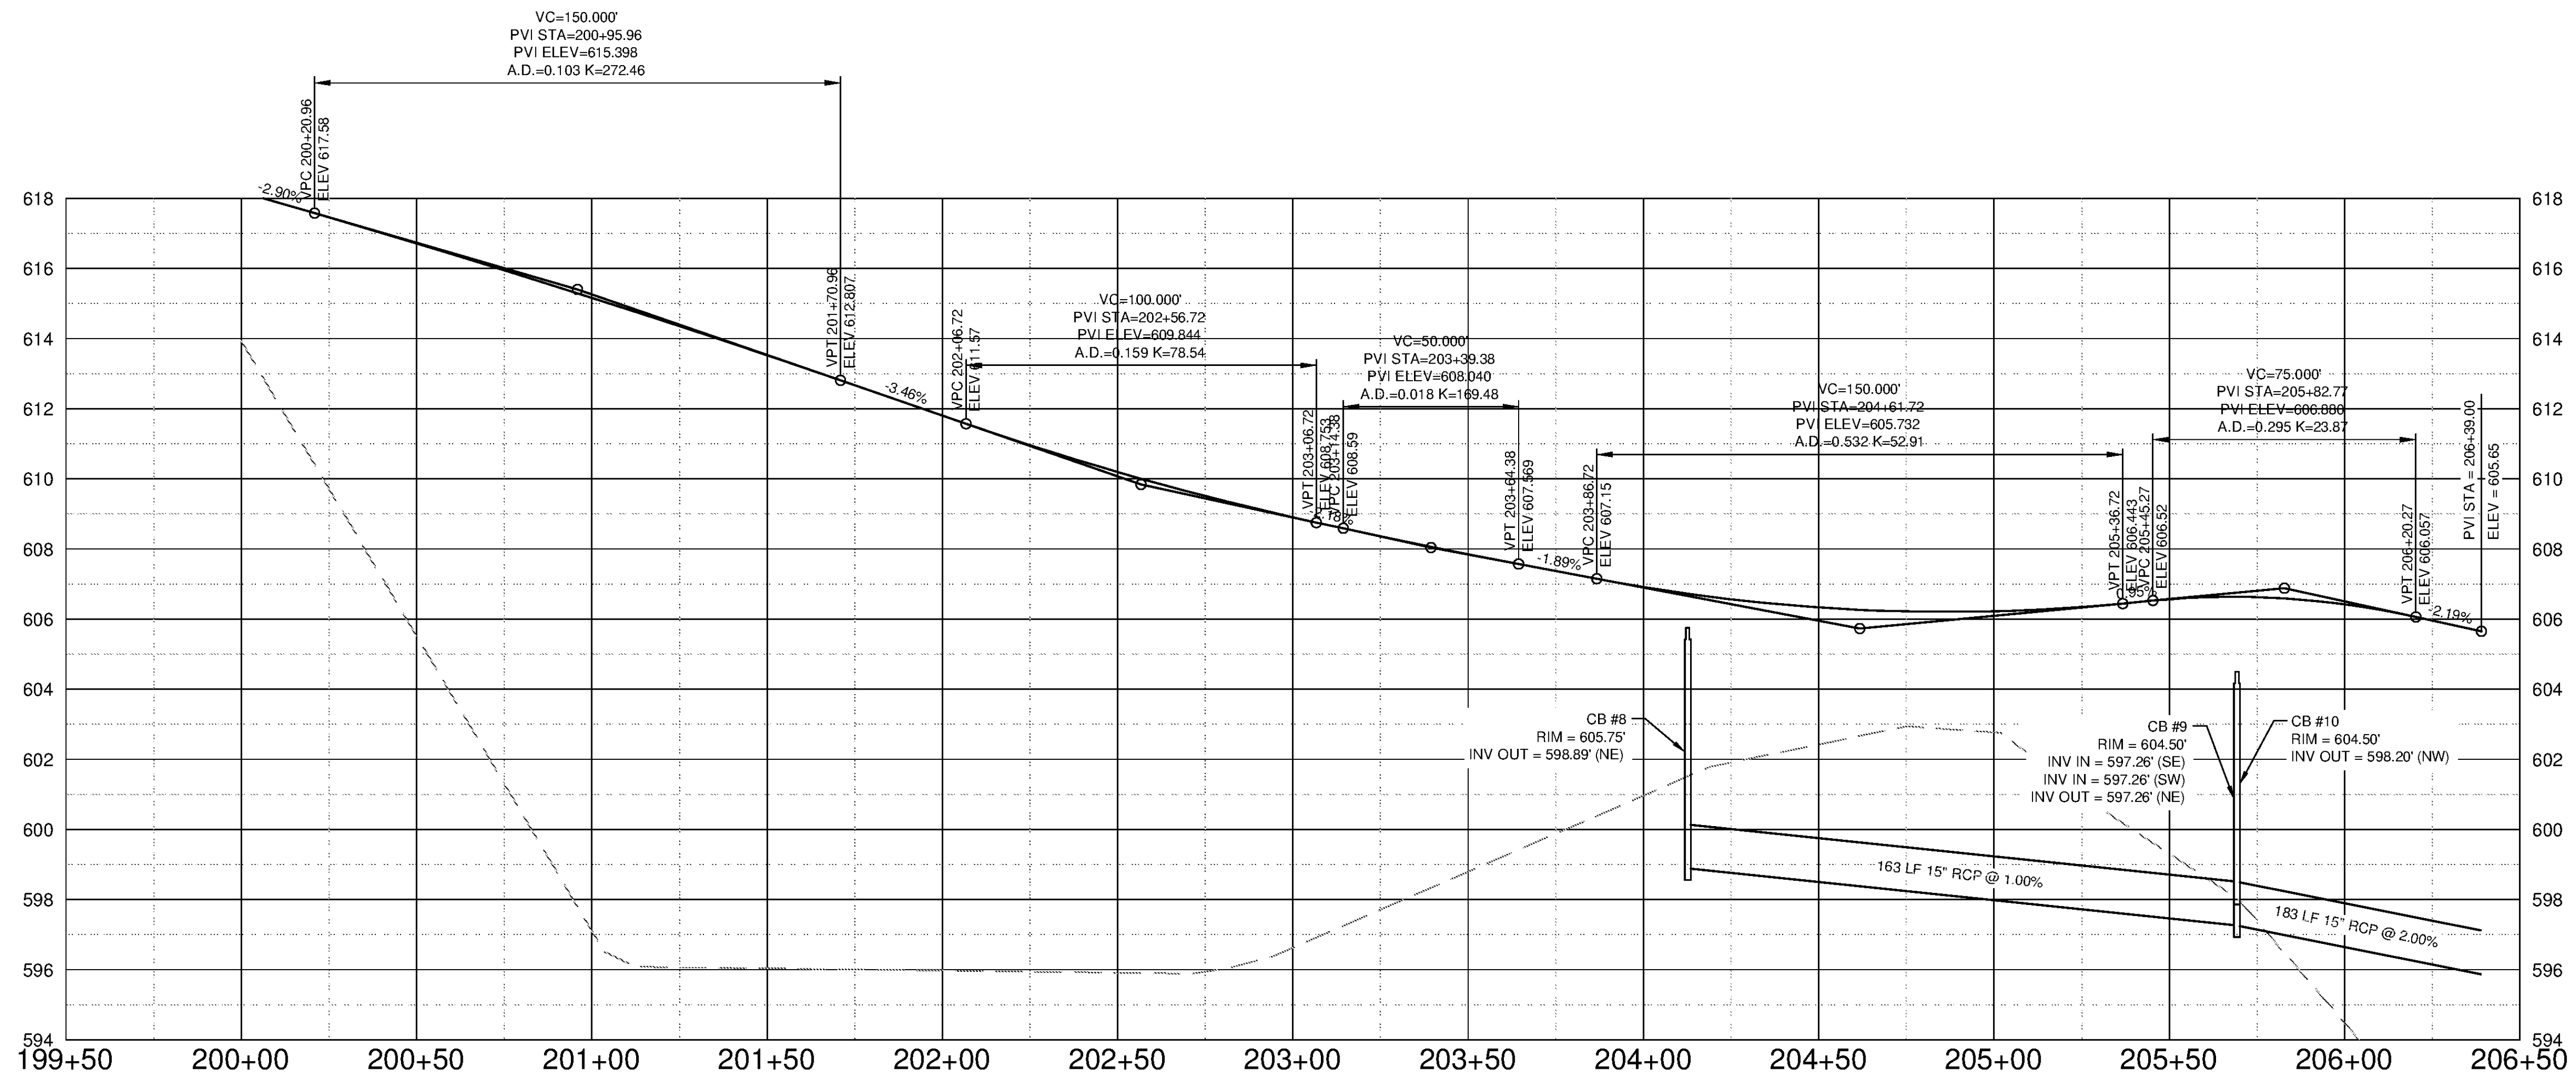


SCALE  
HORIZ. 1" = 30'  
VERT. 1" = 3'

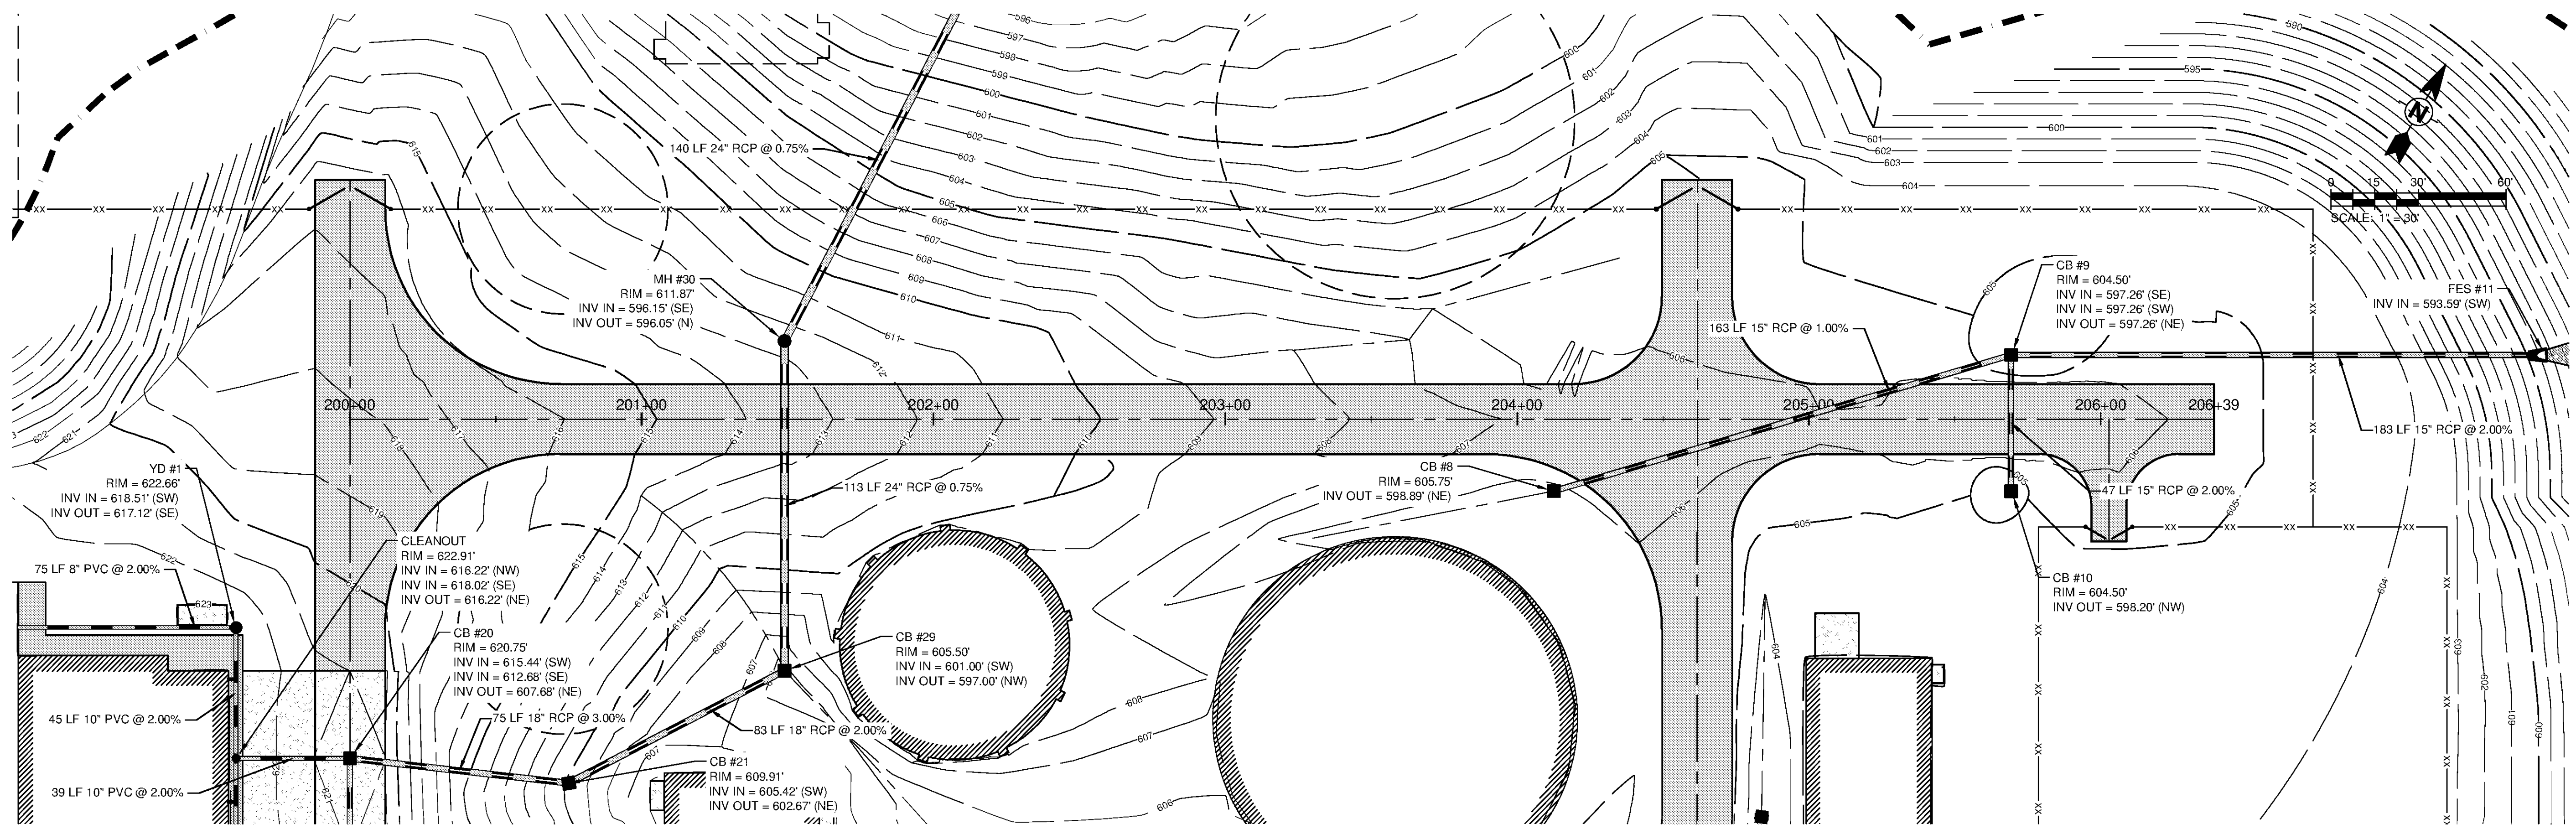

**TETRA TECH**

www.tetrattech.com  
101 QUALITY CIRCLE, SUITE 140  
HUNTSVILLE, ALABAMA 35806  
PHONE: (256) 424-4077 FAX: (256) 424-4097

BID SET



BY	DATE	DESCRIPTION

HUNTSVILLE UTILITIES

SOUTHEAST WATER TREATMENT PLANT

**WTP NORTH RD**

**PLAN AND PROFILE**

Project No.: 200-11740-10003

Designed By: JRW

Drawn By: JDV

Checked By: JPT

**C-1110**

Copyright Tetra Tech

Bar Measures 1 inch