



10/1/2014 2:31:38 PM - \\NERS161FS1\PROJECTS\11740\000\11740-0003\CAD\SHEET\TREATMENT PLANT\WP C-1117 SOUTH RD PLAN AND PROFILE.DWG - REYES, HECTOR

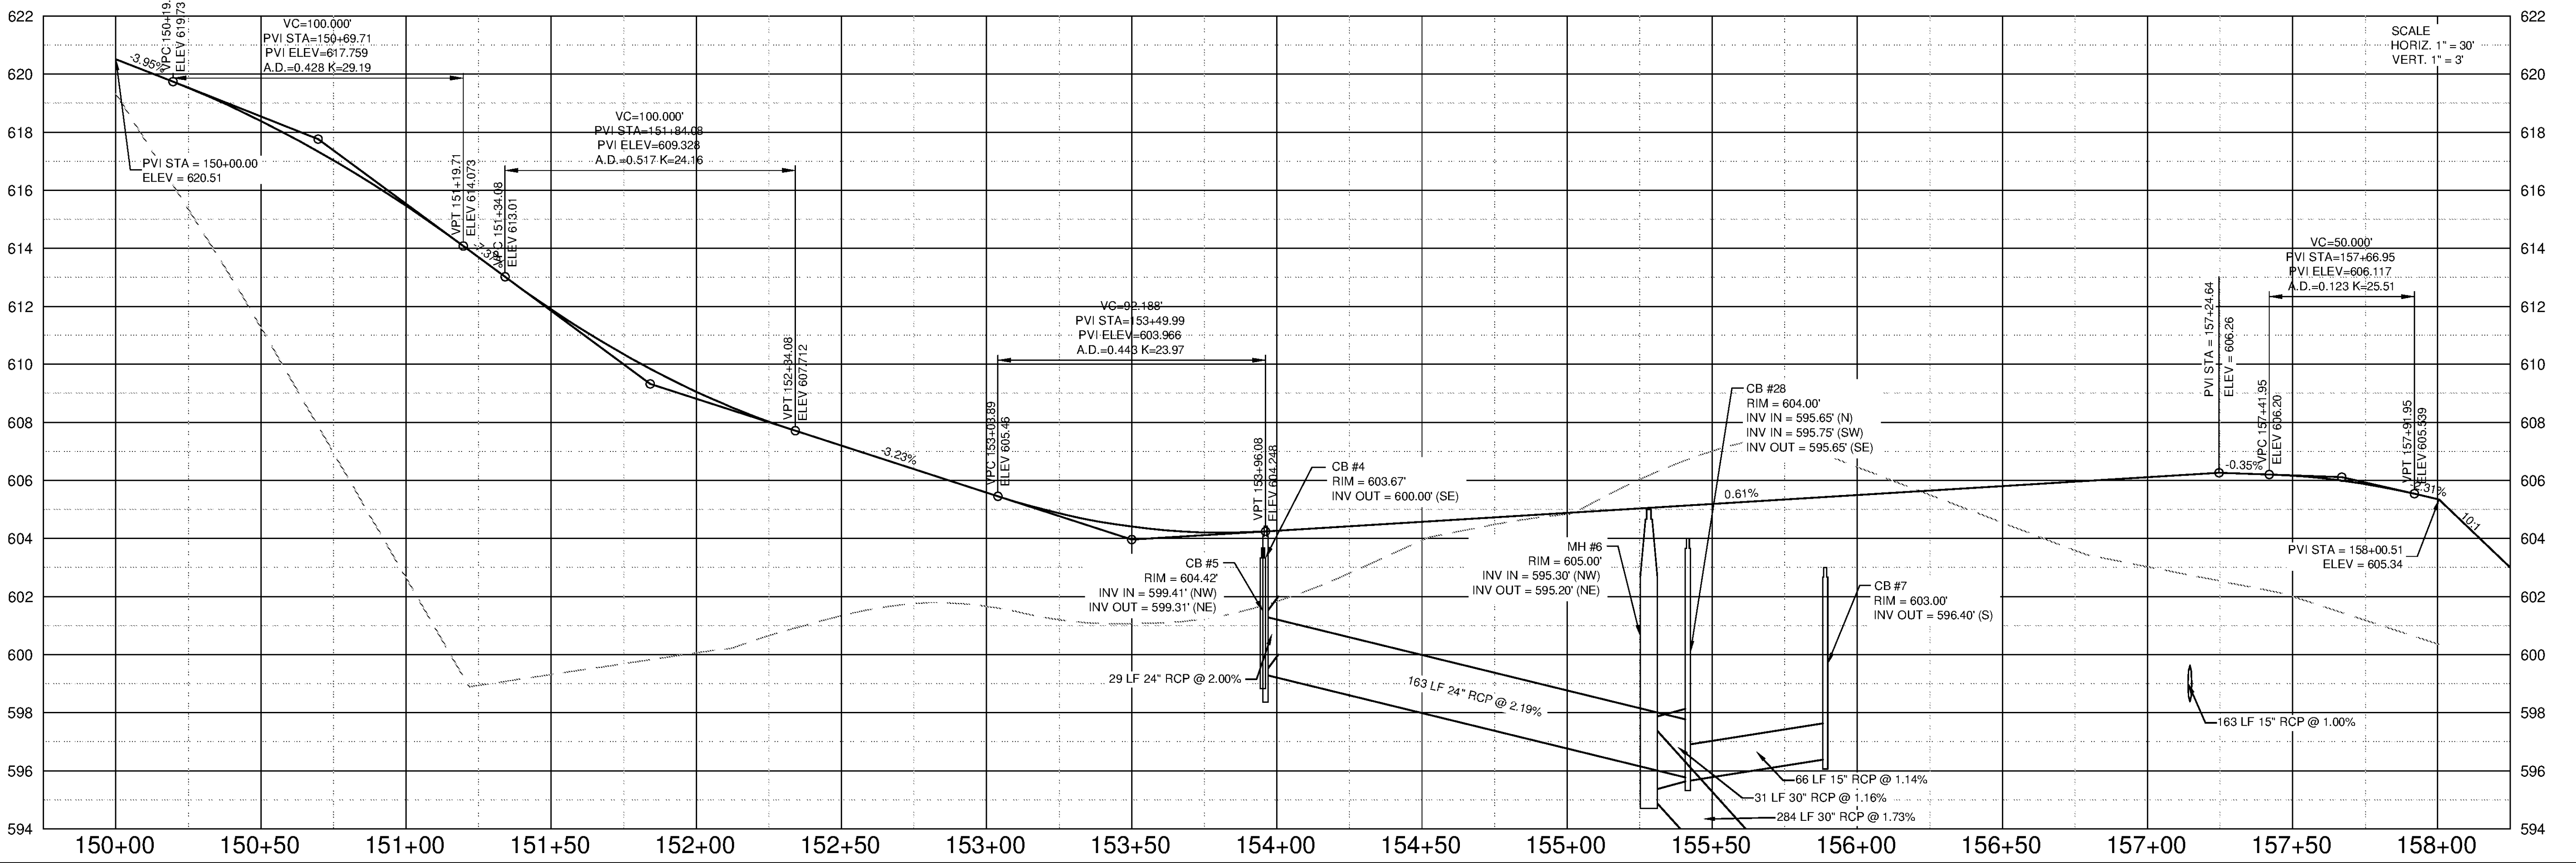

BID SET

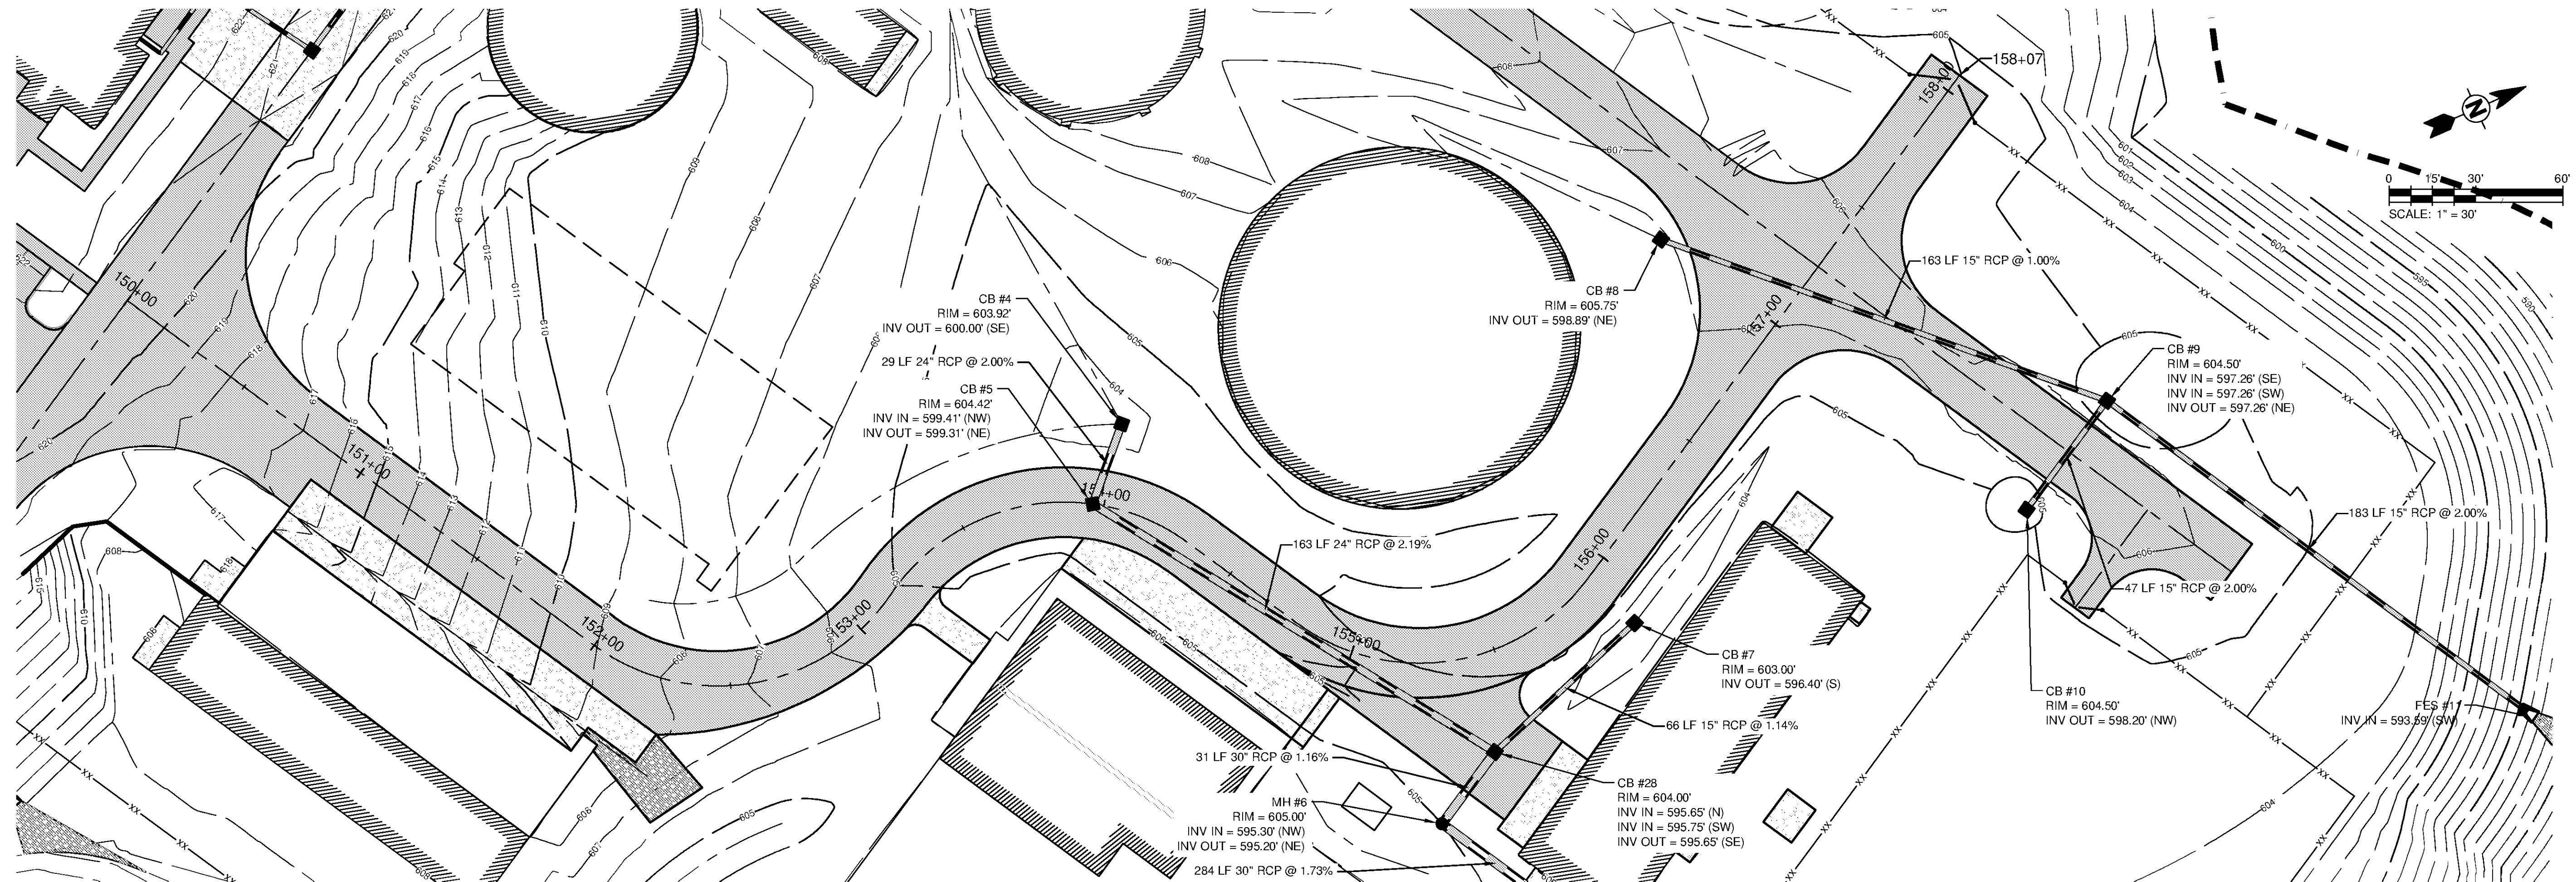

BY	DATE	DESCRIPTION

MARK	DATE	DESCRIPTION

HUNTSVILLE UTILITIES
SOUTHEAST WATER TREATMENT PLANT
WTP SOUTH RD
PLAN AND PROFILE

Project No.: 200-11740-10003
Designed By: JRW
Drawn By: WDV
Checked By: JPT

C-1111

Bar Measures 1 inch

Copyright Tetra Tech