
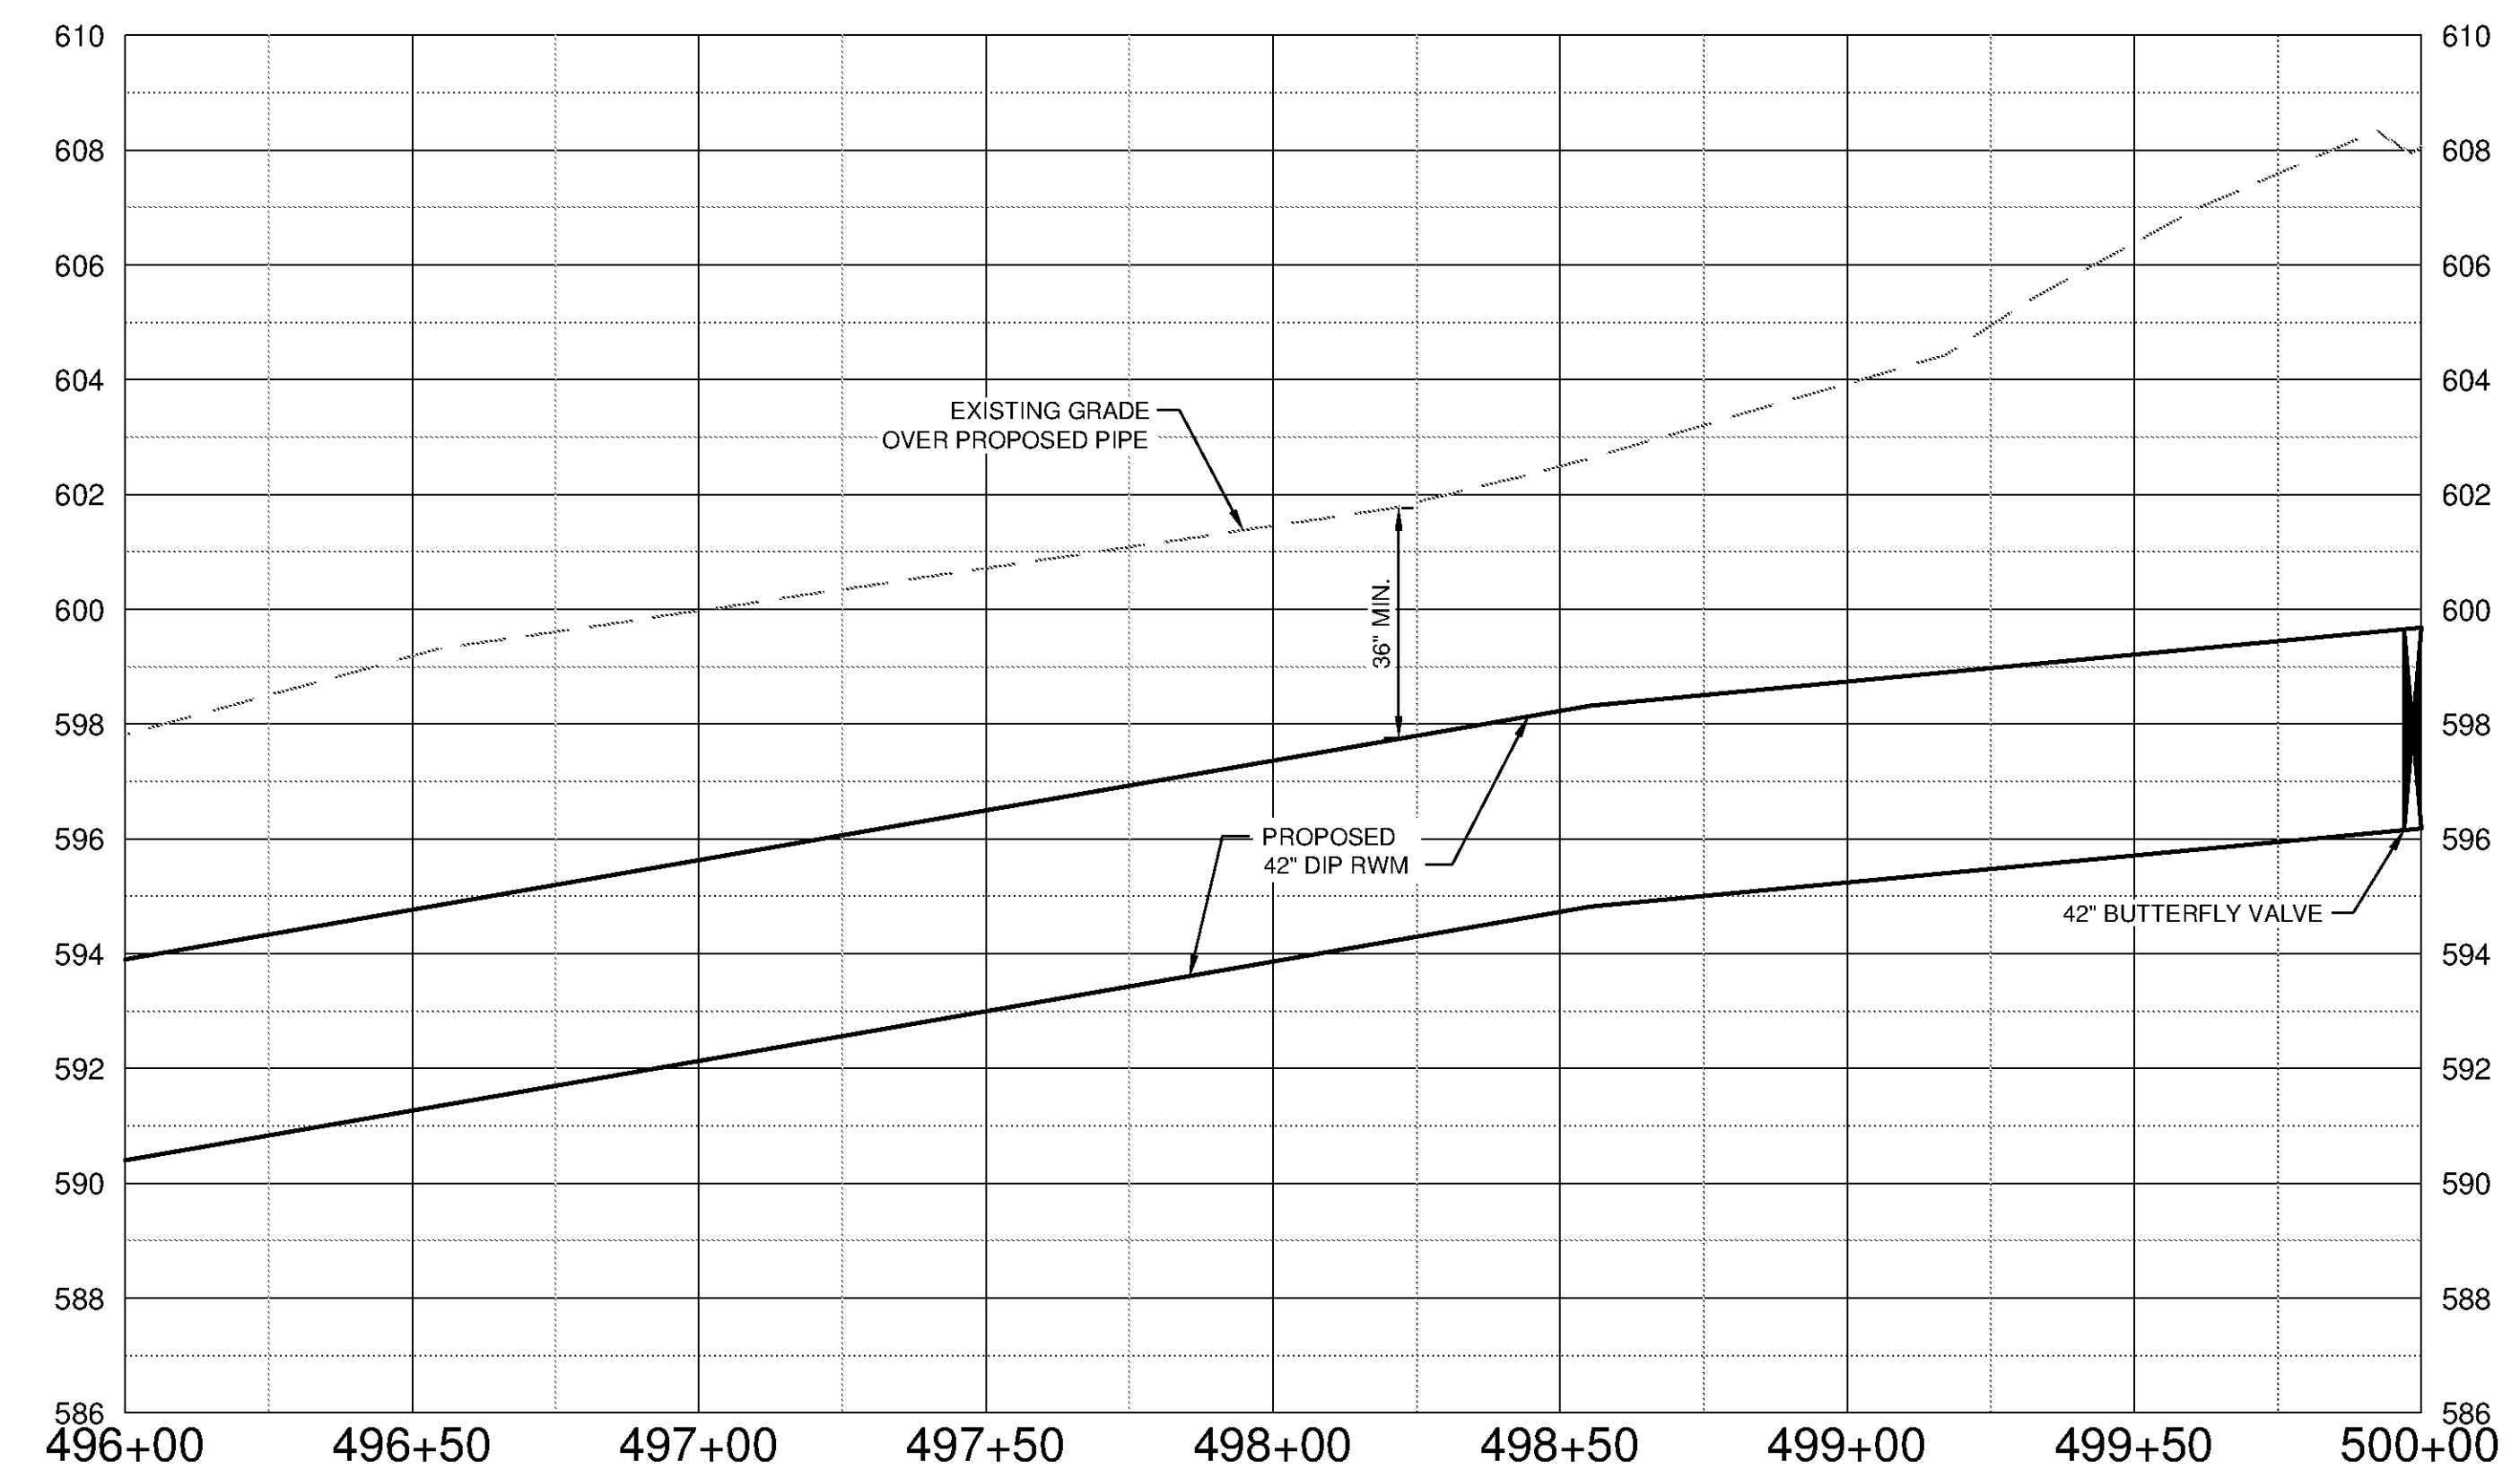
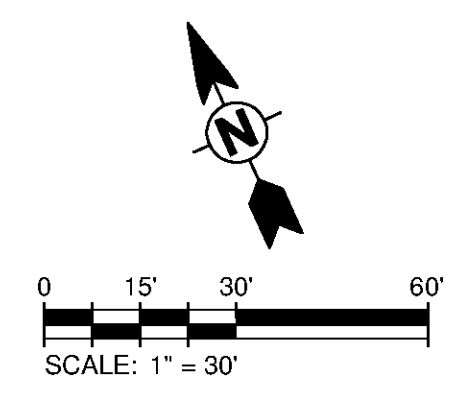


1 2 3 4 5 6 7

F  
E  
D  
C  
B  
A

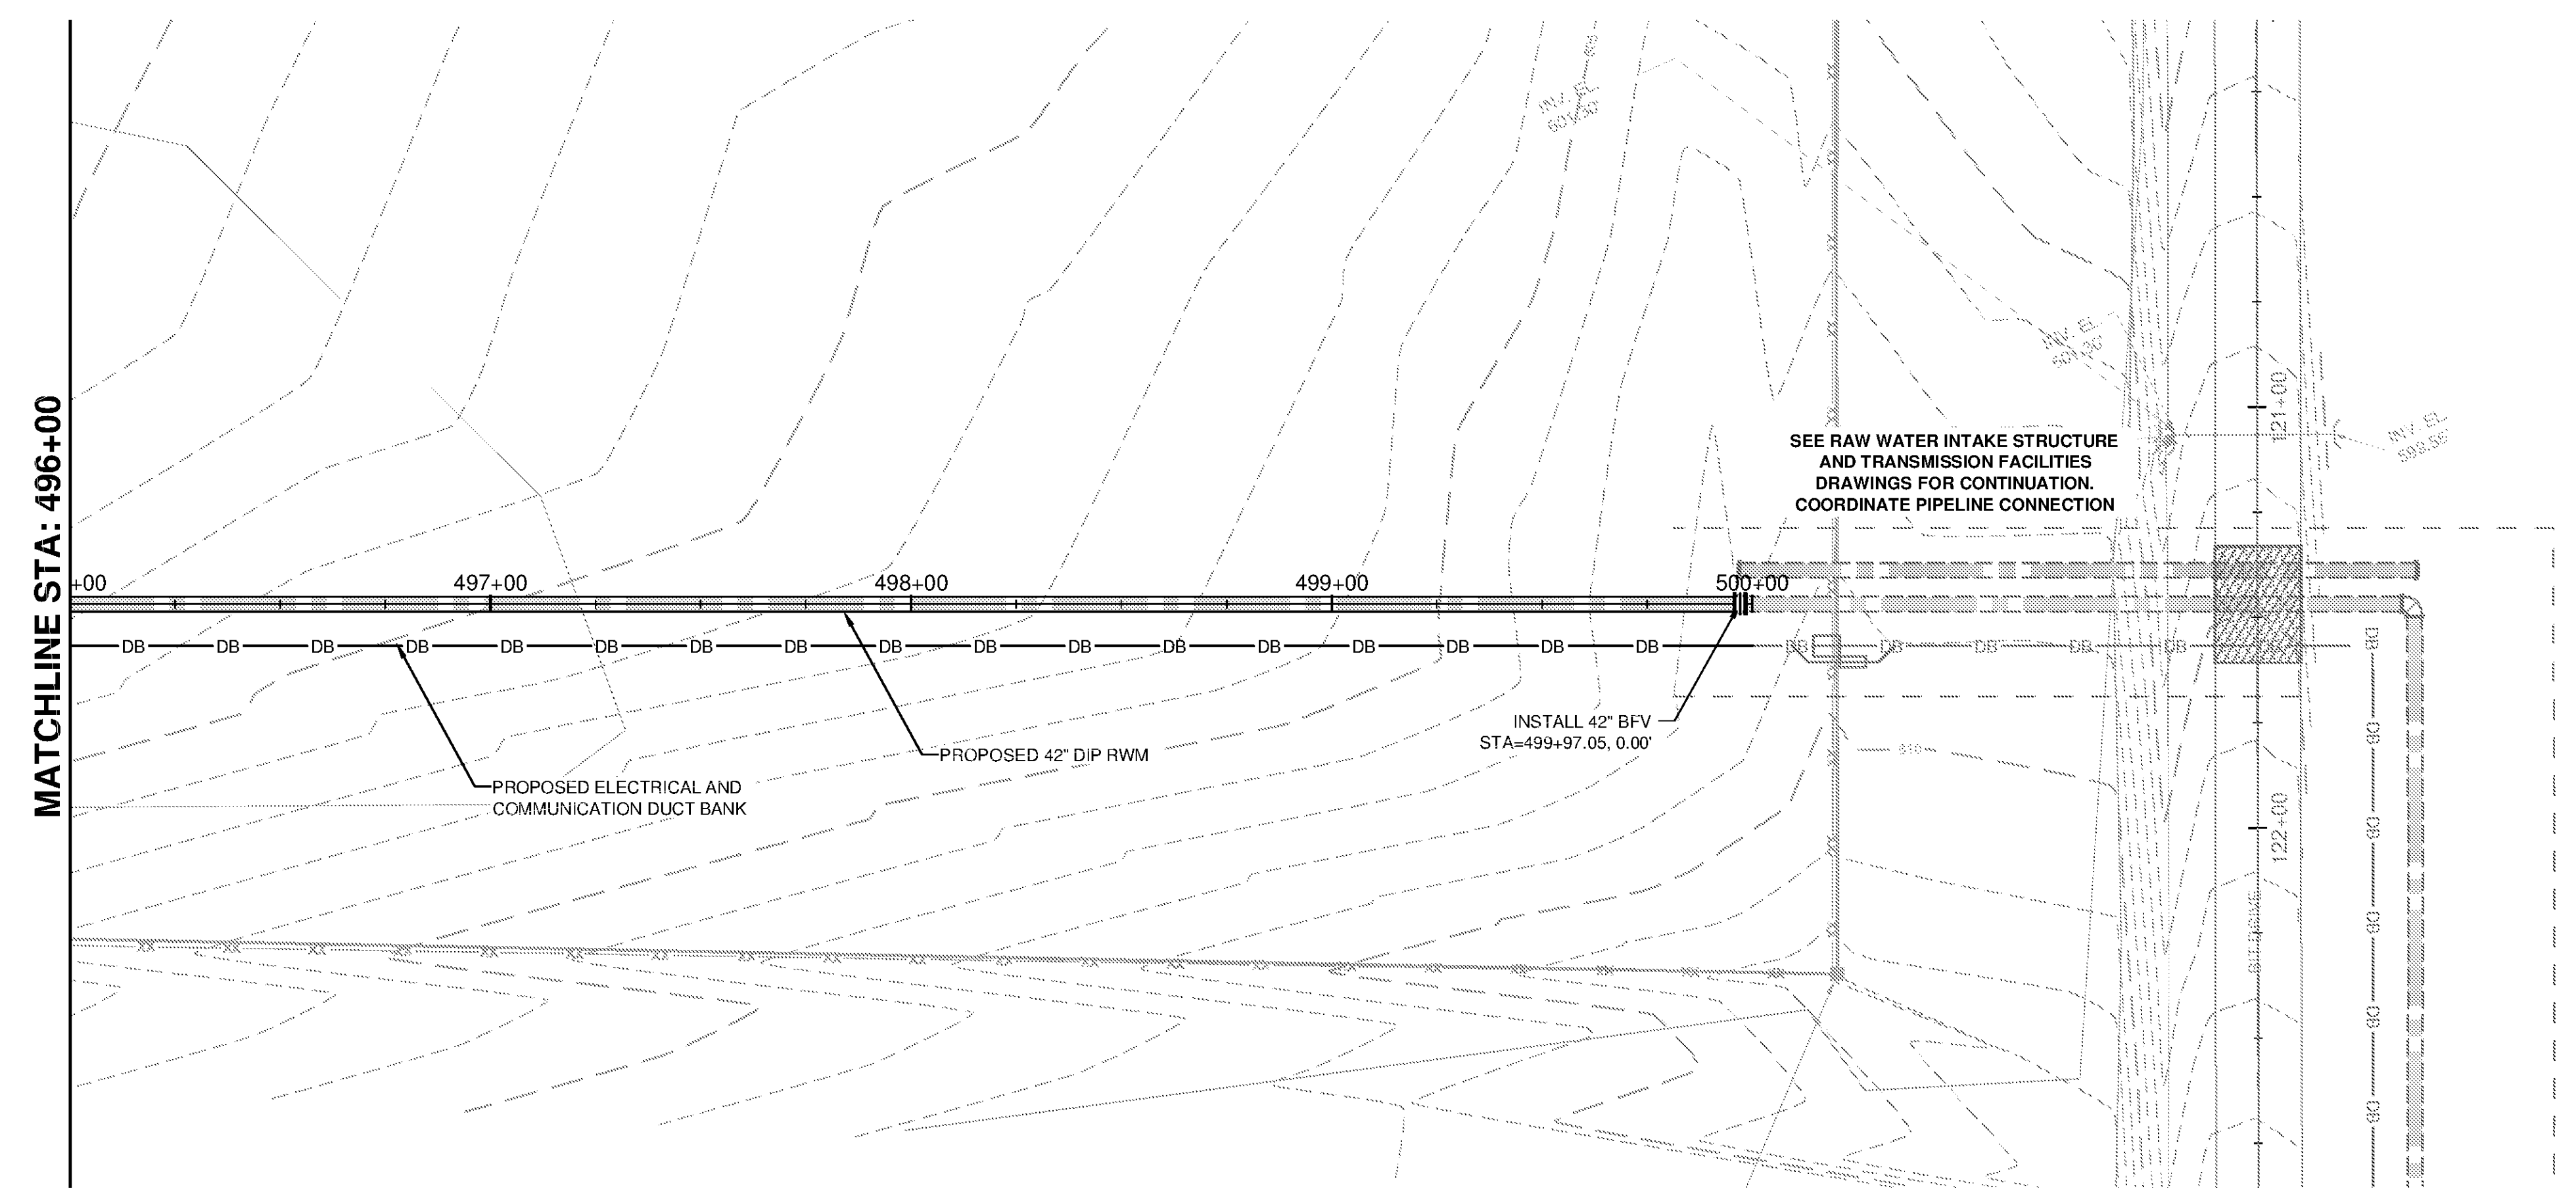

SCALE  
HORIZ. 1" = 30'  
VERT. 1" = 3'

10/9/2014 4:09:11 PM - P:\ERI\1740\200-11740-10003\CAD\SHEETFILES\TREATMENT PLANT\FW-C-2001 TO C-2002.DWG - DAVALOS, PAULA

**TETRA TECH**  
www.tetra-tech.com  
101 QUALITY CIRCLE, SUITE 140  
HUNTSVILLE, ALABAMA 35806  
PHONE: (256) 424-4077 FAX: (256) 424-4097

BID SET  
Professional Engineer Seal for Alabama, License No. 10123, dated 10/1/13.

MARK	DATE	DESCRIPTION	BY

HUNTSVILLE UTILITIES  
SOUTHEAST WATER TREATMENT PLANT  
**RAW WATER MAIN  
PLAN AND PROFILE  
STA 496+00 TO 500+00**

Project No.: 200-11740-10003  
Designed By: DNL  
Drawn By: WDV  
Checked By: JPT

**C-2001**

Copyright: Tetra Tech  
Bar Measures 1 inch