
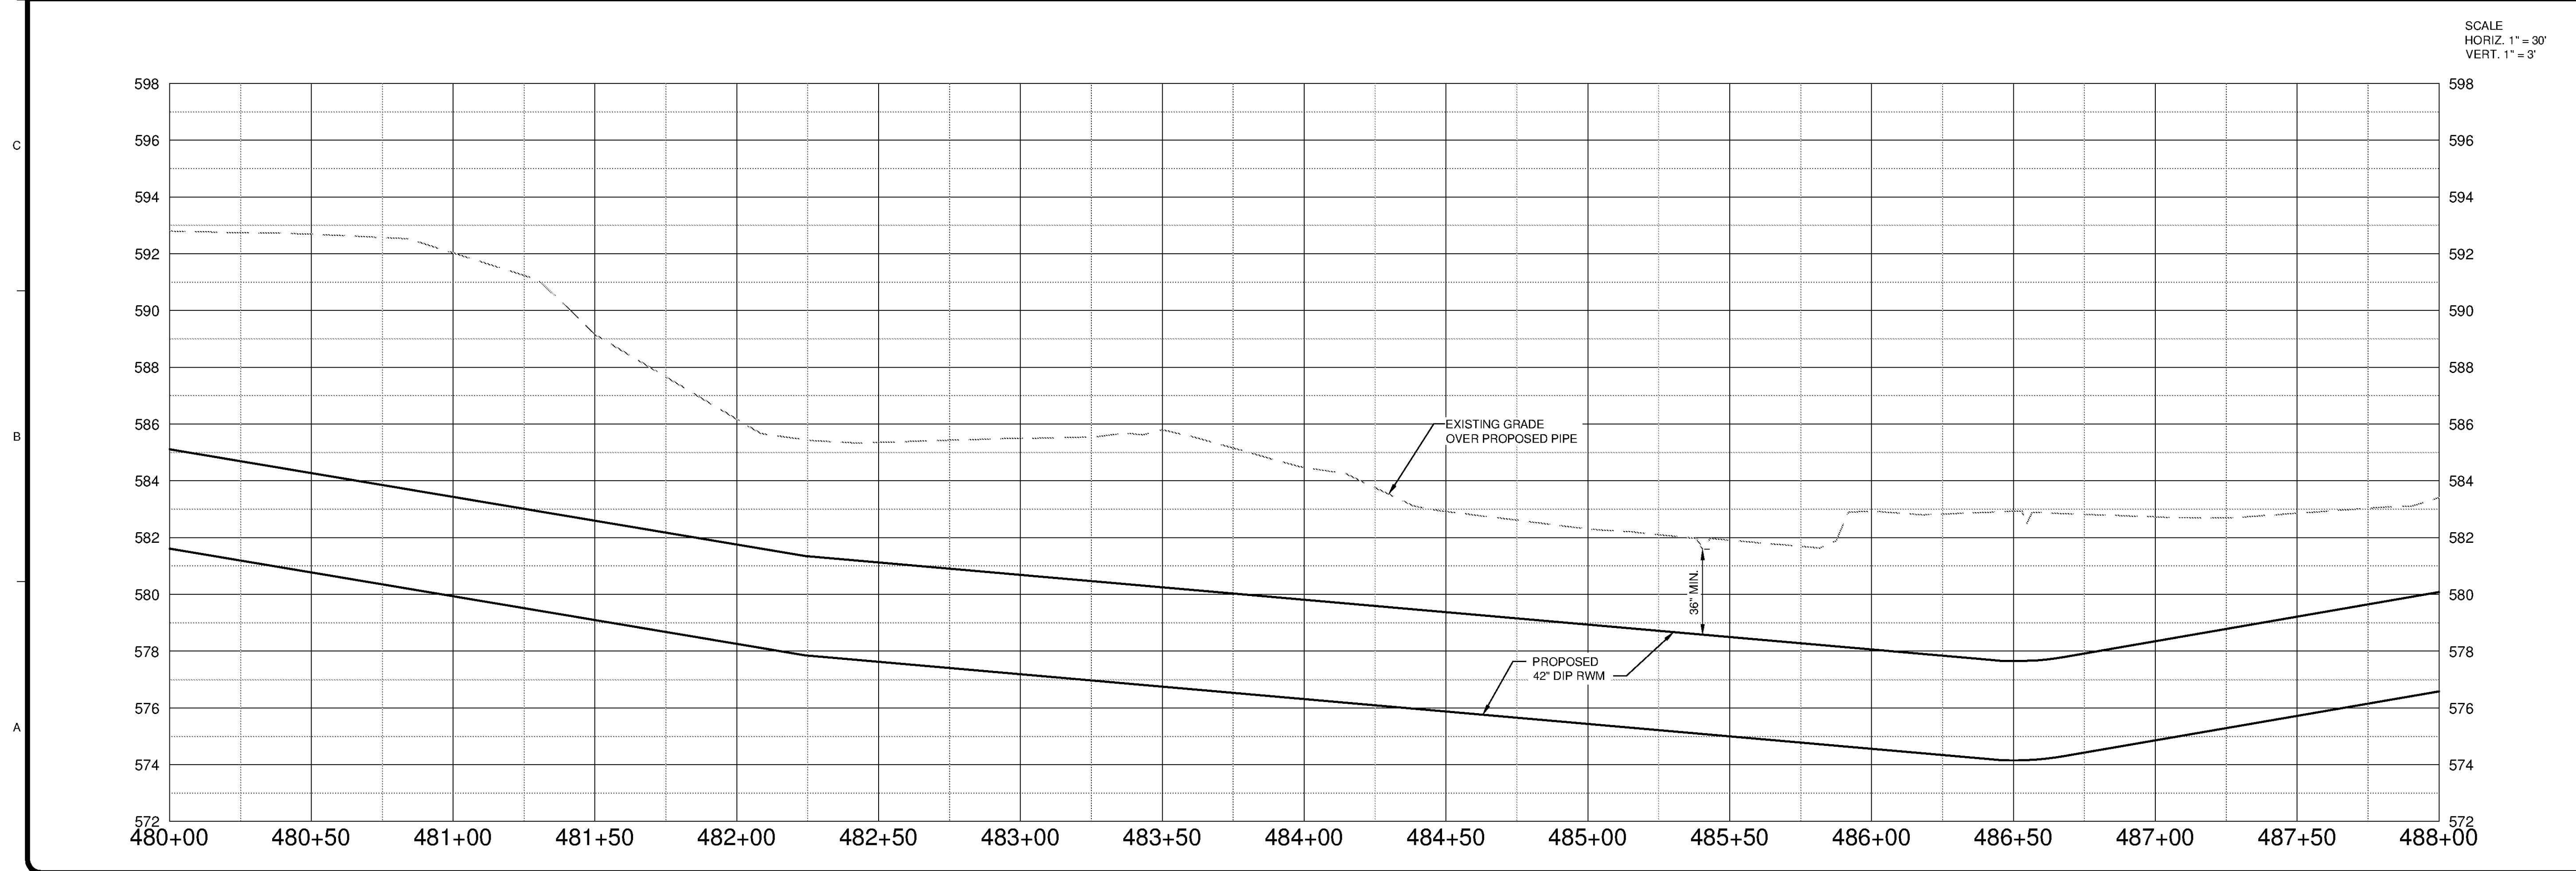


10/9/2014 4:16:21 PM - P:\IER\11740\200-11740-10003\CAD\SHEETFILES\TREATMENT PLANT\FW-C-2003 TO C-2006.DWG - DAVALOS, PAULA

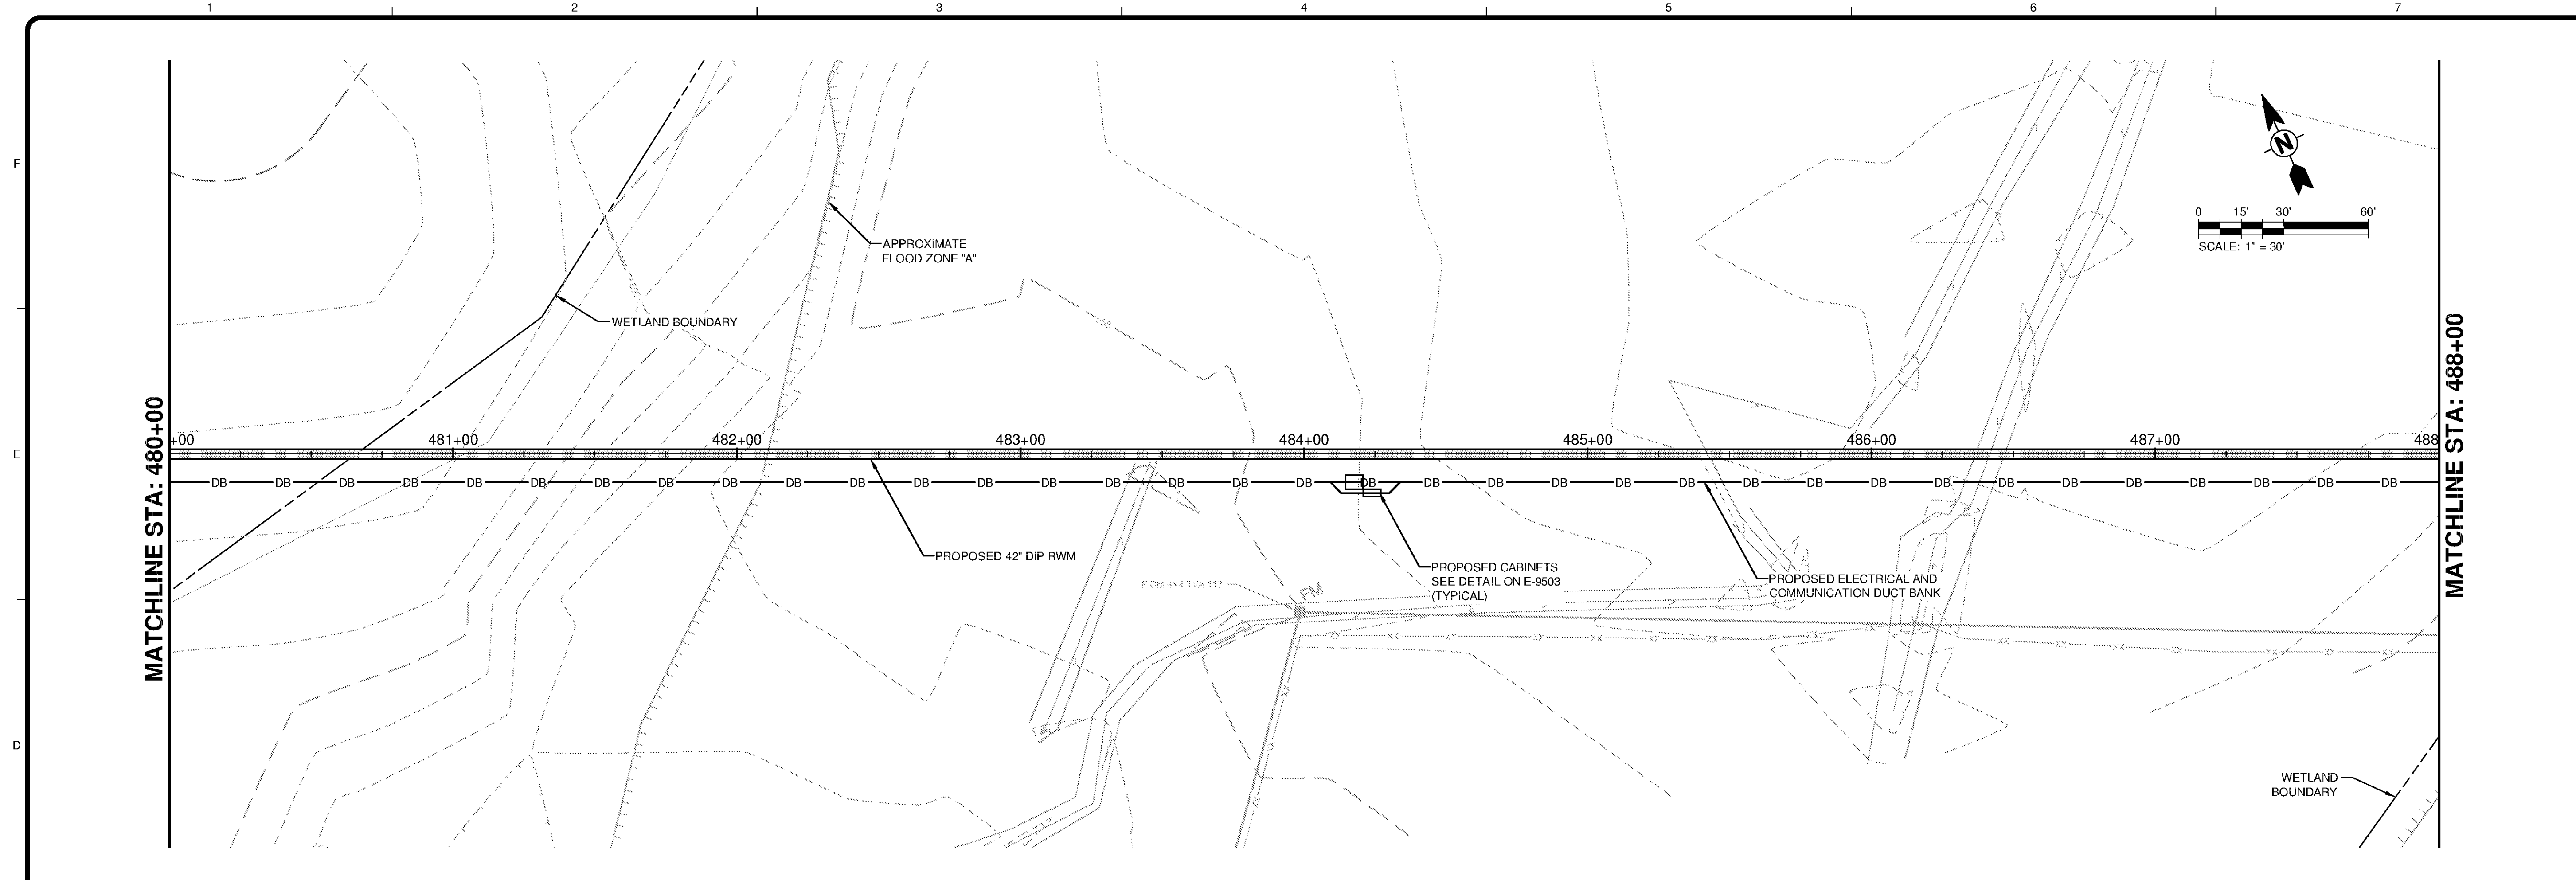

TETRA TECH
www.tetra-tech.com
101 QUALITY CIRCLE, SUITE 140
HUNTSVILLE, ALABAMA 35806
PHONE: (256) 424-4077 FAX: (256) 424-4097

BID SET
Professional Engineer Seal for Paula Davalos, State of Alabama, License No. 10124.

BY	DATE	DESCRIPTION

MARK	DATE	DESCRIPTION

HUNTSVILLE UTILITIES
SOUTHEAST WATER TREATMENT PLANT
**RAW WATER MAIN
PLAN AND PROFILE
STA 480+00 TO 488+00**

Project No.: 200-11740-10003
Designed By: DNL
Drawn By: WDV
Checked By: JPT

C-2003

Copyright: Tetra Tech
Bar Measures 1 inch