
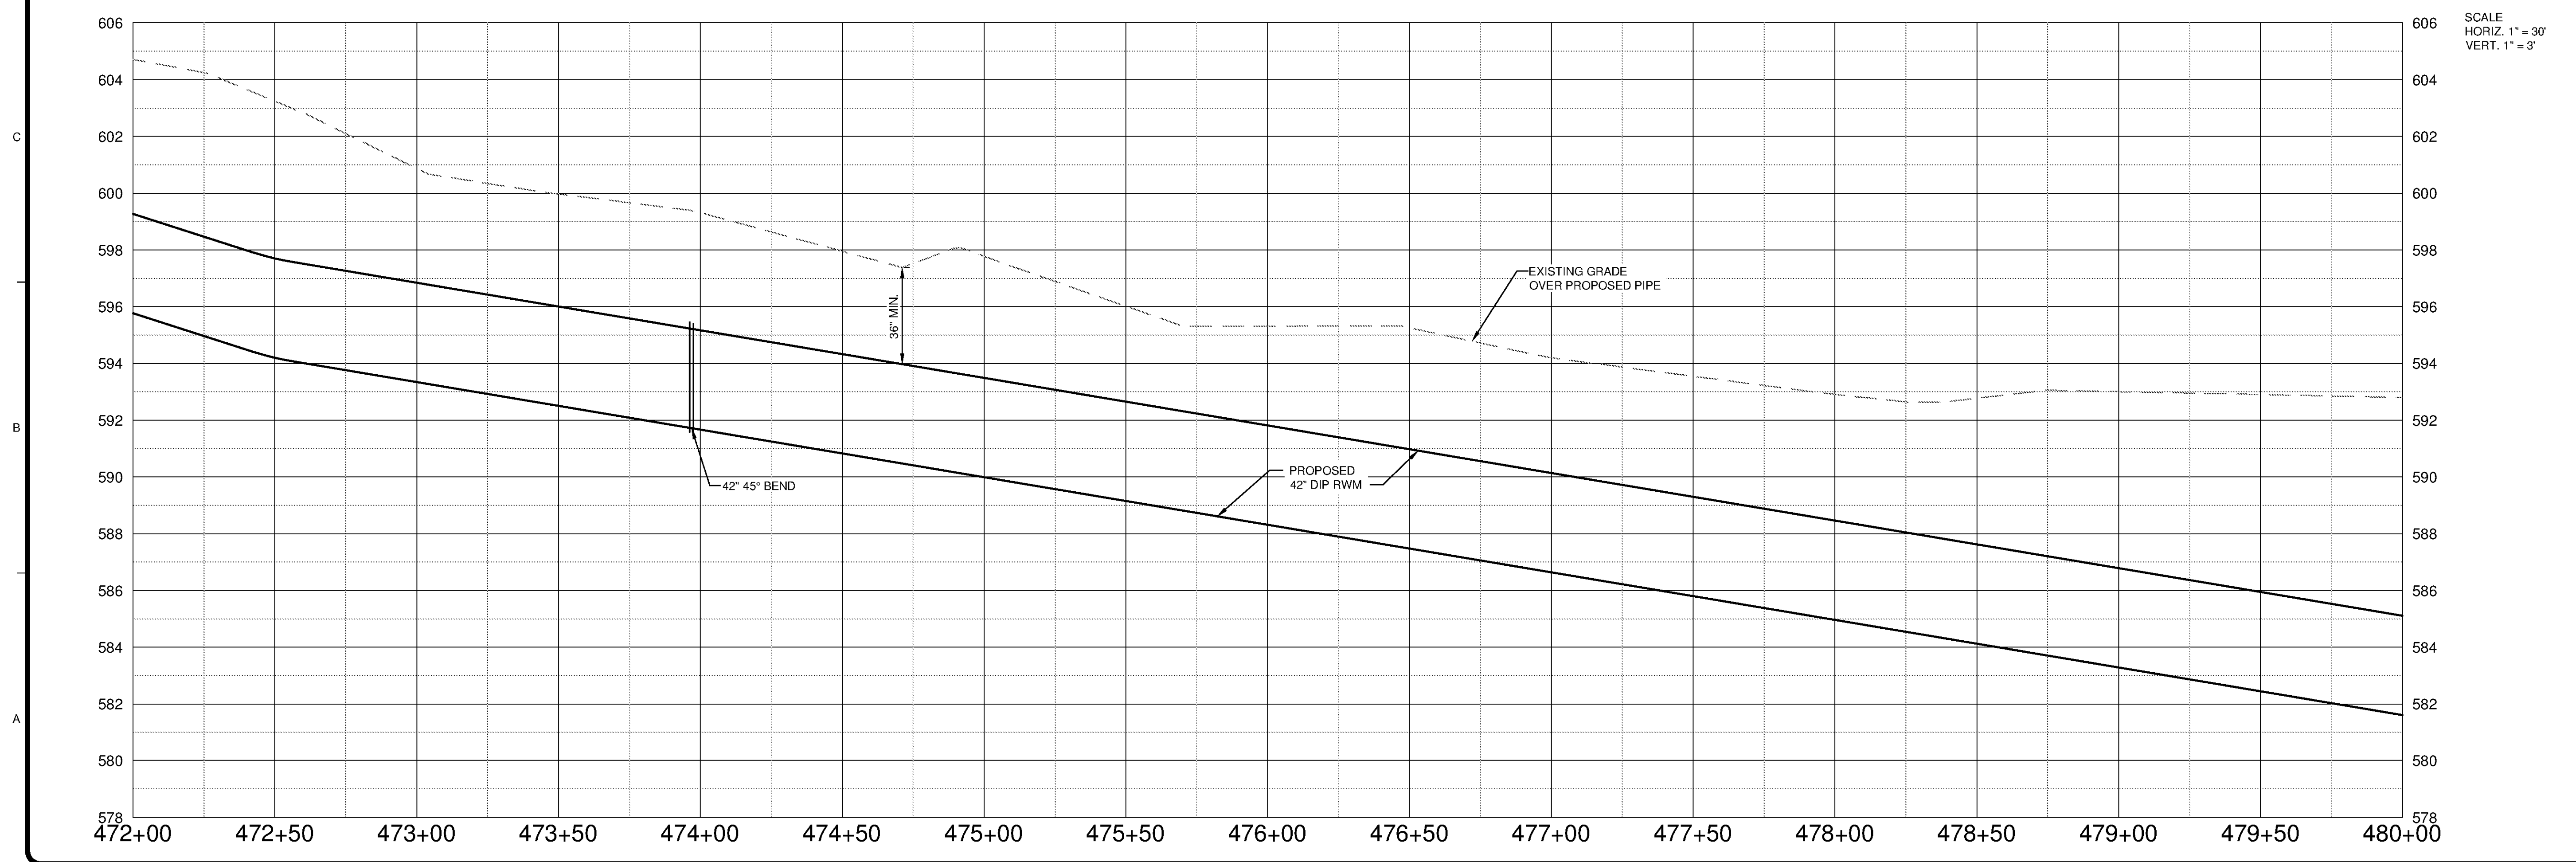
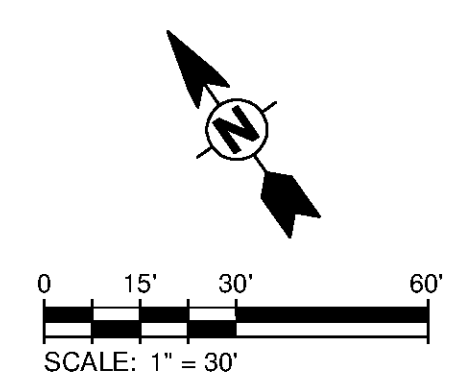


10/9/2014 4:18:46 PM - P:\IER\11740\200-11740-10003\CAD\SHEETFILES\TREATMENT PLANT\FWC-2003 TO C-2006.DWG - DAVALOS, PAULA

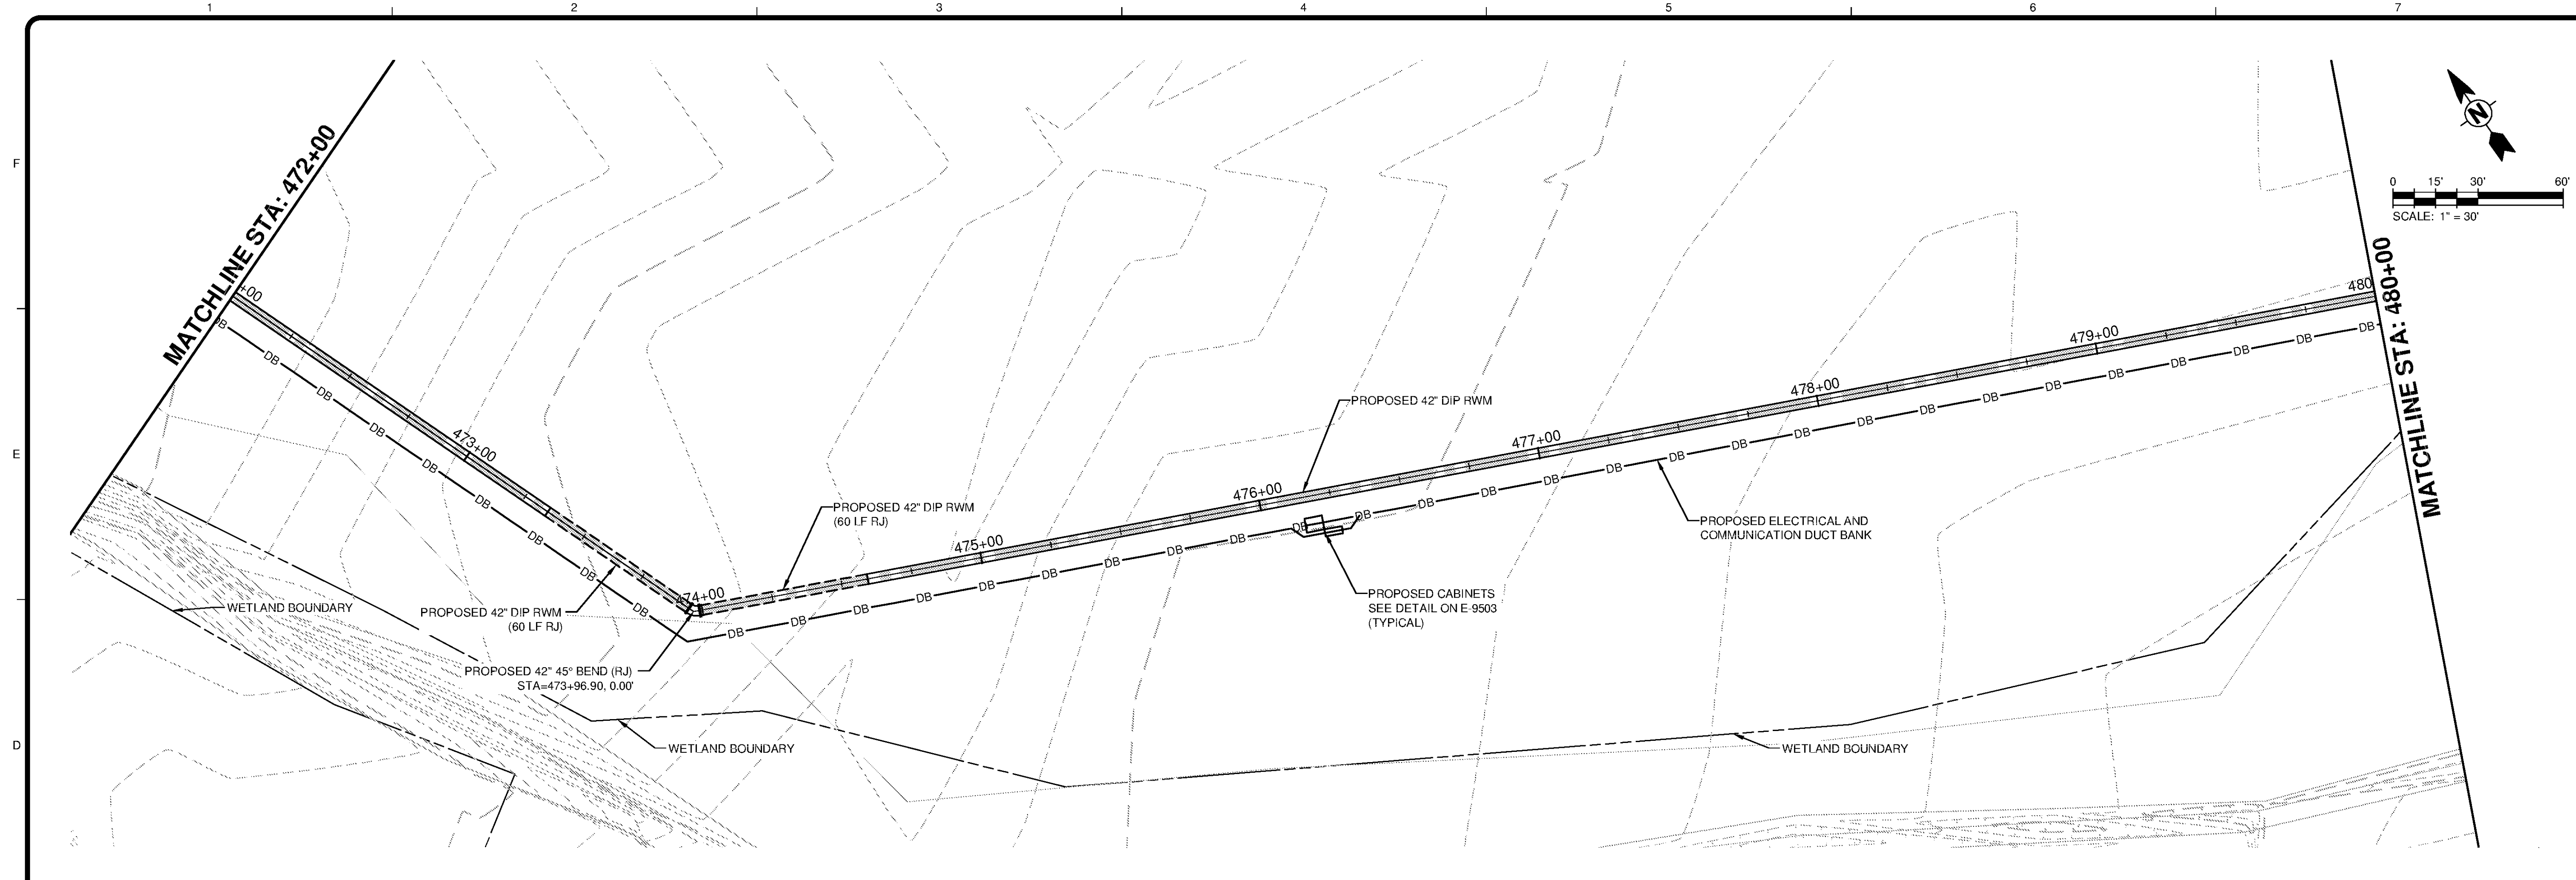

SCALE
HORIZ. 1" = 30'
VERT. 1" = 3'

TETRA TECH
www.tetra.tech.com
101 QUALITY CIRCLE, SUITE 140
HUNTSVILLE, ALABAMA 35806
PHONE: (256) 424-4077 FAX: (256) 424-4097

BID SET

BY	DATE	DESCRIPTION

MARK	DATE	DESCRIPTION

HUNTSVILLE UTILITIES
SOUTHEAST WATER TREATMENT PLANT
**RAW WATER MAIN
PLAN AND PROFILE
STA 472+00 TO 480+00**

Project No.: 200-11740-10003
Designed By: DNL
Drawn By: WDV
Checked By: JPT

C-2004

Copyright Tetra Tech
Bar Measures 1 inch