

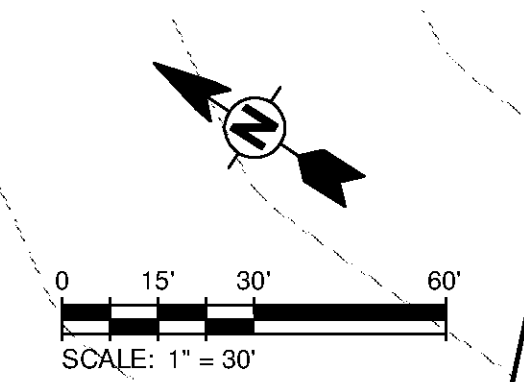
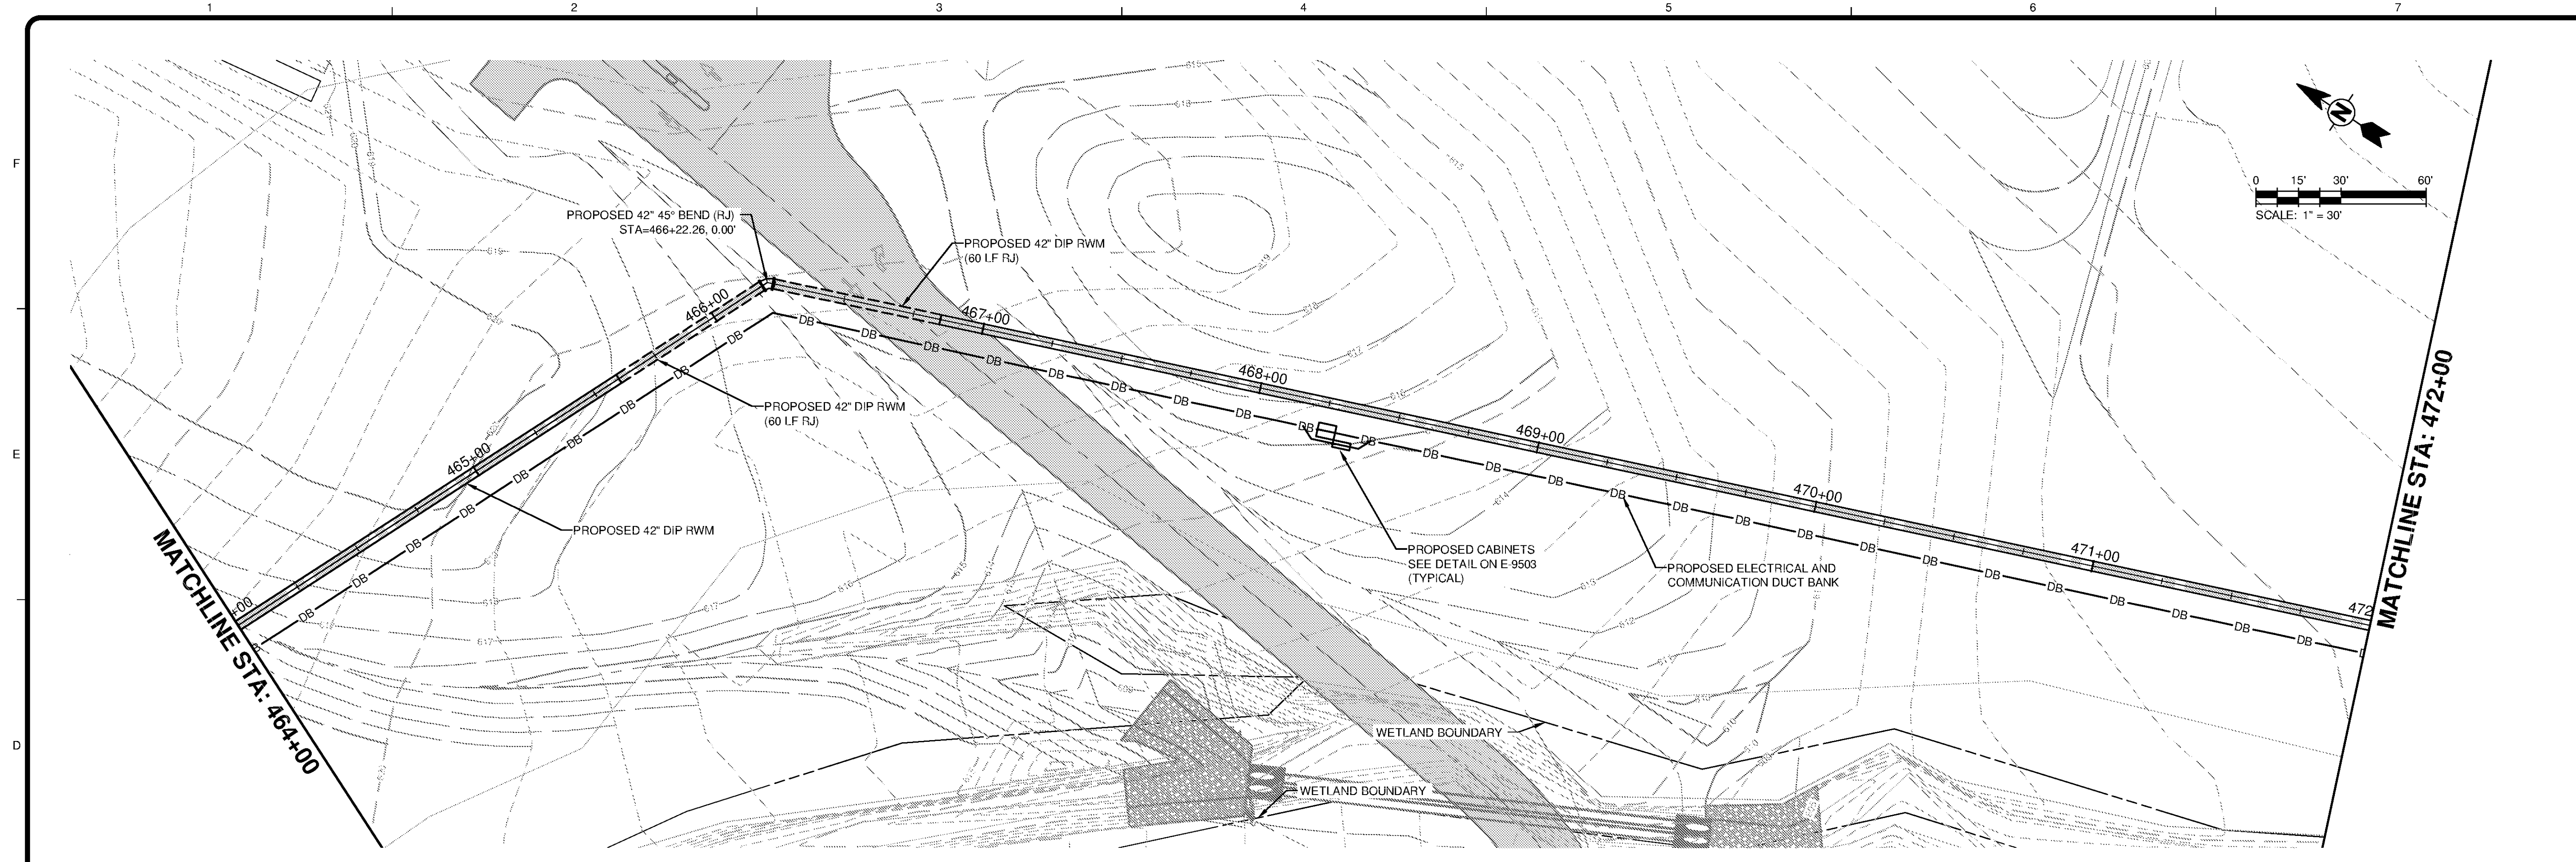


10/9/2014 4:21:13 PM - P:\IER\11740\200-11740-10003\CAD\SHSHEETFILES\TREATMENT PLANT\FWC-2003 TO C-2006.DWG - DAVALOS, PAULA

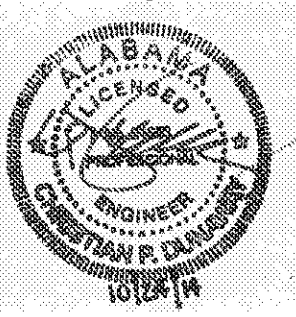

**TETRA TECH**  
  
 www.tetrattech.com  
 101 QUALITY CIRCLE, SUITE 140  
 HUNTSVILLE, ALABAMA 35806  
 PHONE: (256) 424-4077 FAX: (256) 424-4097

BID SET  

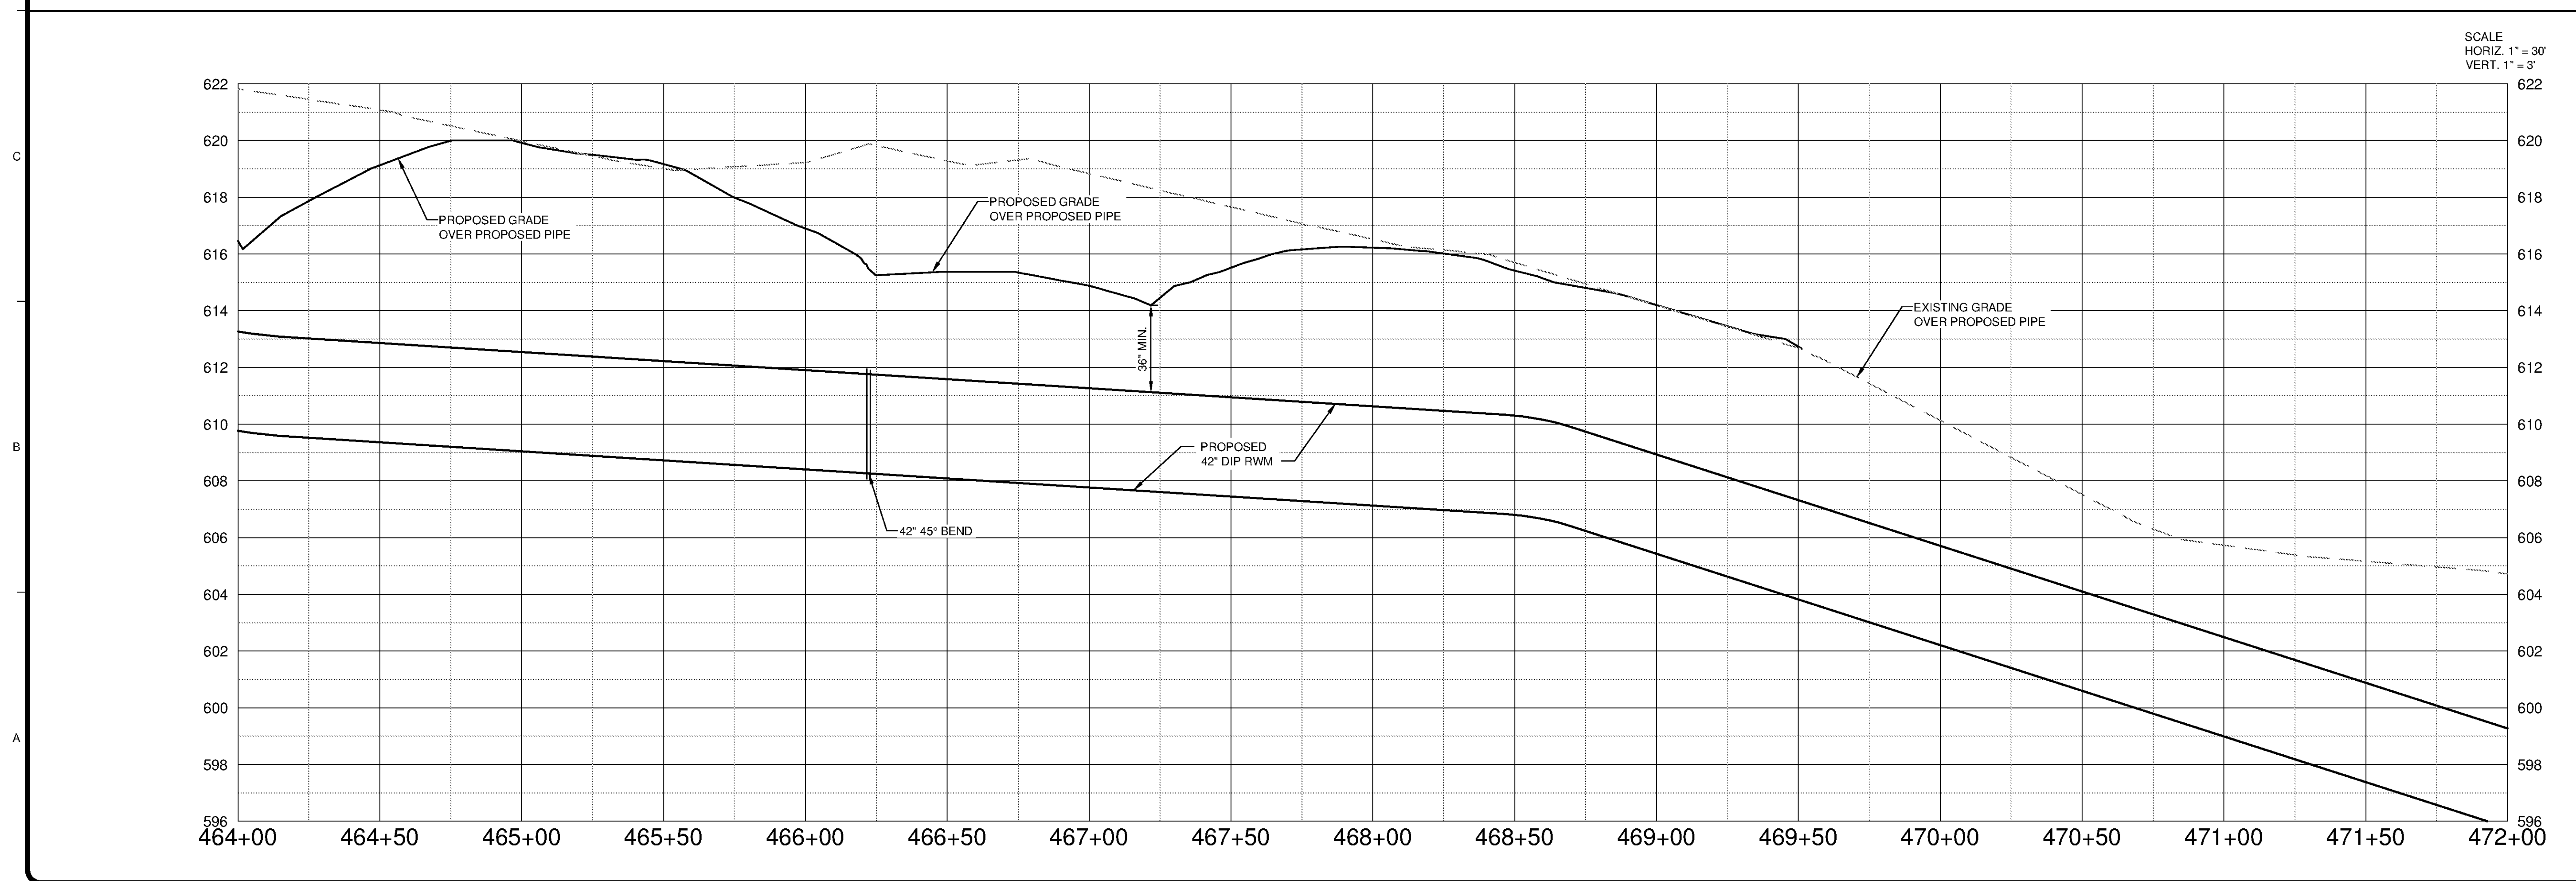


SCALE  
 HORIZ. 1" = 30'  
 VERT. 1" = 3'

MARK	DATE	DESCRIPTION	BY

HUNTSVILLE UTILITIES  
 SOUTHEAST WATER TREATMENT PLANT  
**RAW WATER MAIN**  
**PLAN AND PROFILE**  
 STA 464+00 TO 472+00

Project No.: 200-11740-10003  
 Designed By: DNL  
 Drawn By: WDV  
 Checked By: JPT

**C-2005**

Bar Measures 1 inch

Copyright: Tetra Tech