


**TETRA TECH**  
 www.tetra.tech.com  
 101 QUALITY CIRCLE, SUITE 140  
 HUNTSVILLE, ALABAMA 35806  
 PHONE: (256) 424-4077 FAX: (256) 424-4097

BID SET

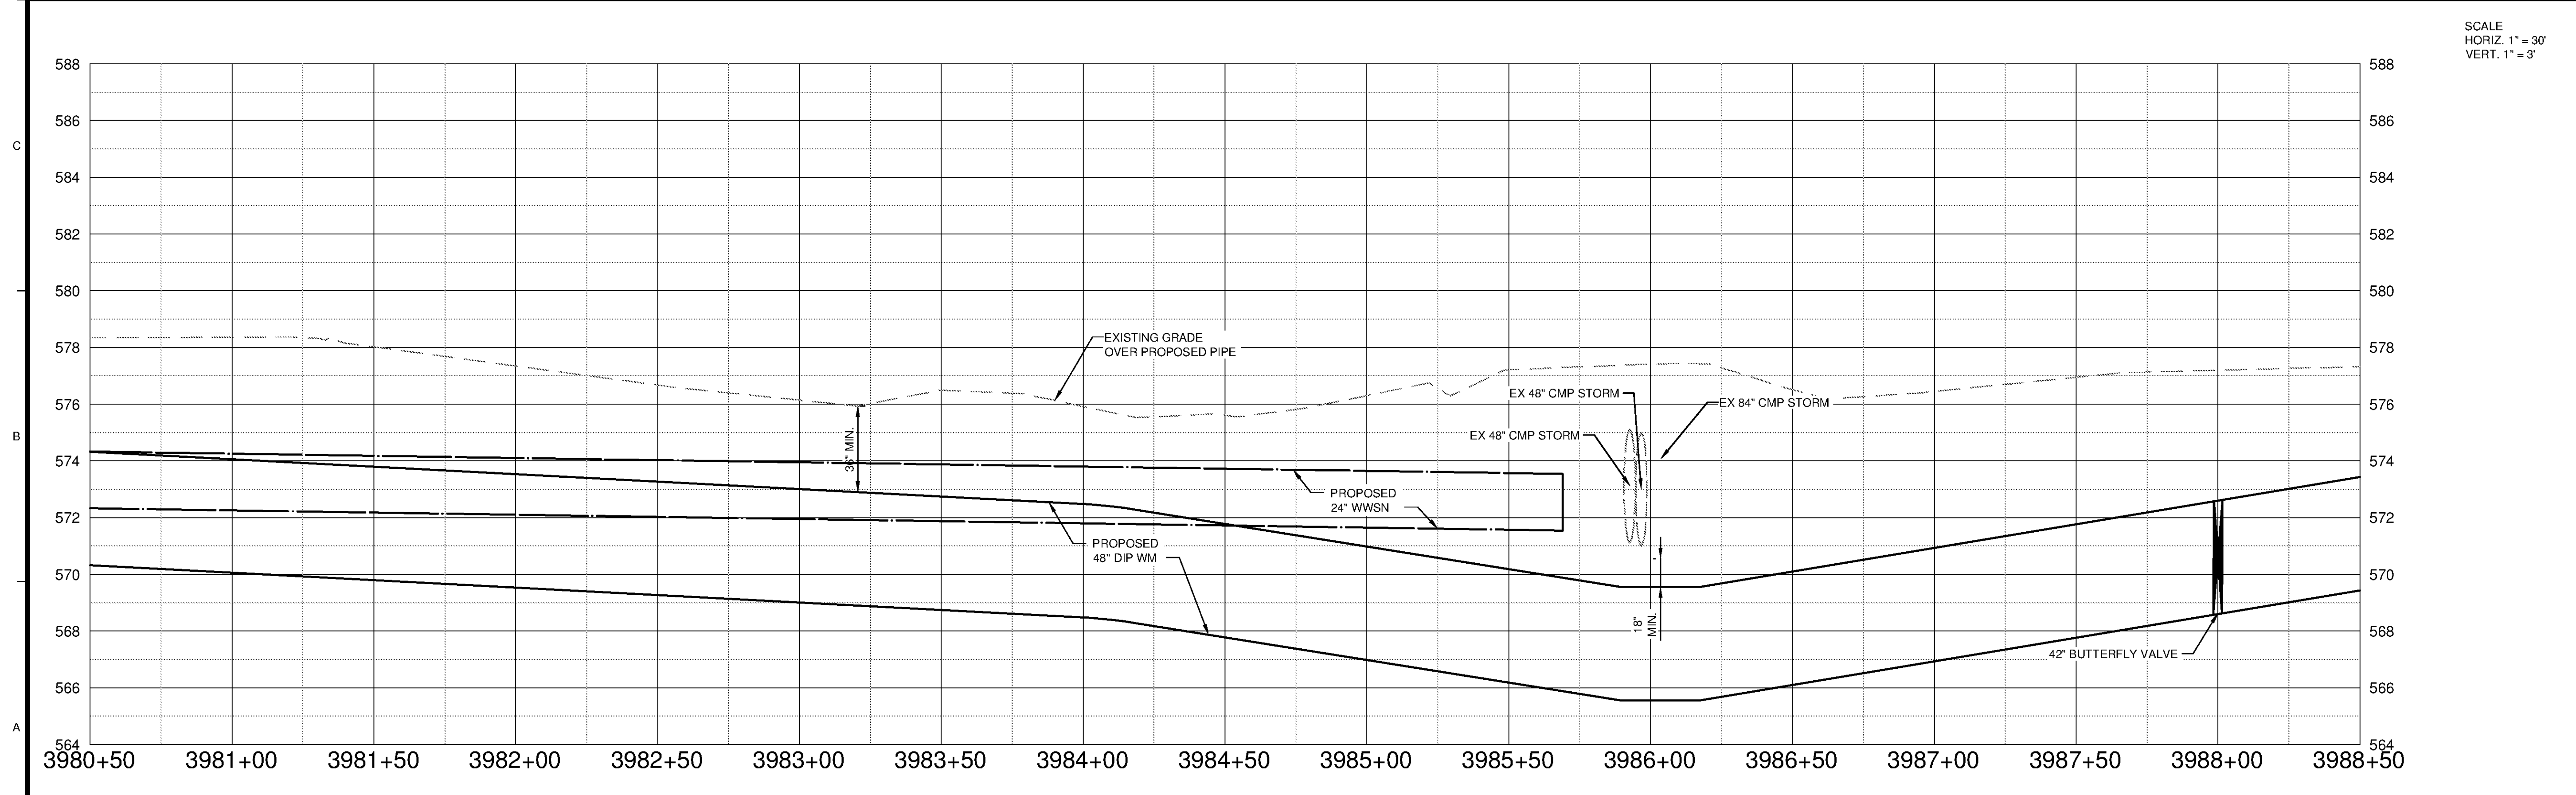

SCALE  
 HORIZ. 1" = 30'  
 VERT. 1" = 3'

10/9/2014 4:29:04 PM - P:\IER\11740\200-11740-10003\CAD\SHEETFILES\TREATMENT PLANT\FWC-2007 TO C-2010.DWG - DAVALOS, PAULA

BY	DATE	DESCRIPTION

HUNTSVILLE UTILITIES  
 SOUTHEAST WATER TREATMENT PLANT  
**FINISHED WATER MAIN  
 PLAN AND PROFILE  
 STA 3980+50 TO 3988+50**

Project No.: 200-11740-10003  
 Designed By: DNL  
 Drawn By: WDV  
 Checked By: JPT

**C-2008**

Copyright: Tetra Tech  
 Bar Measures 1 inch