

TETRA TECH

www.tetra.tech.com

101 QUALITY CIRCLE, SUITE 140
HUNTSVILLE, ALABAMA 35806
PHONE: (256) 424-4077 FAX: (256) 424-4097

BID SET

ALABAMA REGISTERED PROFESSIONAL ENGINEER
CHRISTIAN R. DALRYMPLE
101247R

BY	DATE	DESCRIPTION


HUNTSVILLE UTILITIES
SOUTHEAST WATER TREATMENT PLANT

**FINISHED WATER MAIN
PLAN AND PROFILE**
STA 995+00 TO 1002+50

Project No.: 200-11740-10003
Designed By: DNL
Drawn By: WDV
Checked By: JPT

C-2039

Copyright: Tetra Tech
Bar Measures 1 inch

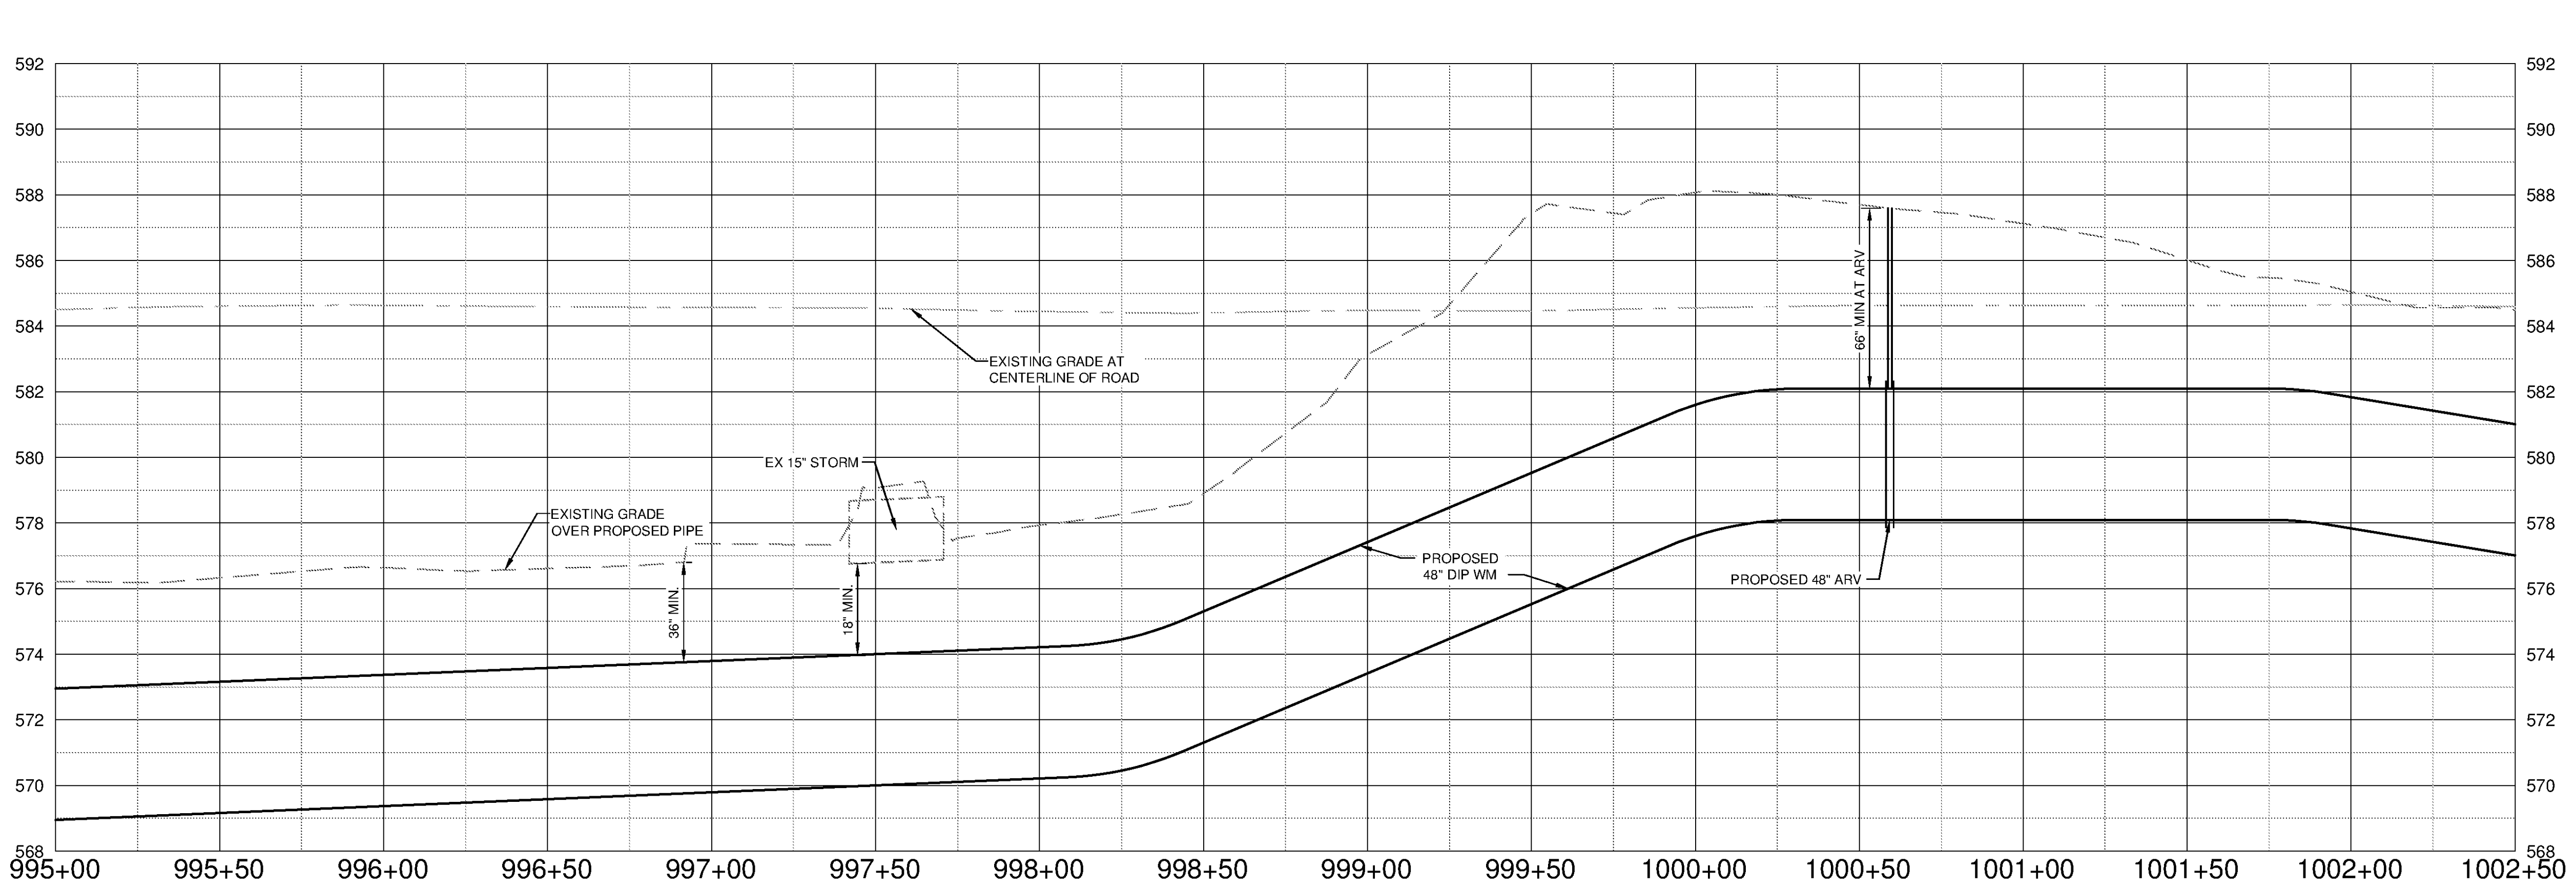

10/9/2014 5:44:24 PM - P:\IER\11740\200-11740-10003\CAD\SHEETFILES\TREATMENT PLANT\FWC-2037 TO C-2040.DWG - DAVALOS, PAULA