
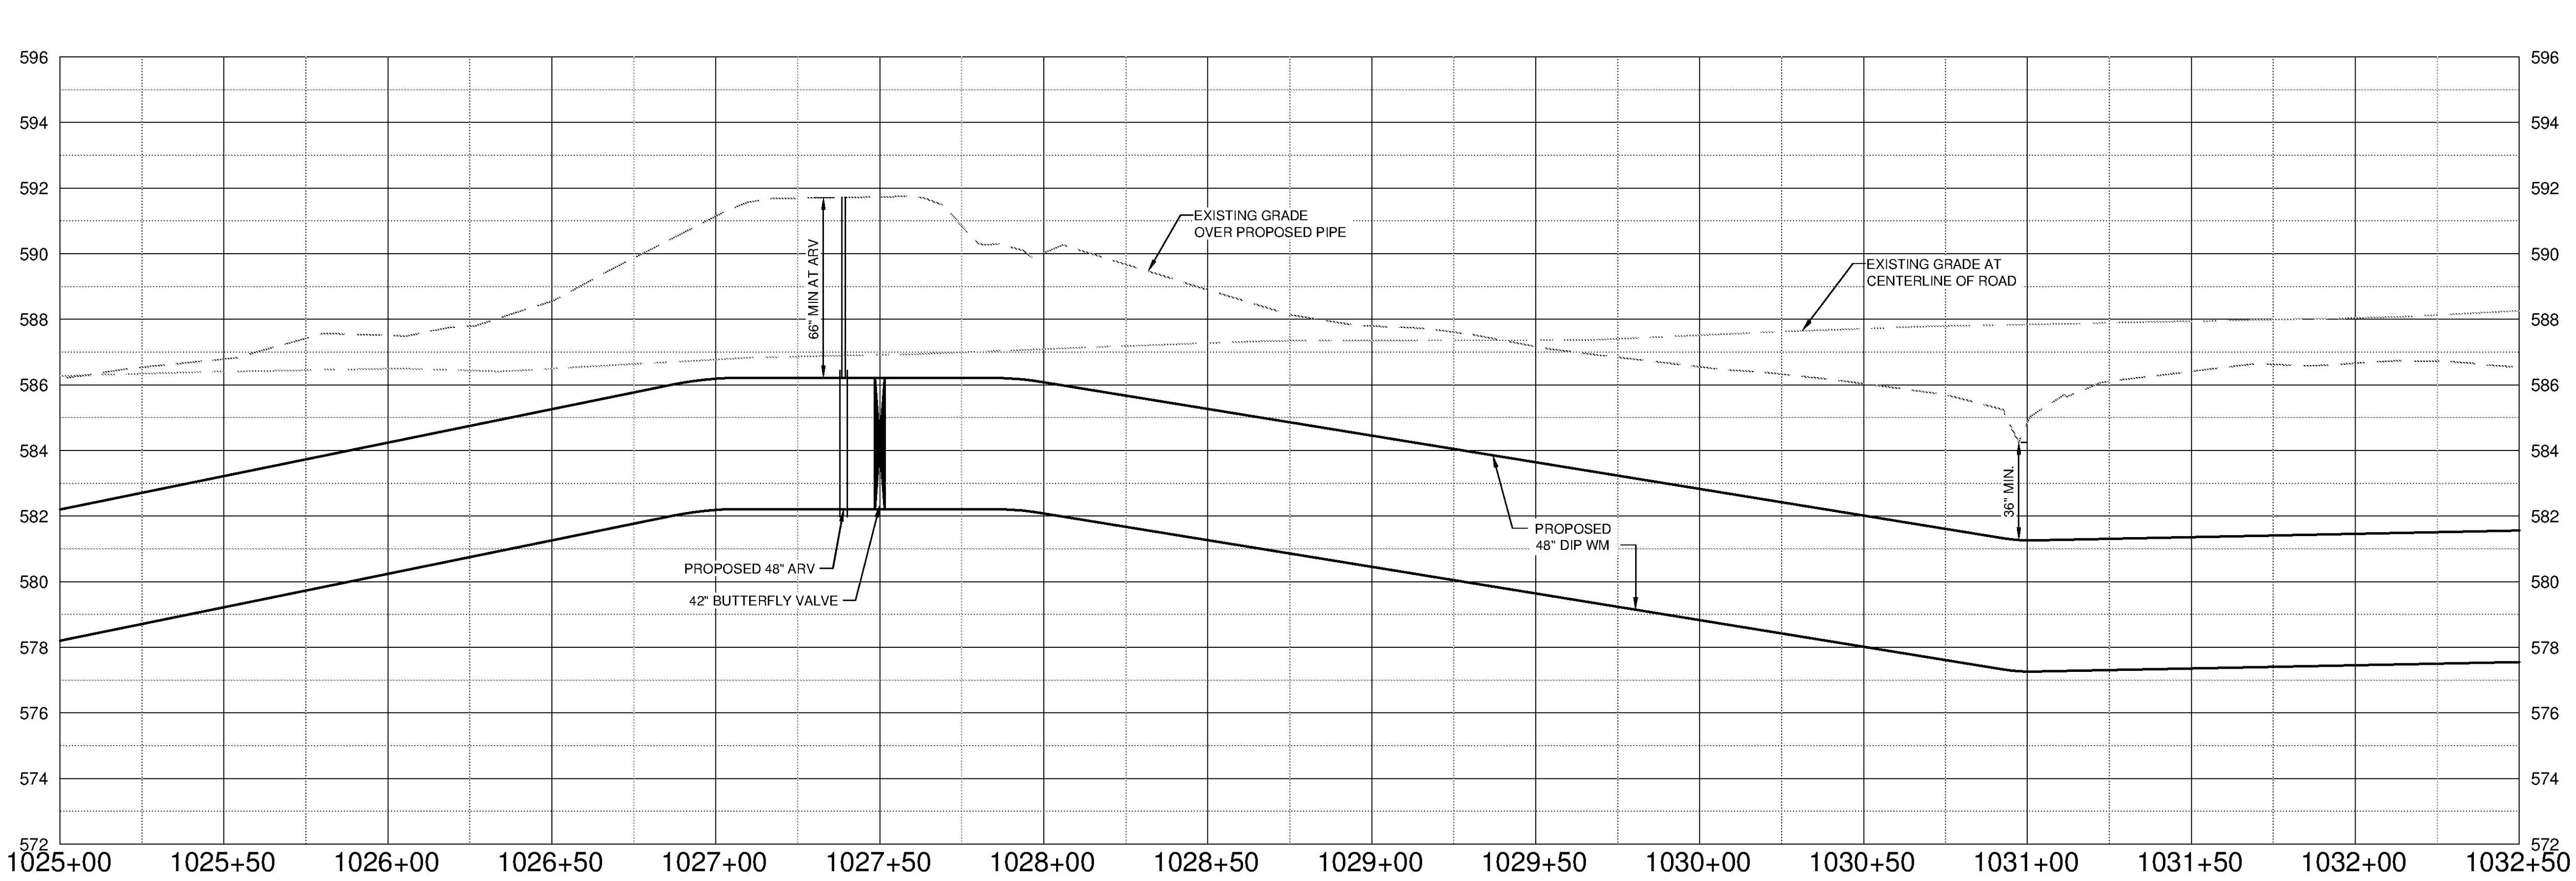
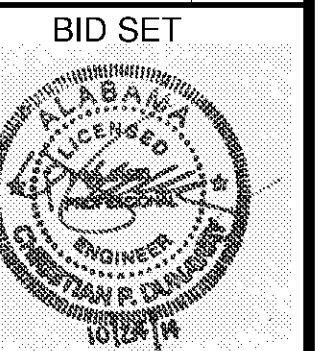
 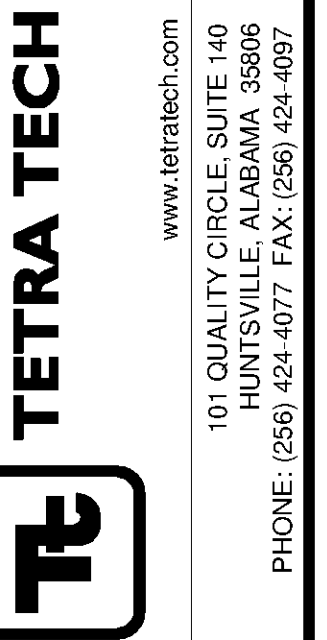



10/9/2014 5:52:35 PM - P:\IER\11740\200-11740-10003\CAD\SHEETFILES\TREATMENT PLANT\FWC-2041 TO C-2044.DWG - DAVALOS, PAULA

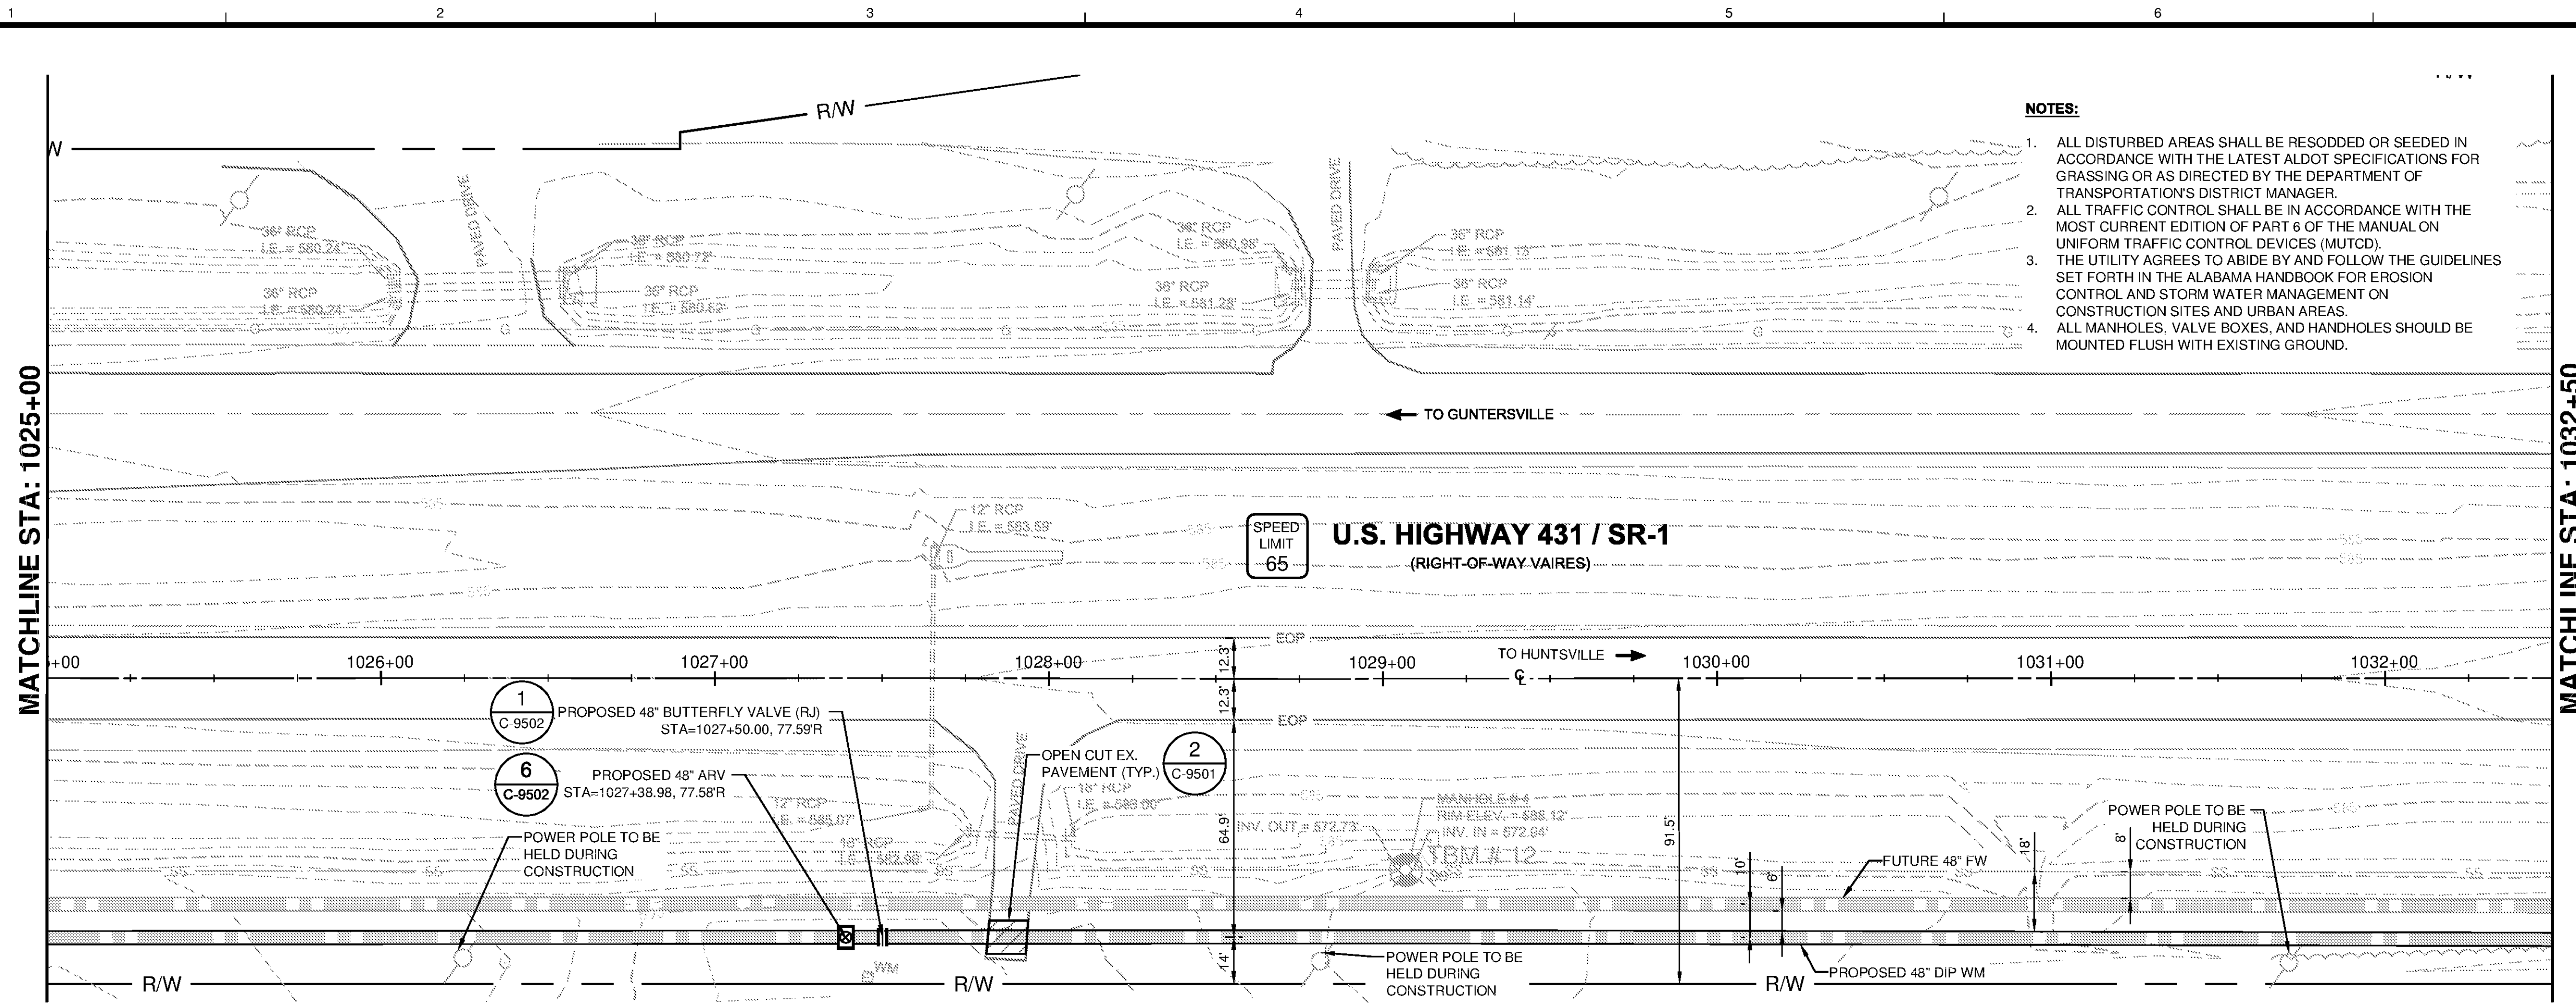

BY	DATE	DESCRIPTION

HUNTSVILLE UTILITIES  
SOUTHEAST WATER TREATMENT PLANT  
**FINISHED WATER MAIN  
PLAN AND PROFILE  
STA 1025+00 TO 1032+50**

Project No.: 200-11740-10003  
Designed By: DNL  
Drawn By: WDW  
Checked By: JPT

**C-2043**

Copyright: Tetra Tech  
Bar Measures 1 inch