


10/1/2014 3:20:04 PM C:\Revit Local\WTP-11740-S-MAN\PEL_Justin.Greenwell.rvt

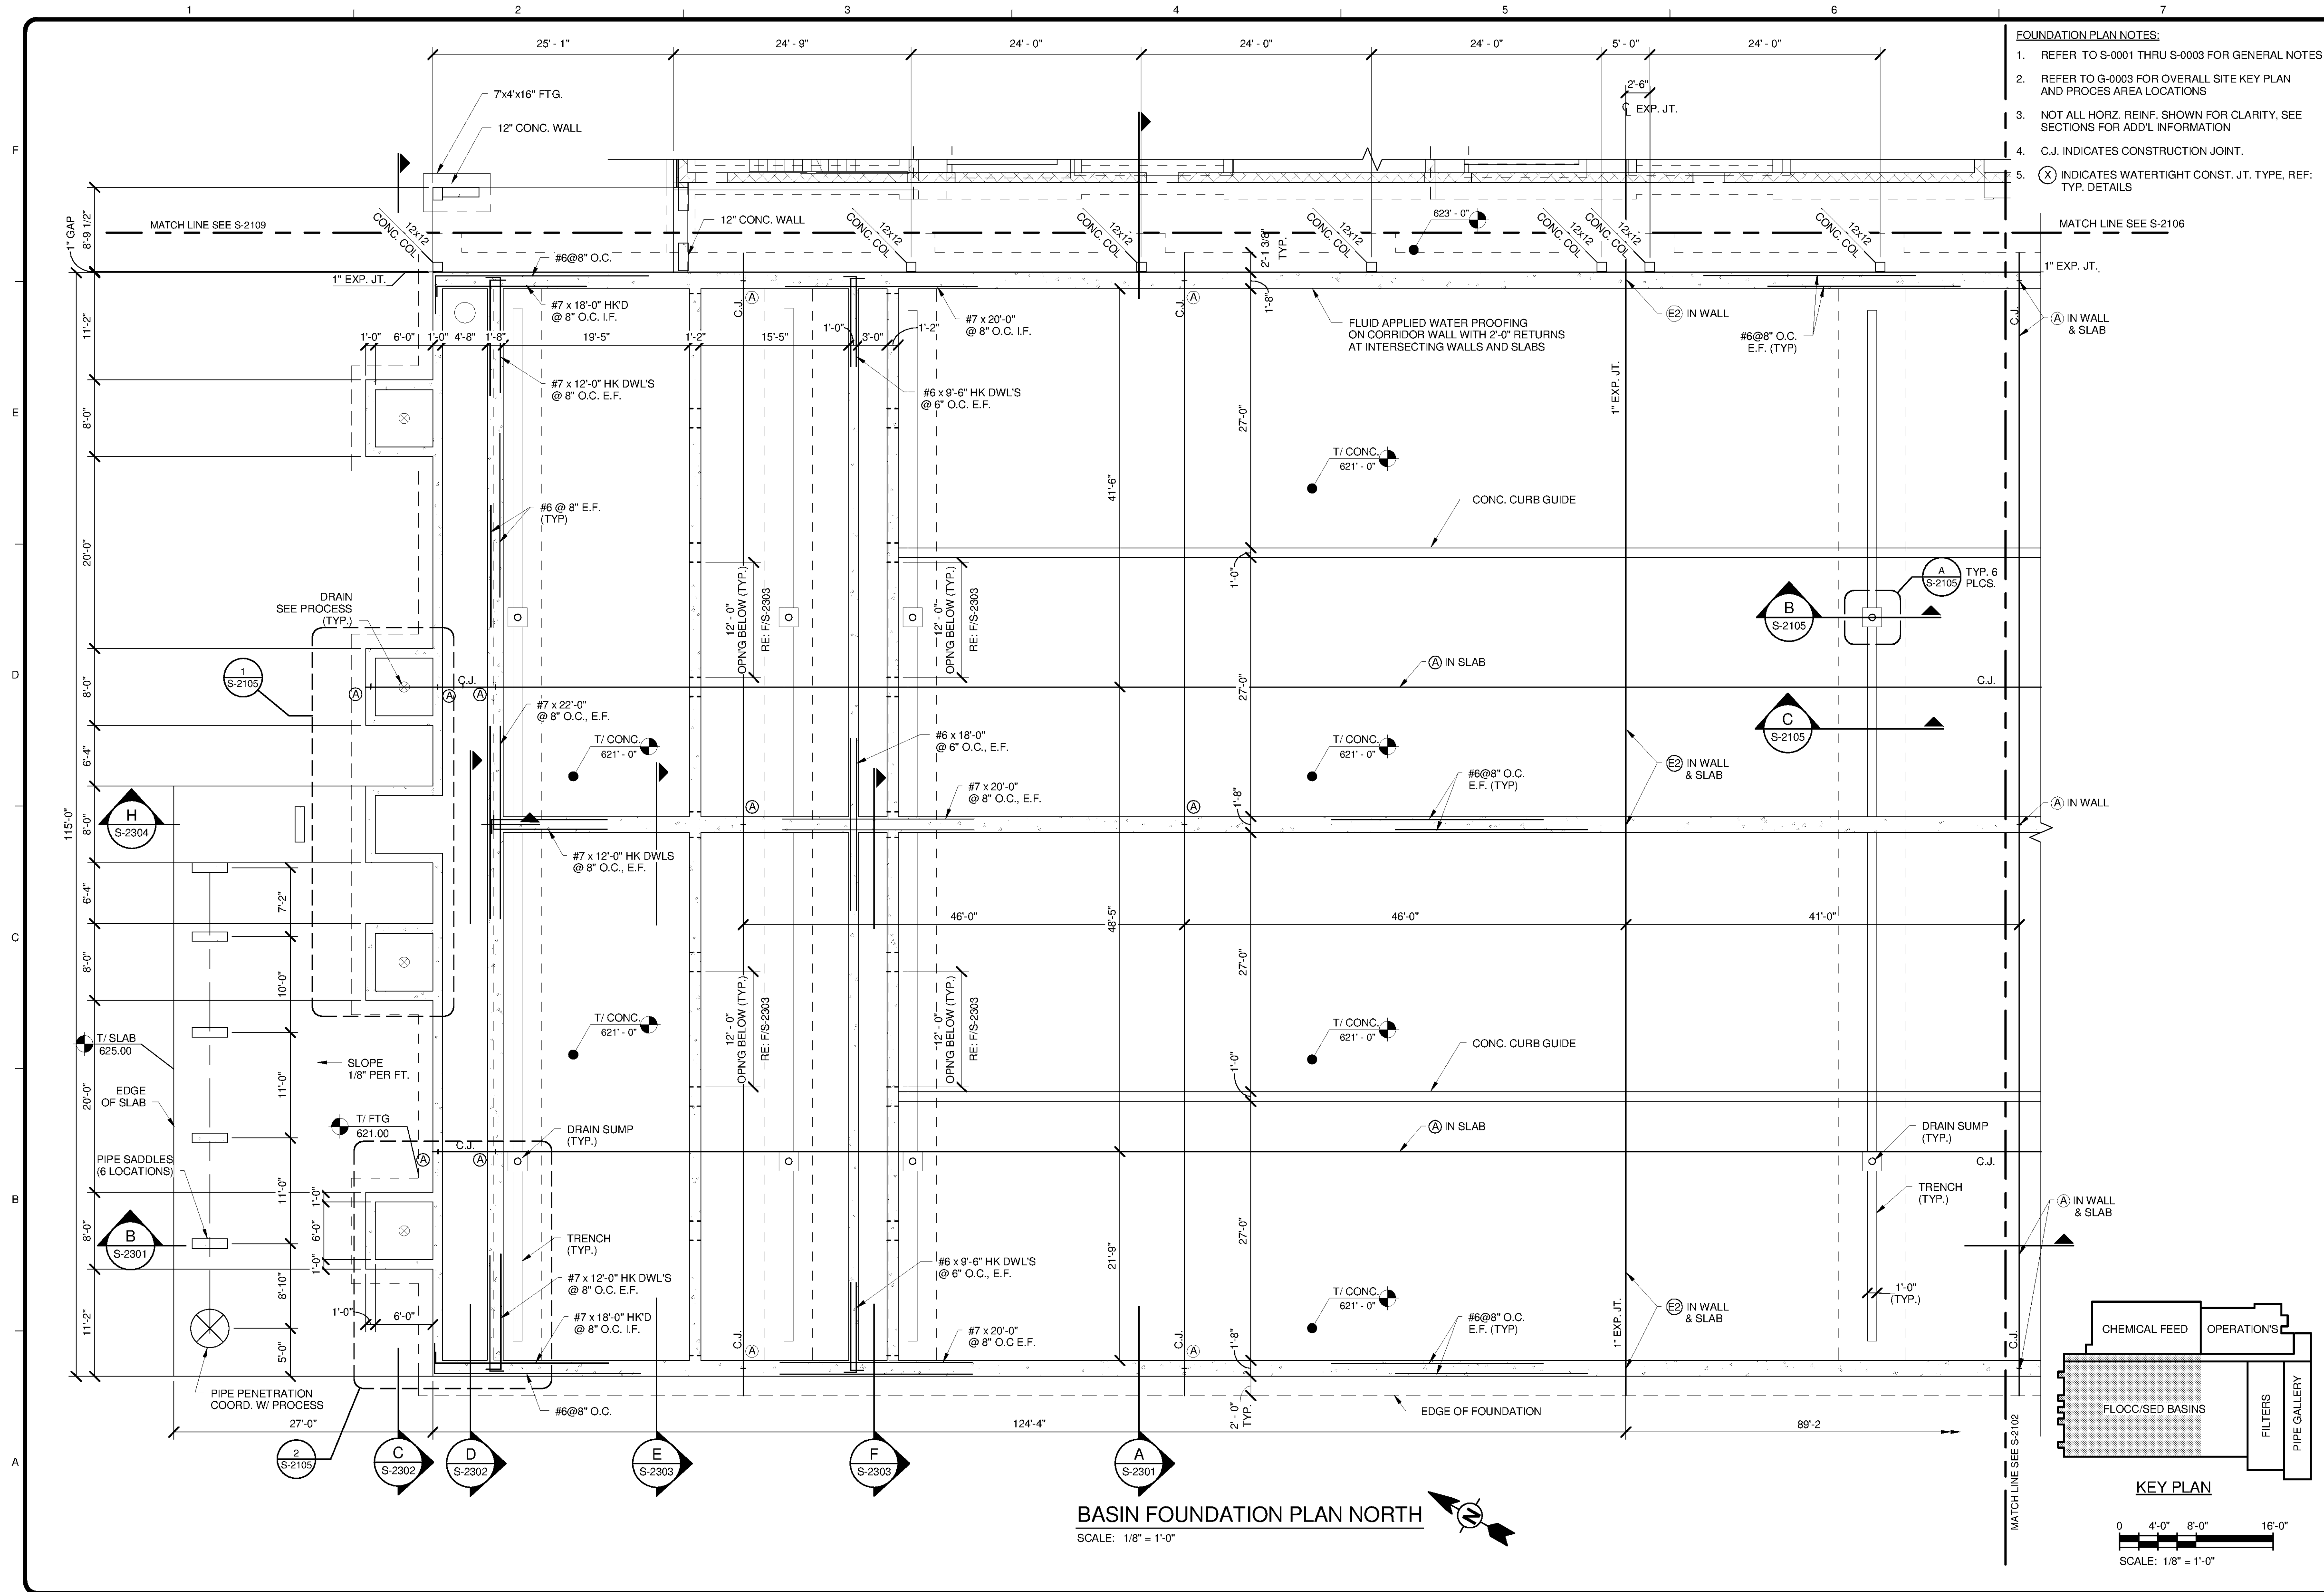

- FOUNDATION PLAN NOTES:**
1. REFER TO S-0001 THRU S-0003 FOR GENERAL NOTES
 2. REFER TO G-0003 FOR OVERALL SITE KEY PLAN AND PROCESS AREA LOCATIONS
 3. NOT ALL HORIZ. REINF. SHOWN FOR CLARITY, SEE SECTIONS FOR ADD'L INFORMATION
 4. C.J. INDICATES CONSTRUCTION JOINT.
 5. (X) INDICATES WATERTIGHT CONST. JT. TYPE, REF: TYP. DETAILS

TETRA TECH
www.tetrattech.com
101 QUALITY CIRCLE, SUITE 140
HUNTSVILLE, ALABAMA 35896
PHONE: (256) 424-4077 FAX: (256) 424-4087

BID SET
ALABAMA PROFESSIONAL ENGINEER
No. 25103-E
10/24/14

MARK	DATE	DESCRIPTION	BY


MARK	DATE	DESCRIPTION	BY

HUNTSVILLE UTILITIES
SOUTHEAST WATER TREATMENT PLANT
FLOCCULATION & SEDIMENTATION BASIN
FOUNDATION PLAN NORTH

Project No.: 200-11740-10003
Designed By: JLB
Drawn By: BRF
Checked By: CDC

S-2101

BASIN FOUNDATION PLAN NORTH
SCALE: 1/8" = 1'-0"

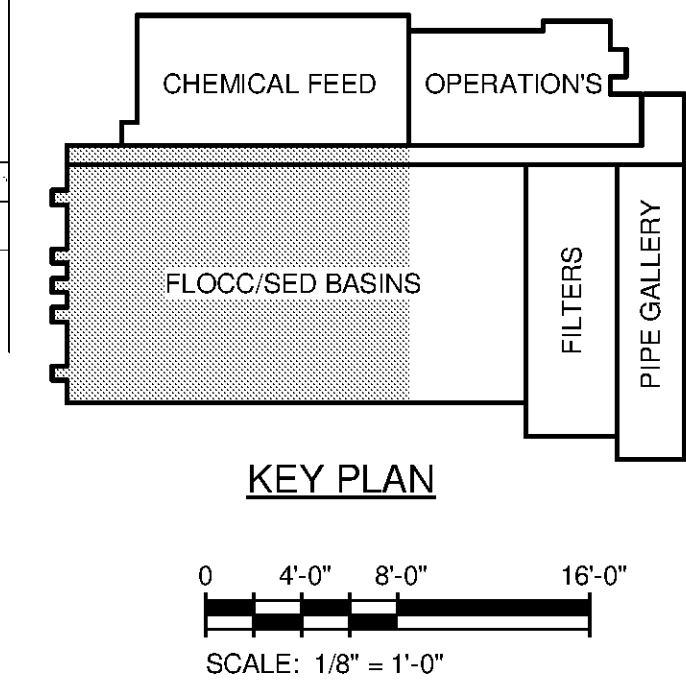

Copyright: Tetra Tech

Bar Measures 1 Inch