


10/1/2014 3:20:08 PM C:\Revit Local\WTP-11740-S-MAIN\PEL_justin.greenwell.rvt

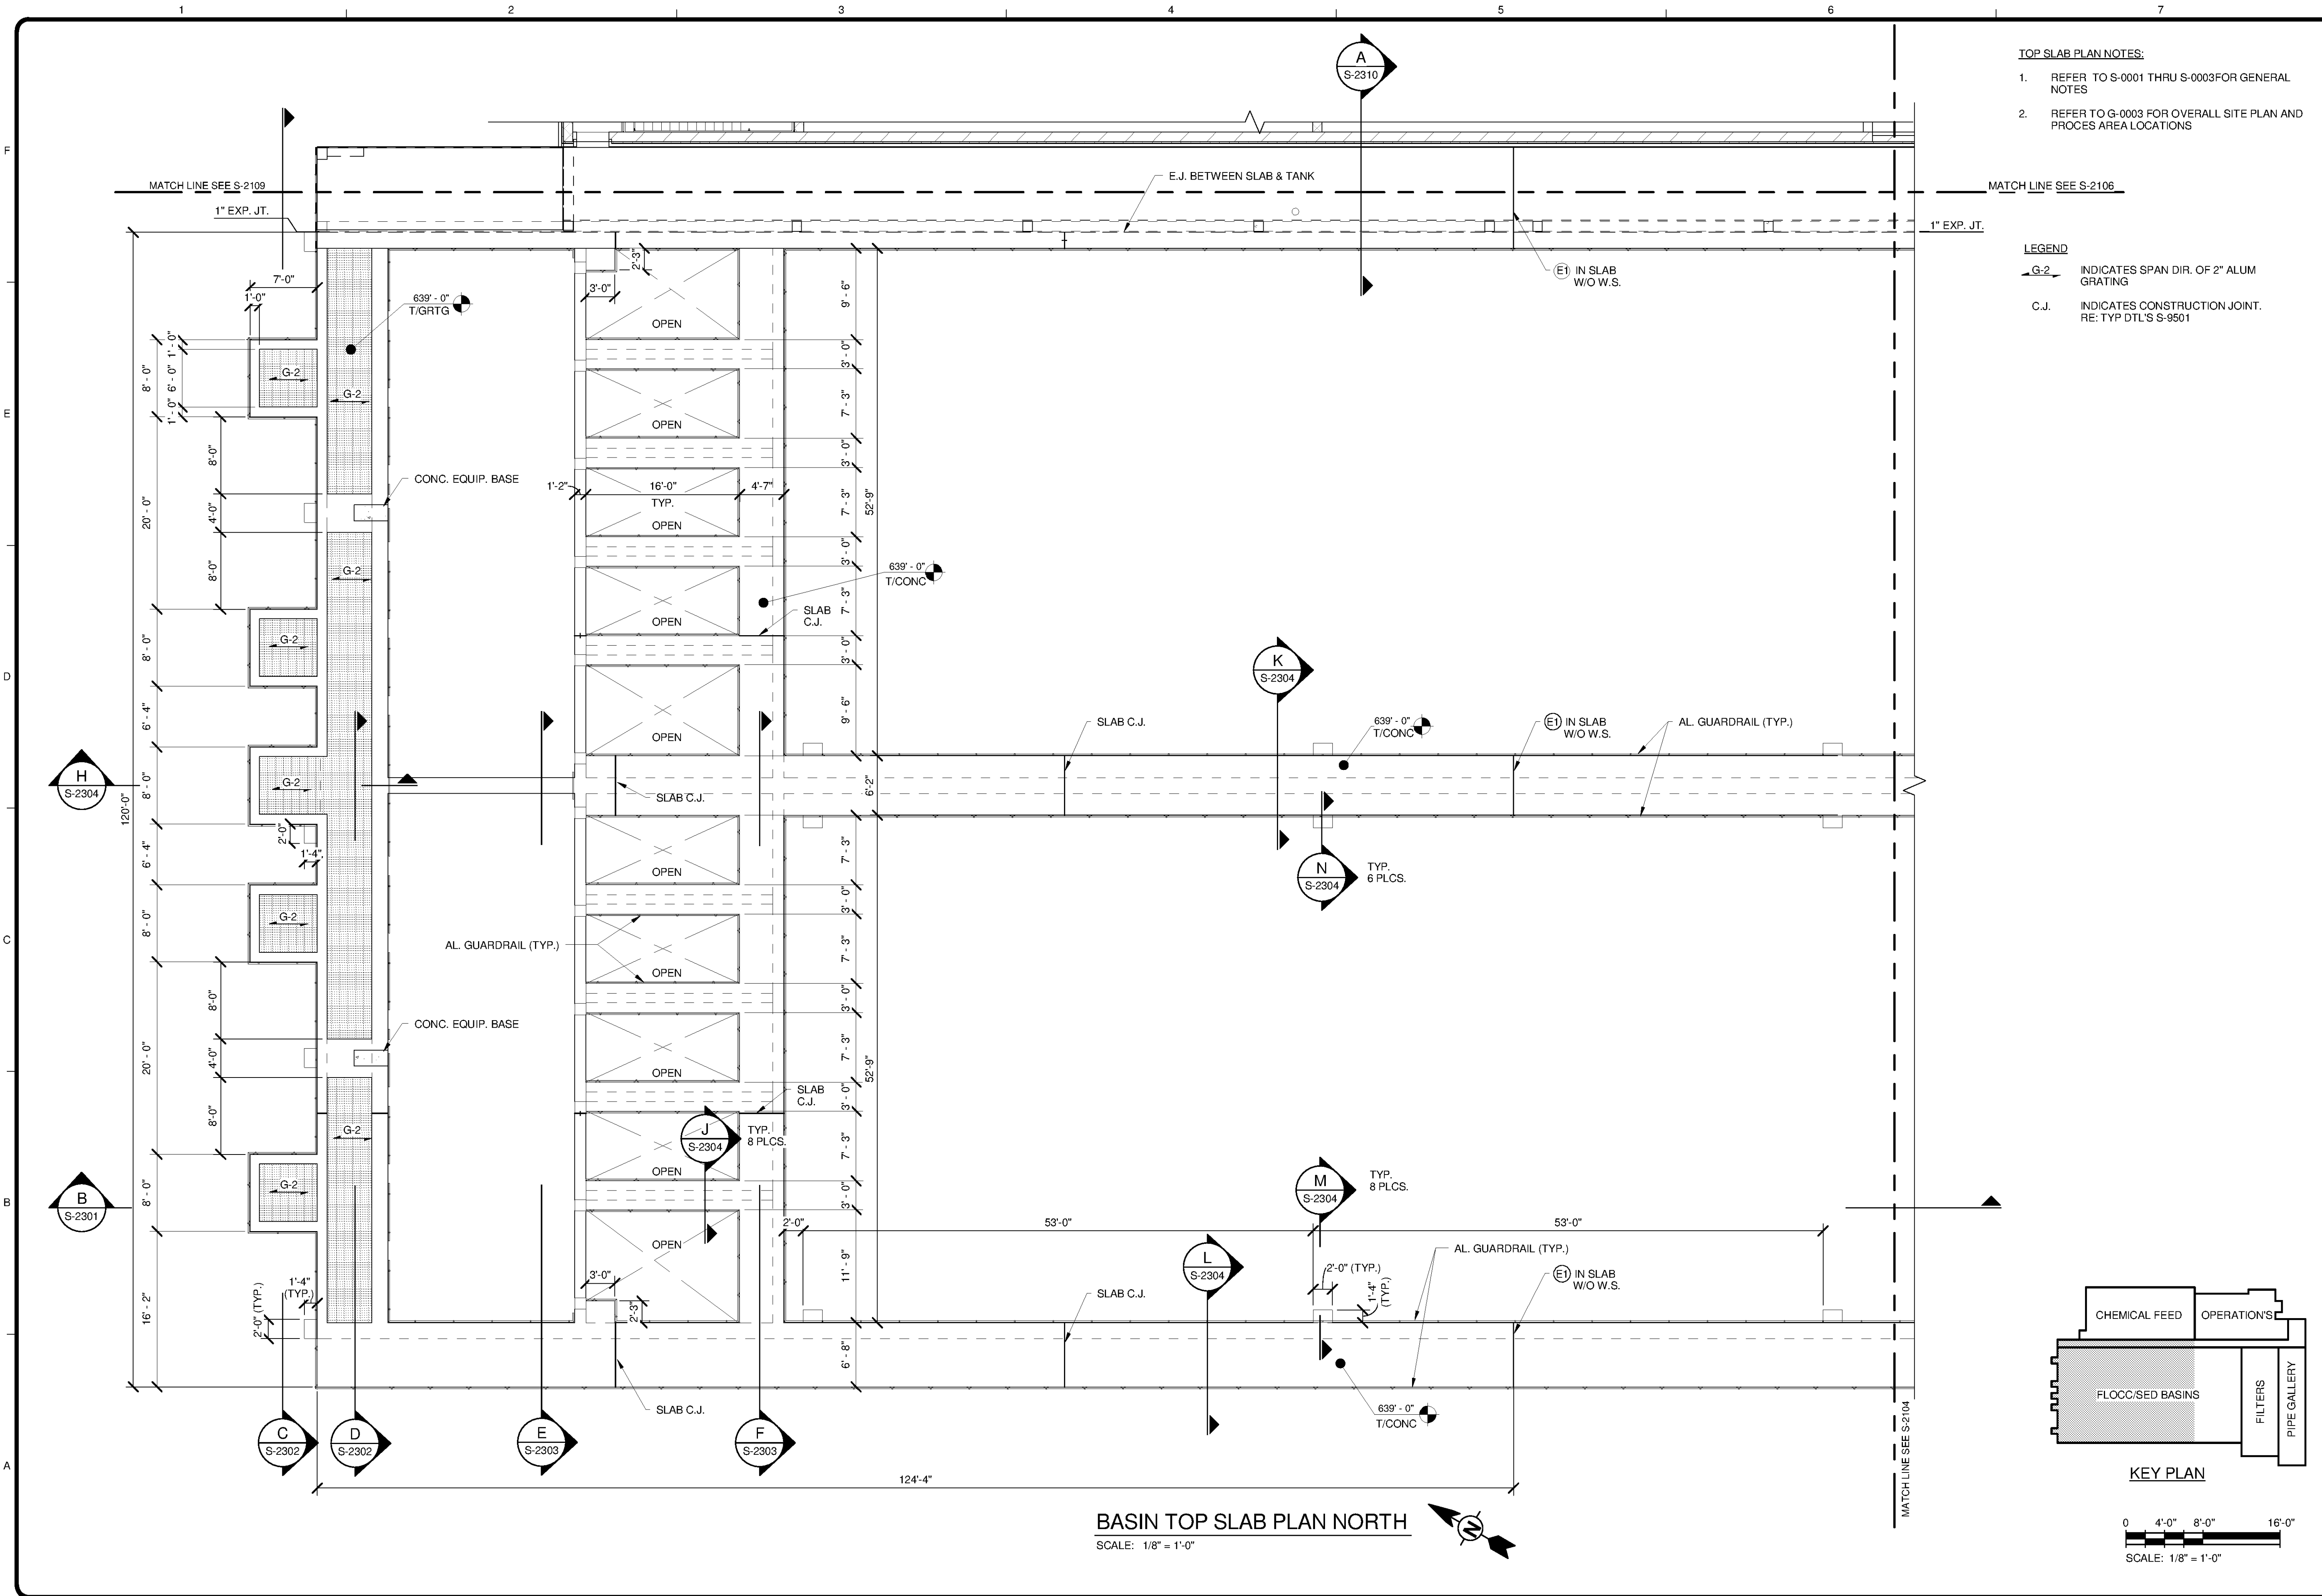

TOP SLAB PLAN NOTES:

- REFER TO S-0001 THRU S-0003 FOR GENERAL NOTES
- REFER TO G-0003 FOR OVERALL SITE PLAN AND PROCESS AREA LOCATIONS

LEGEND

G-2 INDICATES SPAN DIR. OF 2" ALUM GRATING

C.J. INDICATES CONSTRUCTION JOINT. RE: TYP DTL'S S-9501

TETRA TECH

www.tetra-tech.com

101 QUALITY CIRCLE, SUITE 140
HUNTSVILLE, ALABAMA 35896
PHONE: (256) 424-4077 FAX: (256) 424-4087

BID SET

ALABAMA LICENSED PROFESSIONAL ENGINEER

NO. 20102

10/24/14



MARK	DATE	DESCRIPTION	BY

HUNTSVILLE UTILITIES
SOUTHEAST WATER TREATMENT PLANT

**FLOCCULATION & SEDIMENTATION BASIN
TOP SLAB PLAN NORTH**

Project No.: 200-11740-10003
Designed By: JLB
Drawn By: BRF
Checked By: CDC

S-2103

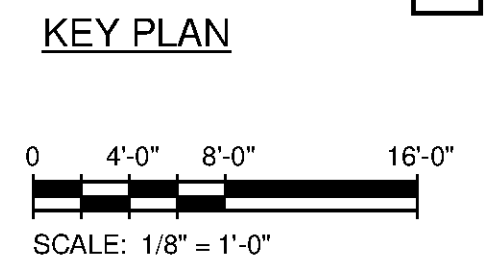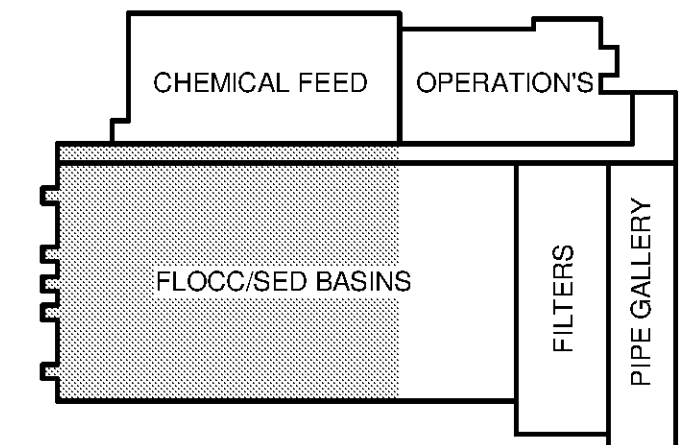

BASIN TOP SLAB PLAN NORTH
SCALE: 1/8" = 1'-0"