




10/1/2014 3:20:47 PM C:\Revit Local\WTP-11740-S-MAIN\PEL\_Justin.Greenwell.rvt

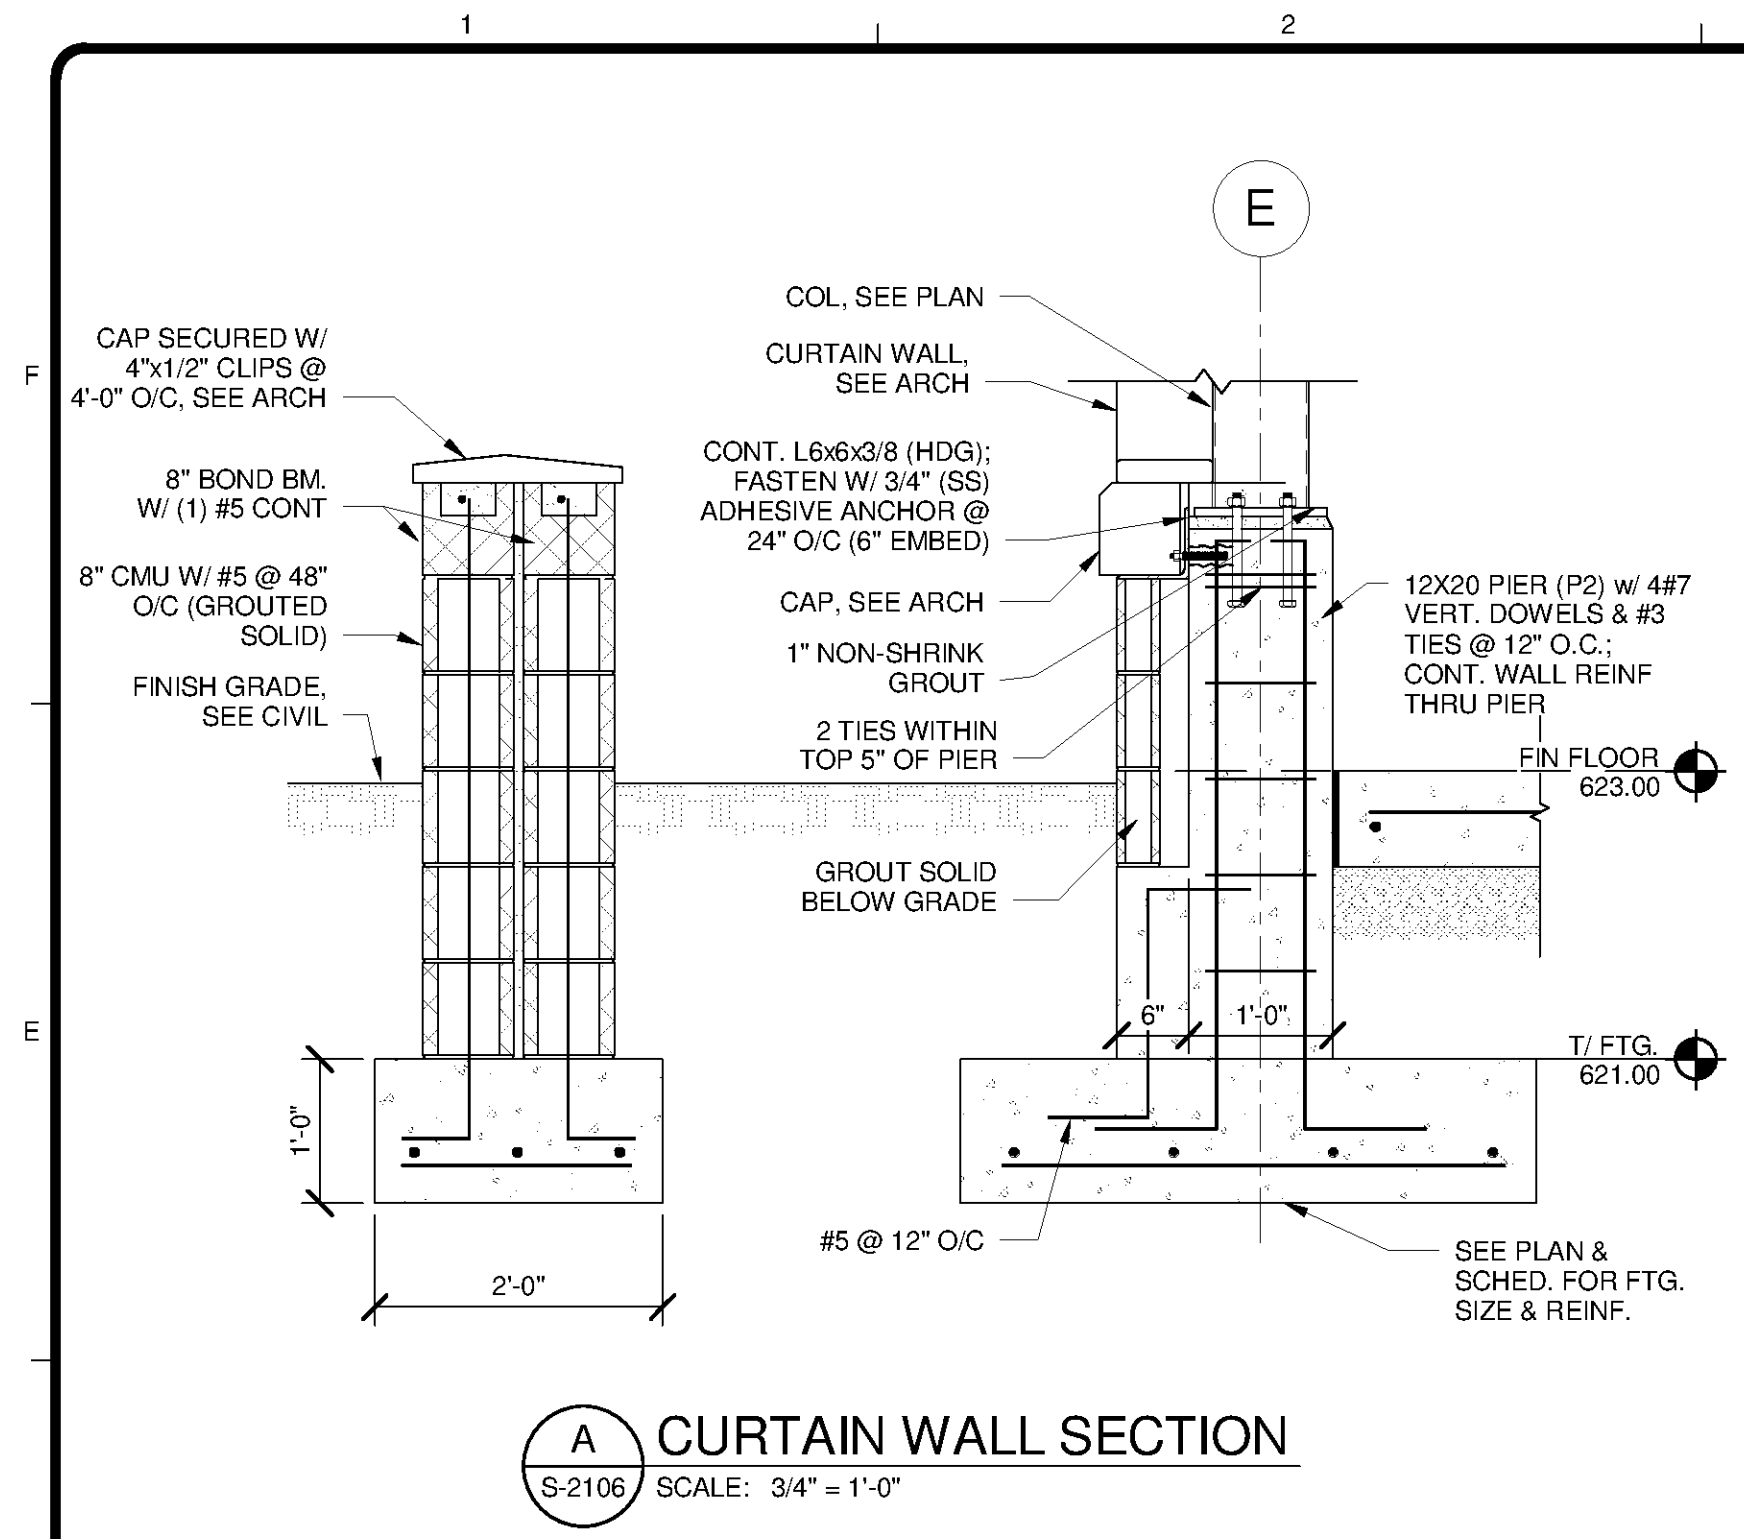


**A CURTAIN WALL SECTION**  
S-2106 SCALE: 3/4" = 1'-0"

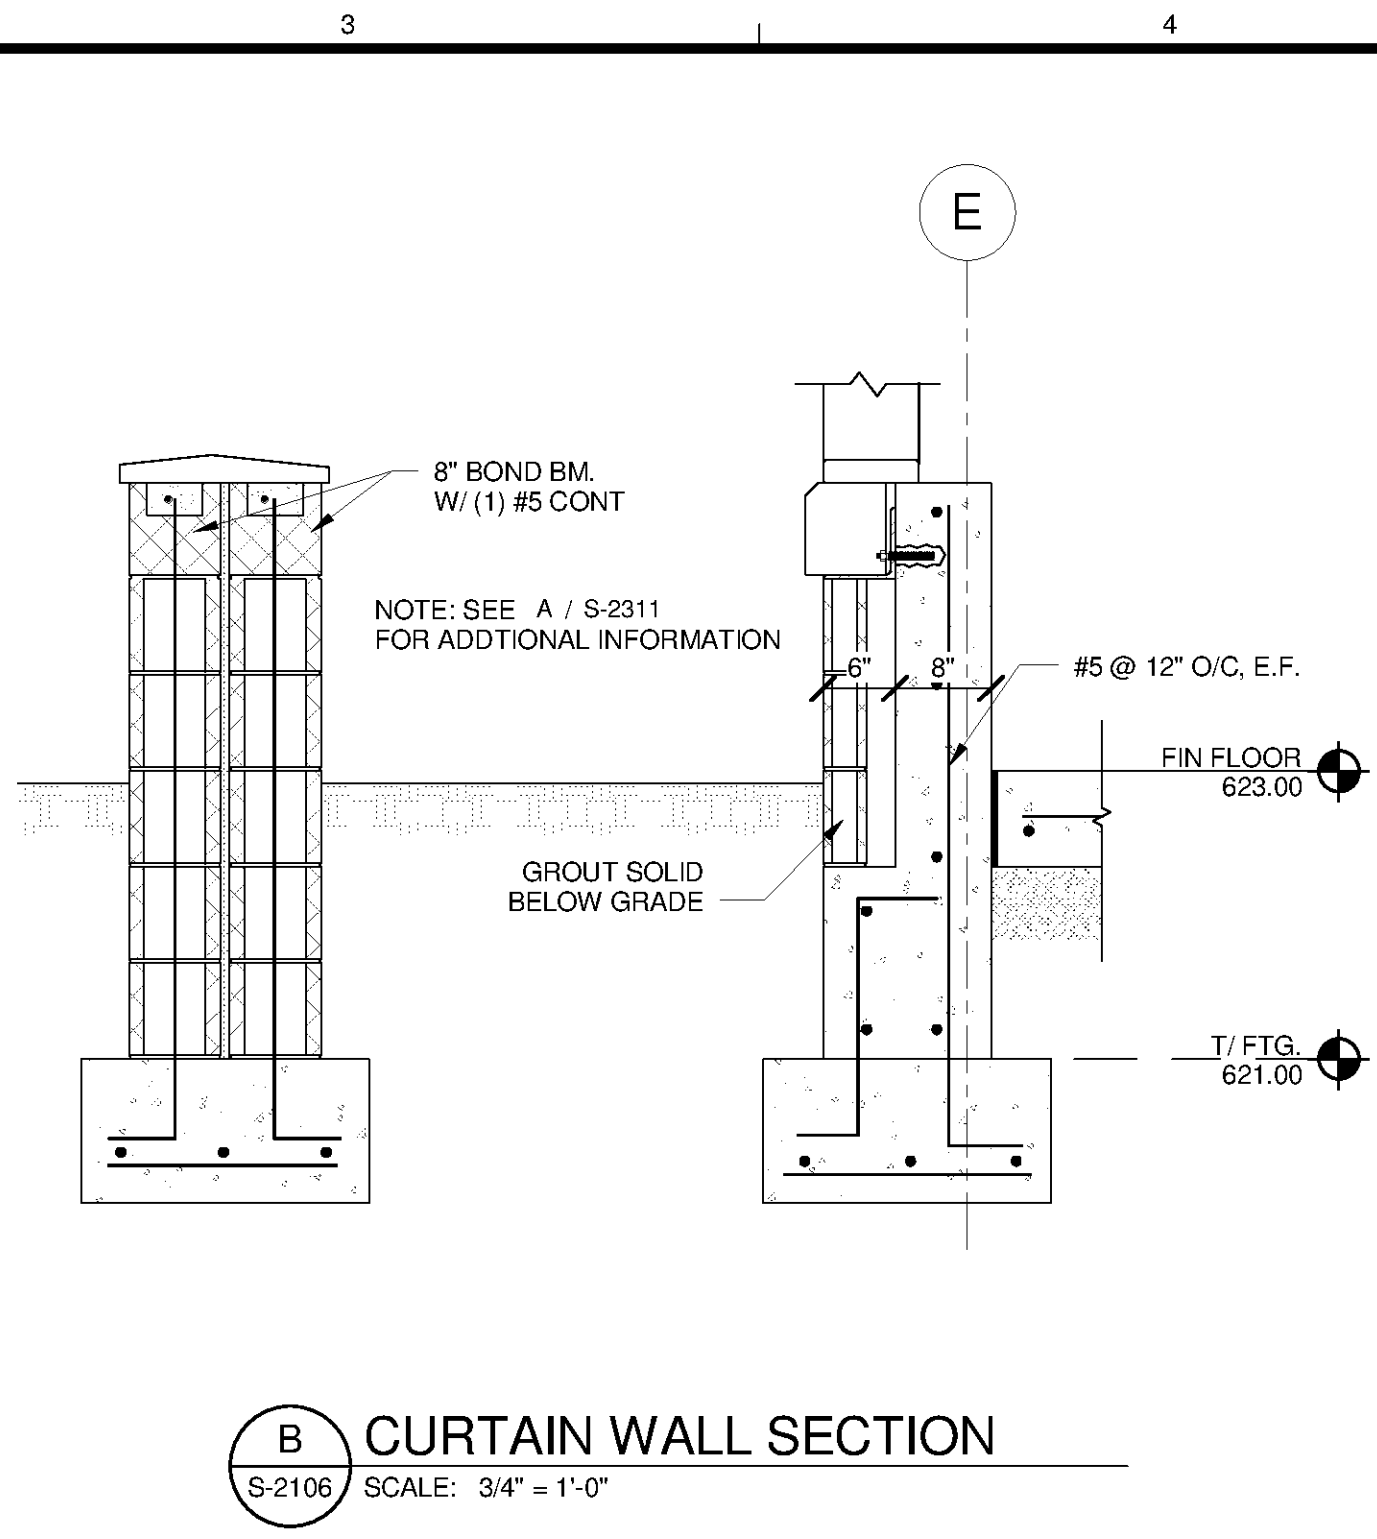


**B CURTAIN WALL SECTION**  
S-2106 SCALE: 3/4" = 1'-0"

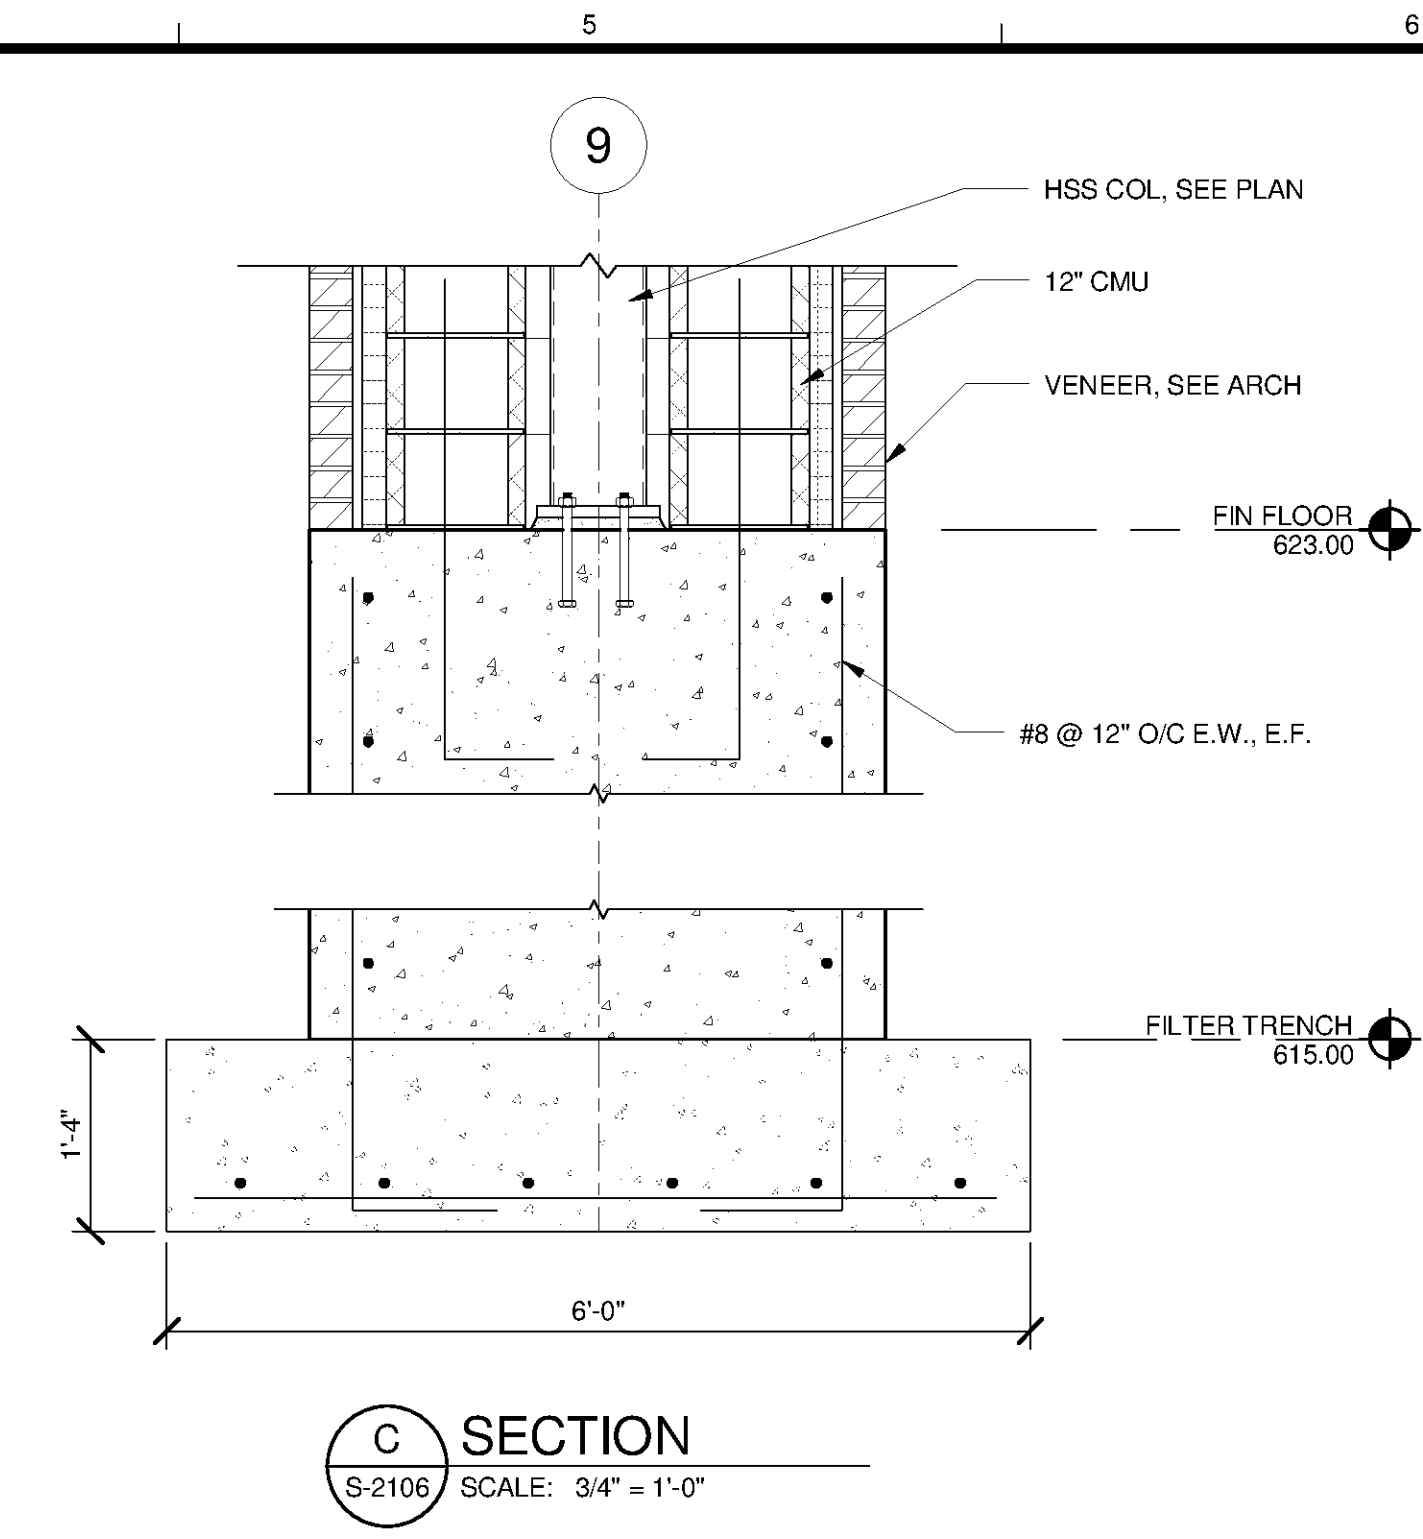


**C SECTION**  
S-2106 SCALE: 3/4" = 1'-0"

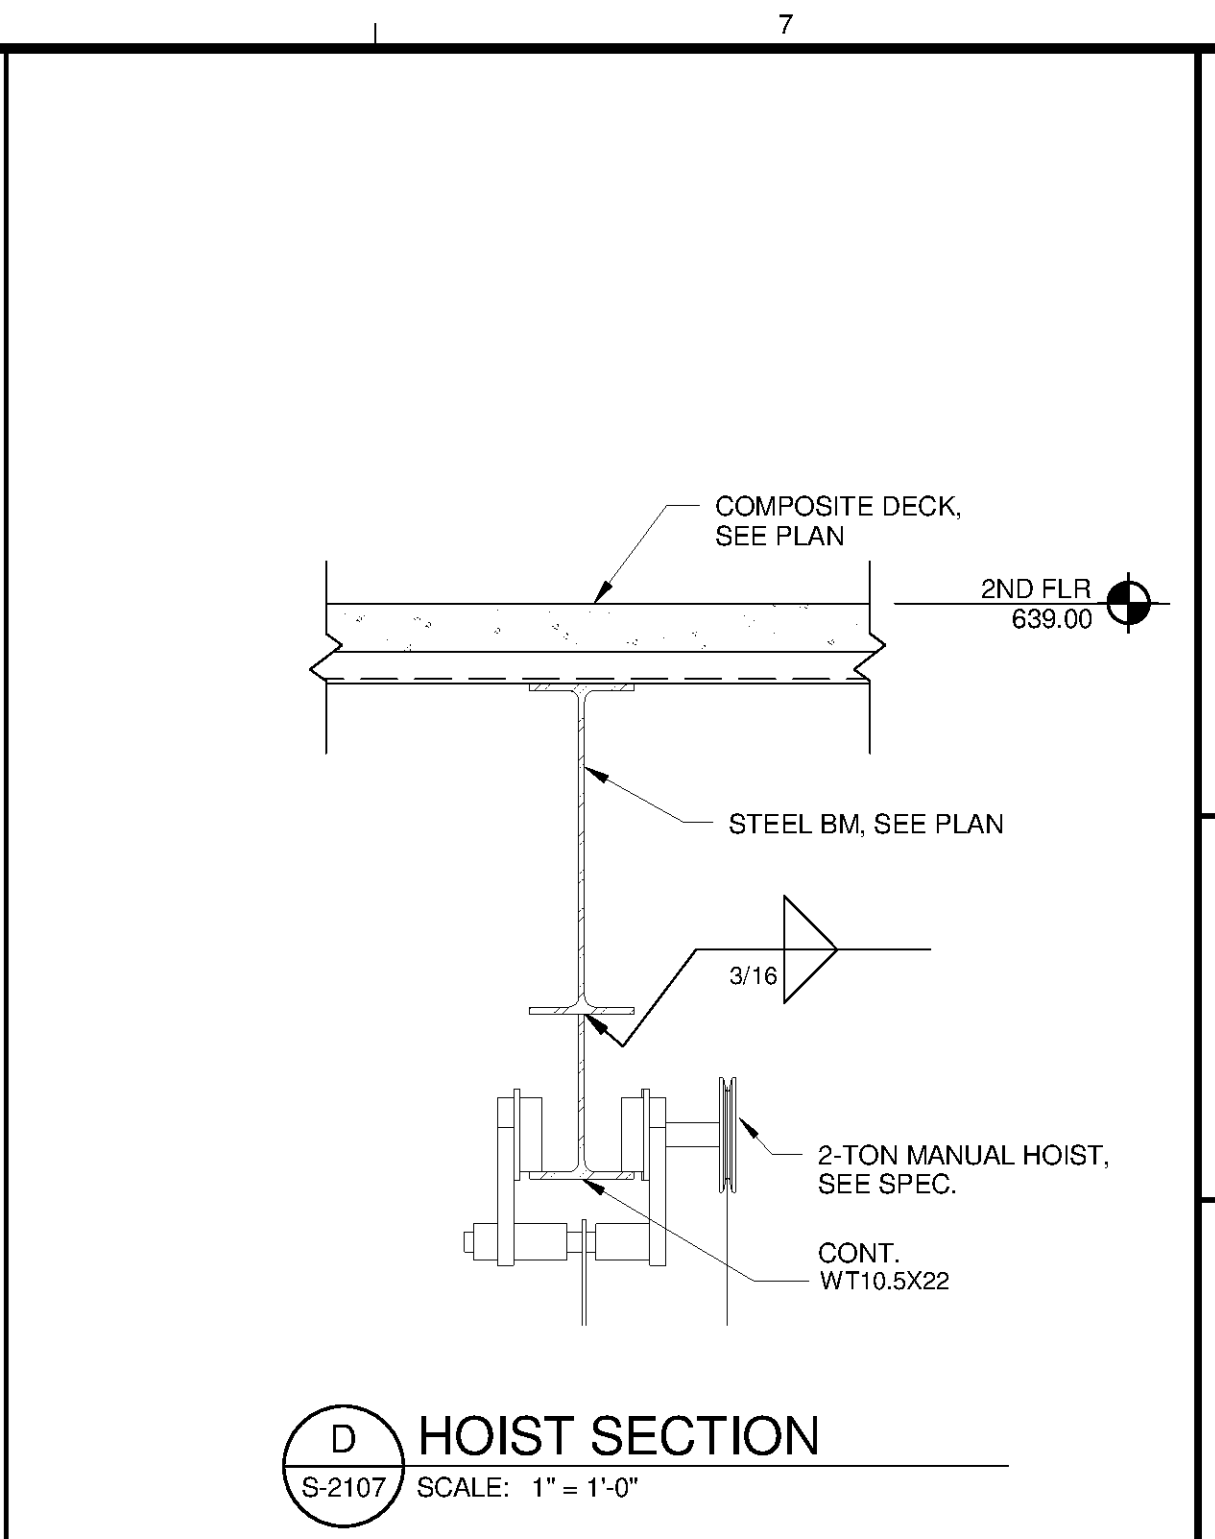


**D HOIST SECTION**  
S-2107 SCALE: 1" = 1'-0"

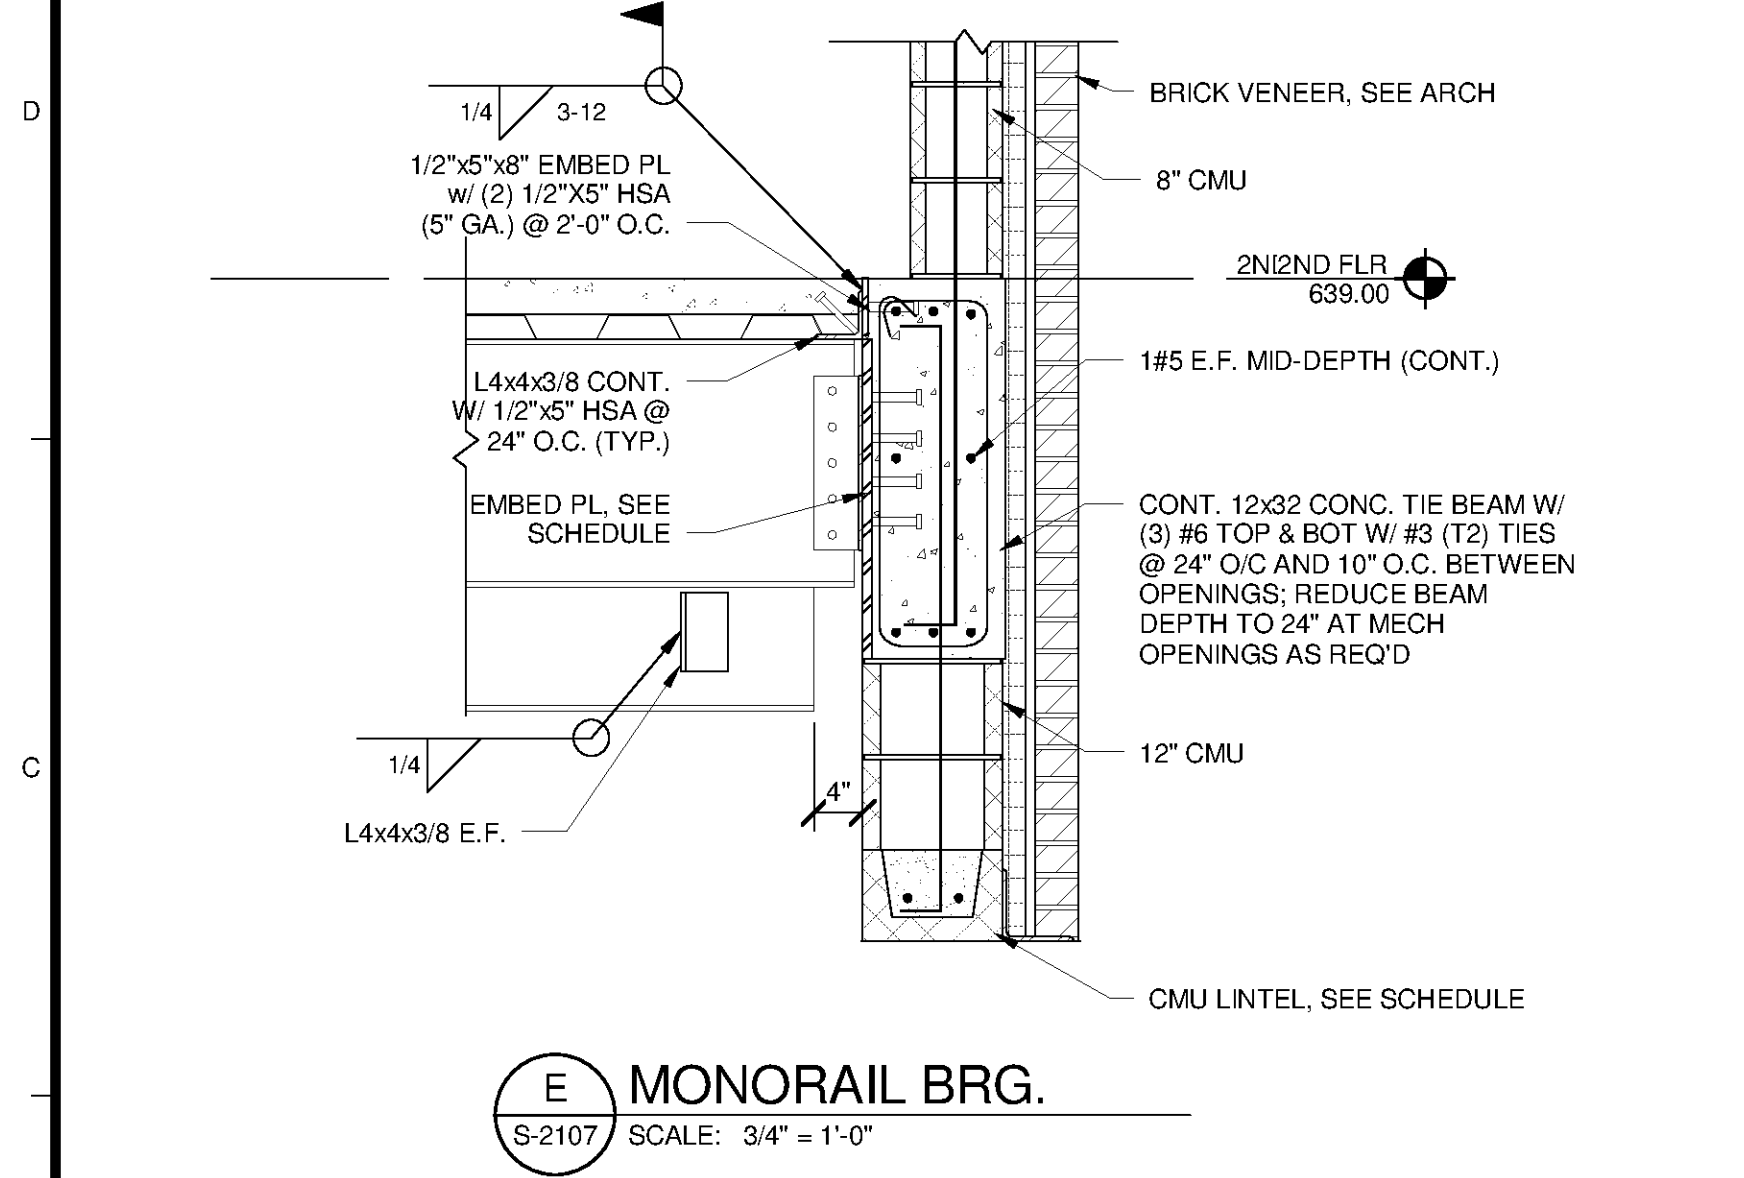


**E MONORAIL BRG.**  
S-2107 SCALE: 3/4" = 1'-0"

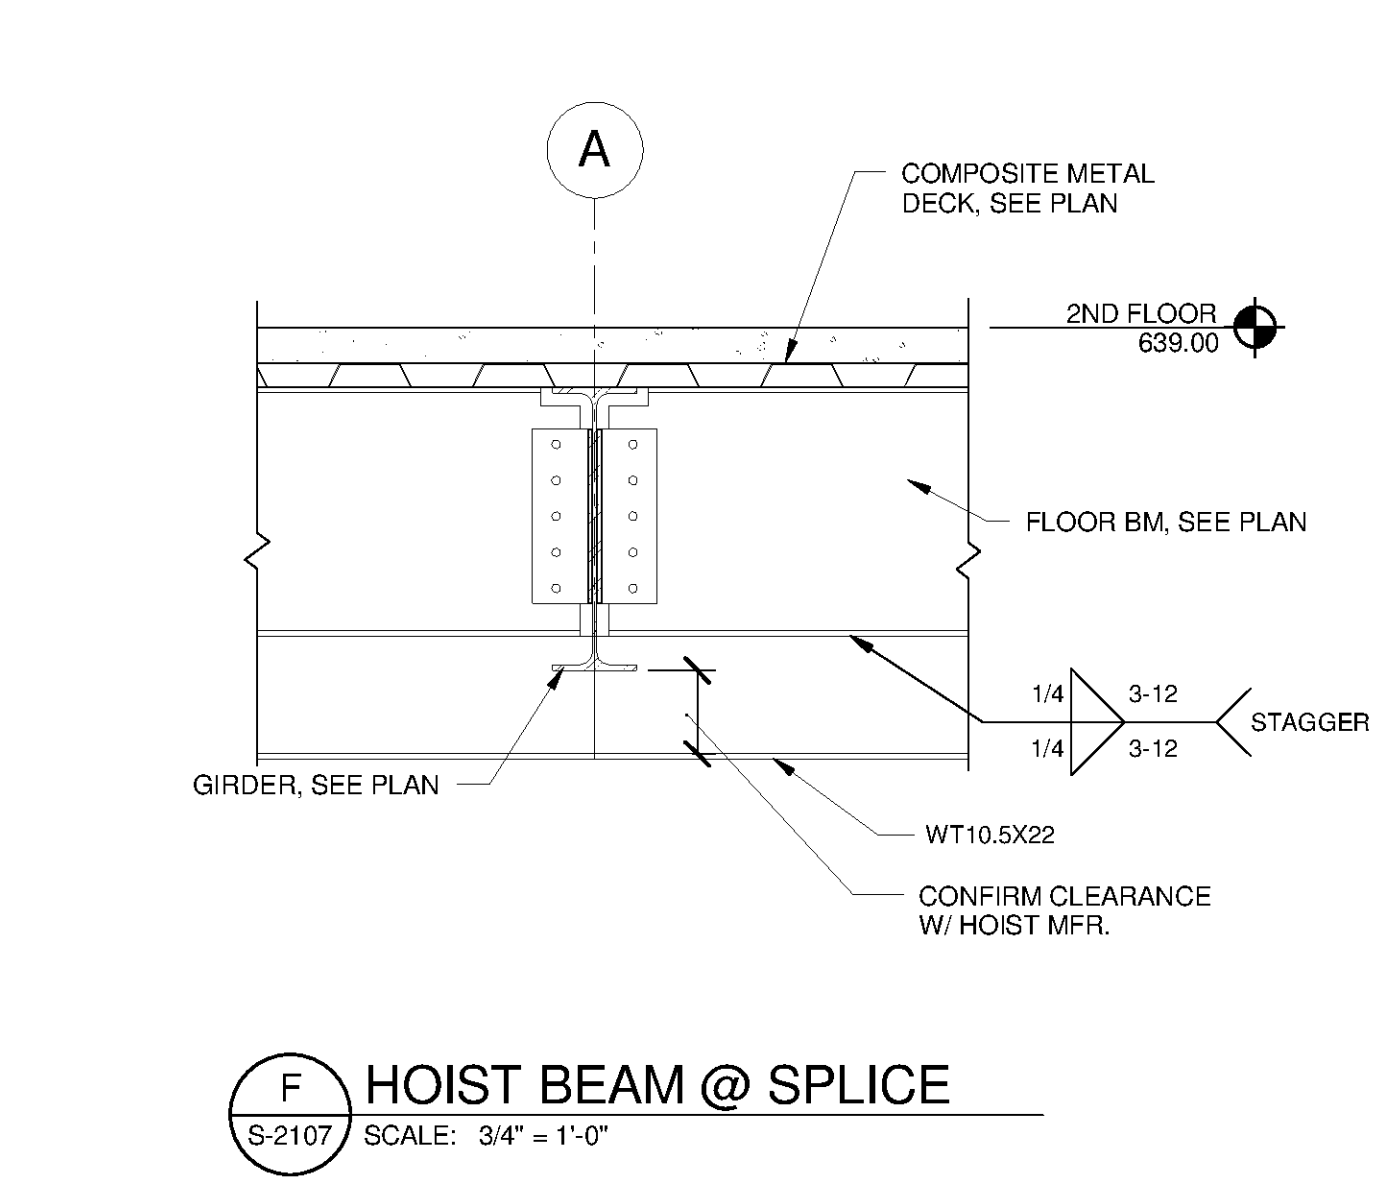


**F HOIST BEAM @ SPLICE**  
S-2107 SCALE: 3/4" = 1'-0"

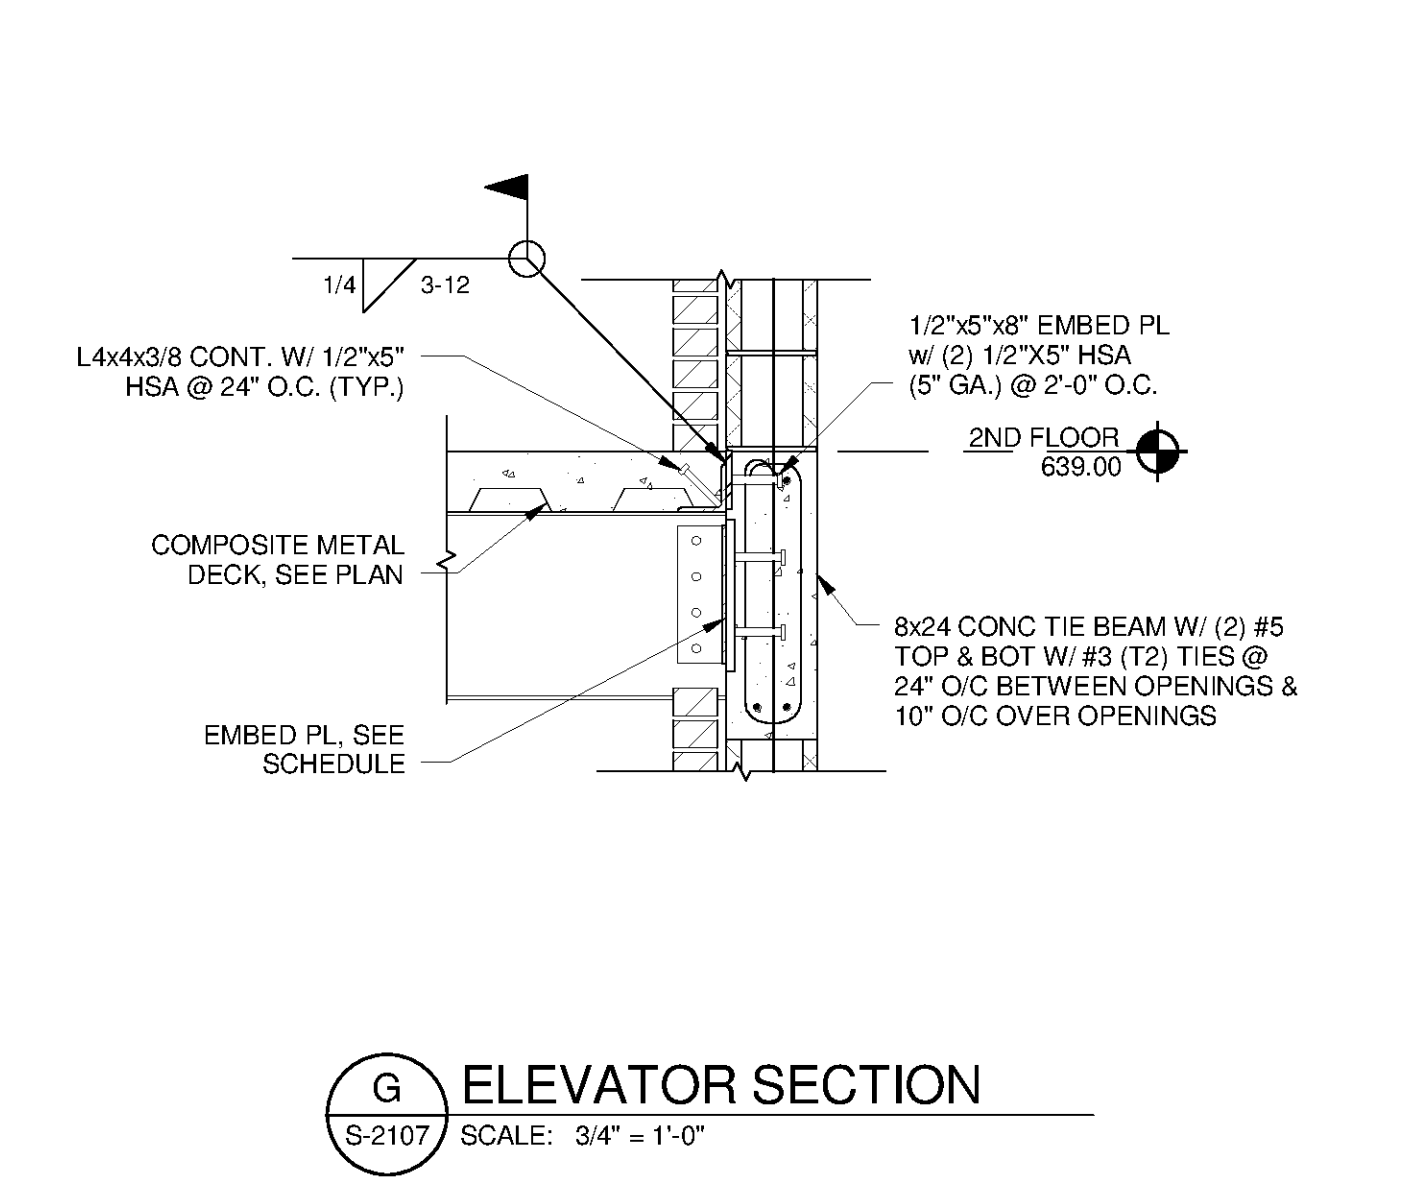


**G ELEVATOR SECTION**  
S-2107 SCALE: 3/4" = 1'-0"

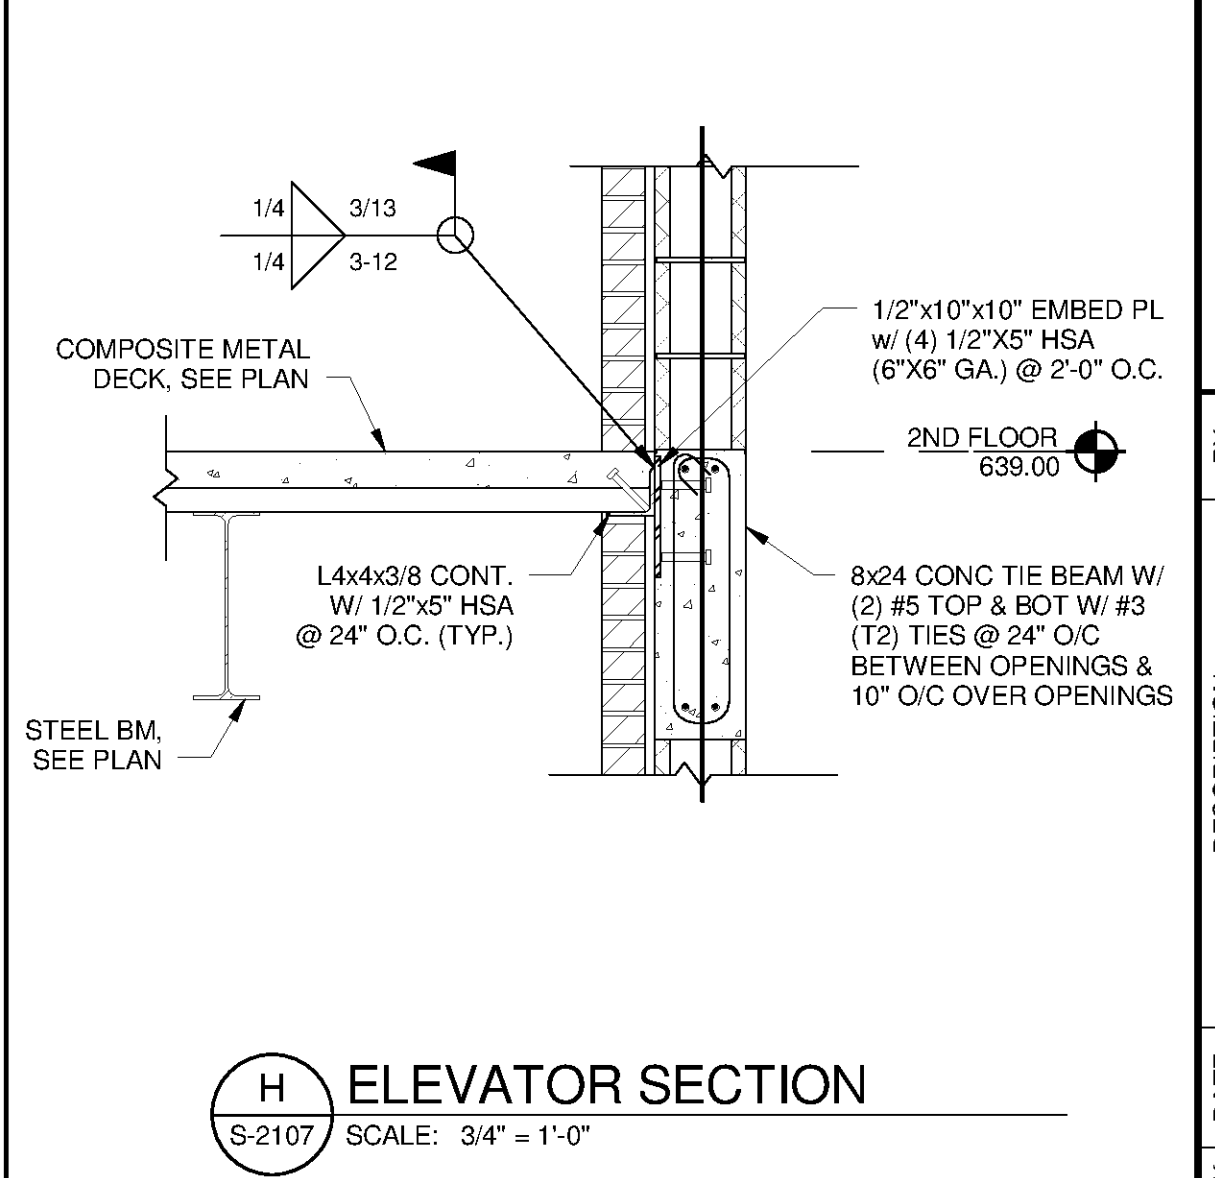


**H ELEVATOR SECTION**  
S-2107 SCALE: 3/4" = 1'-0"

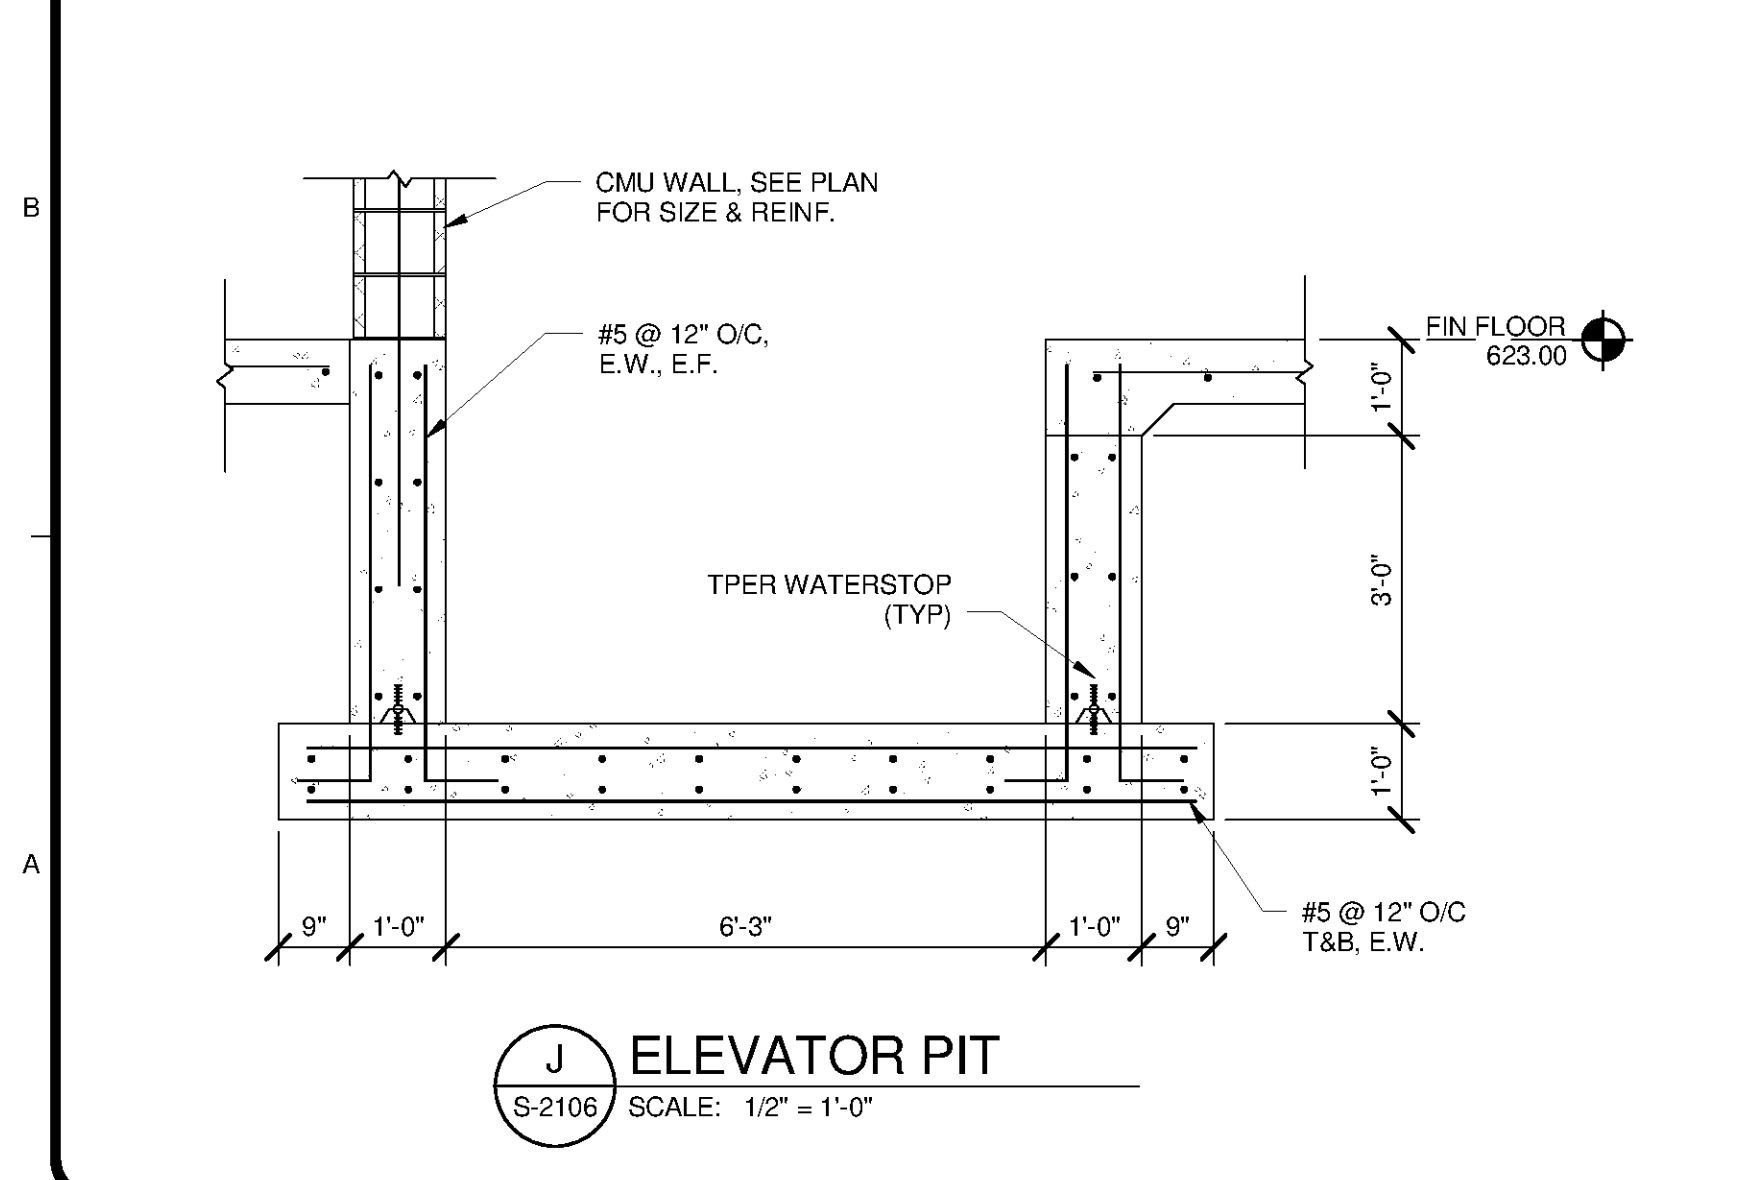


**J ELEVATOR PIT**  
S-2106 SCALE: 1/2" = 1'-0"

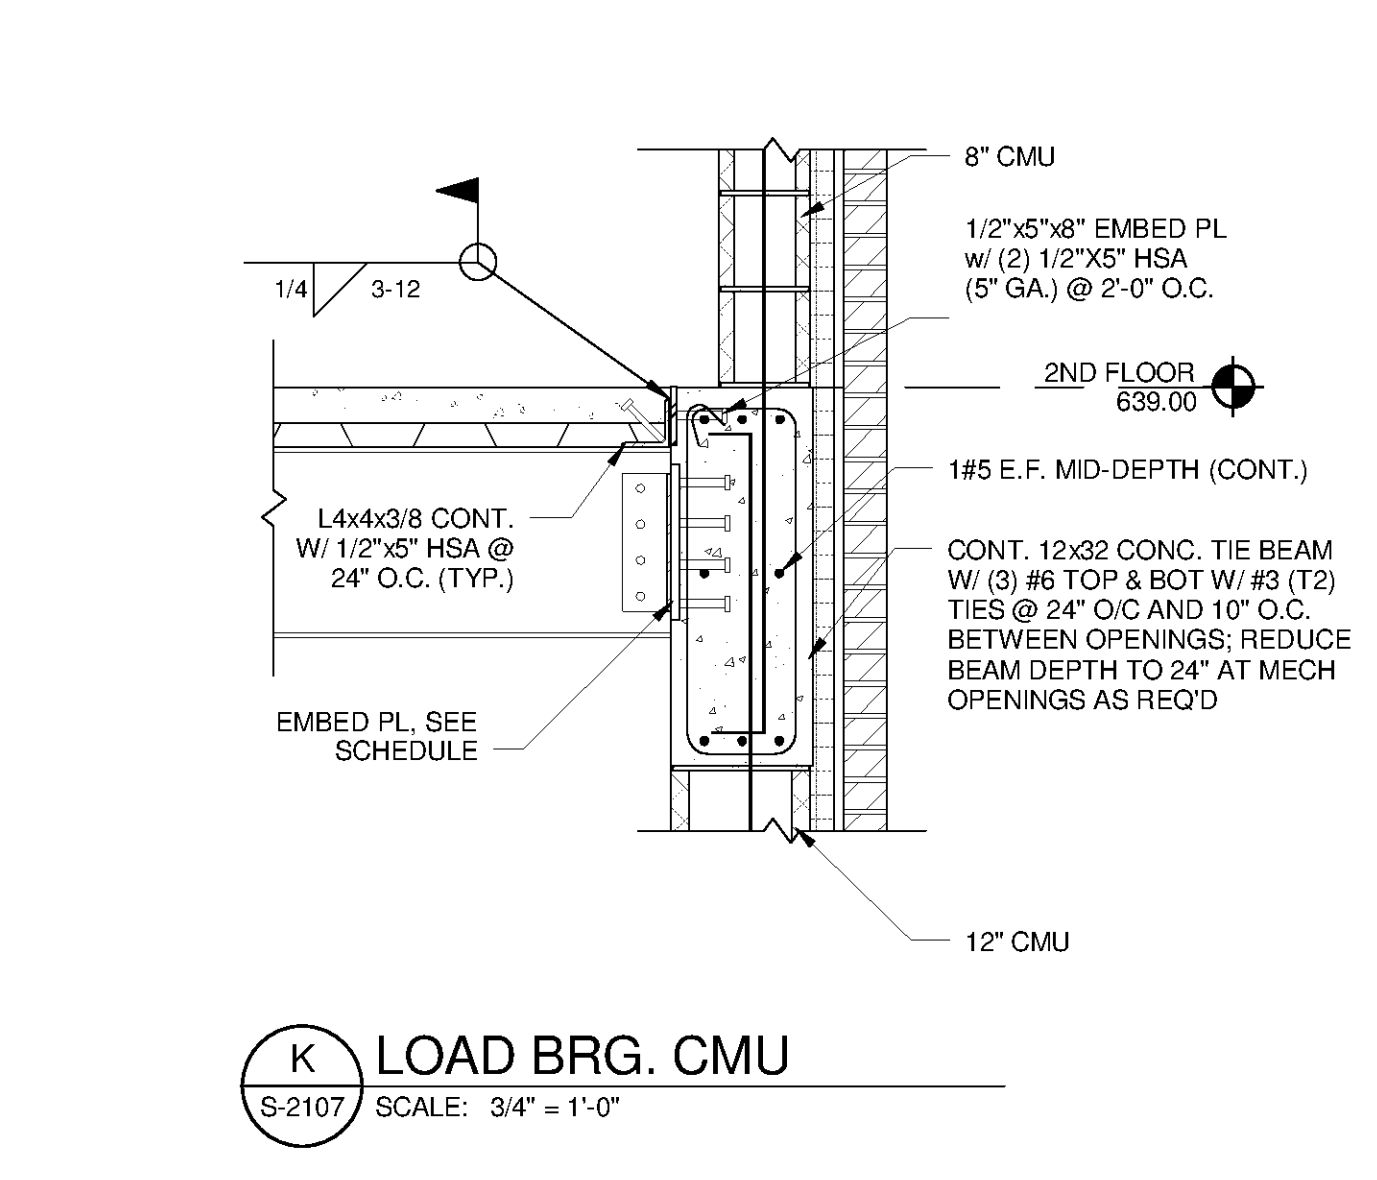


**K LOAD BRG. CMU**  
S-2107 SCALE: 3/4" = 1'-0"

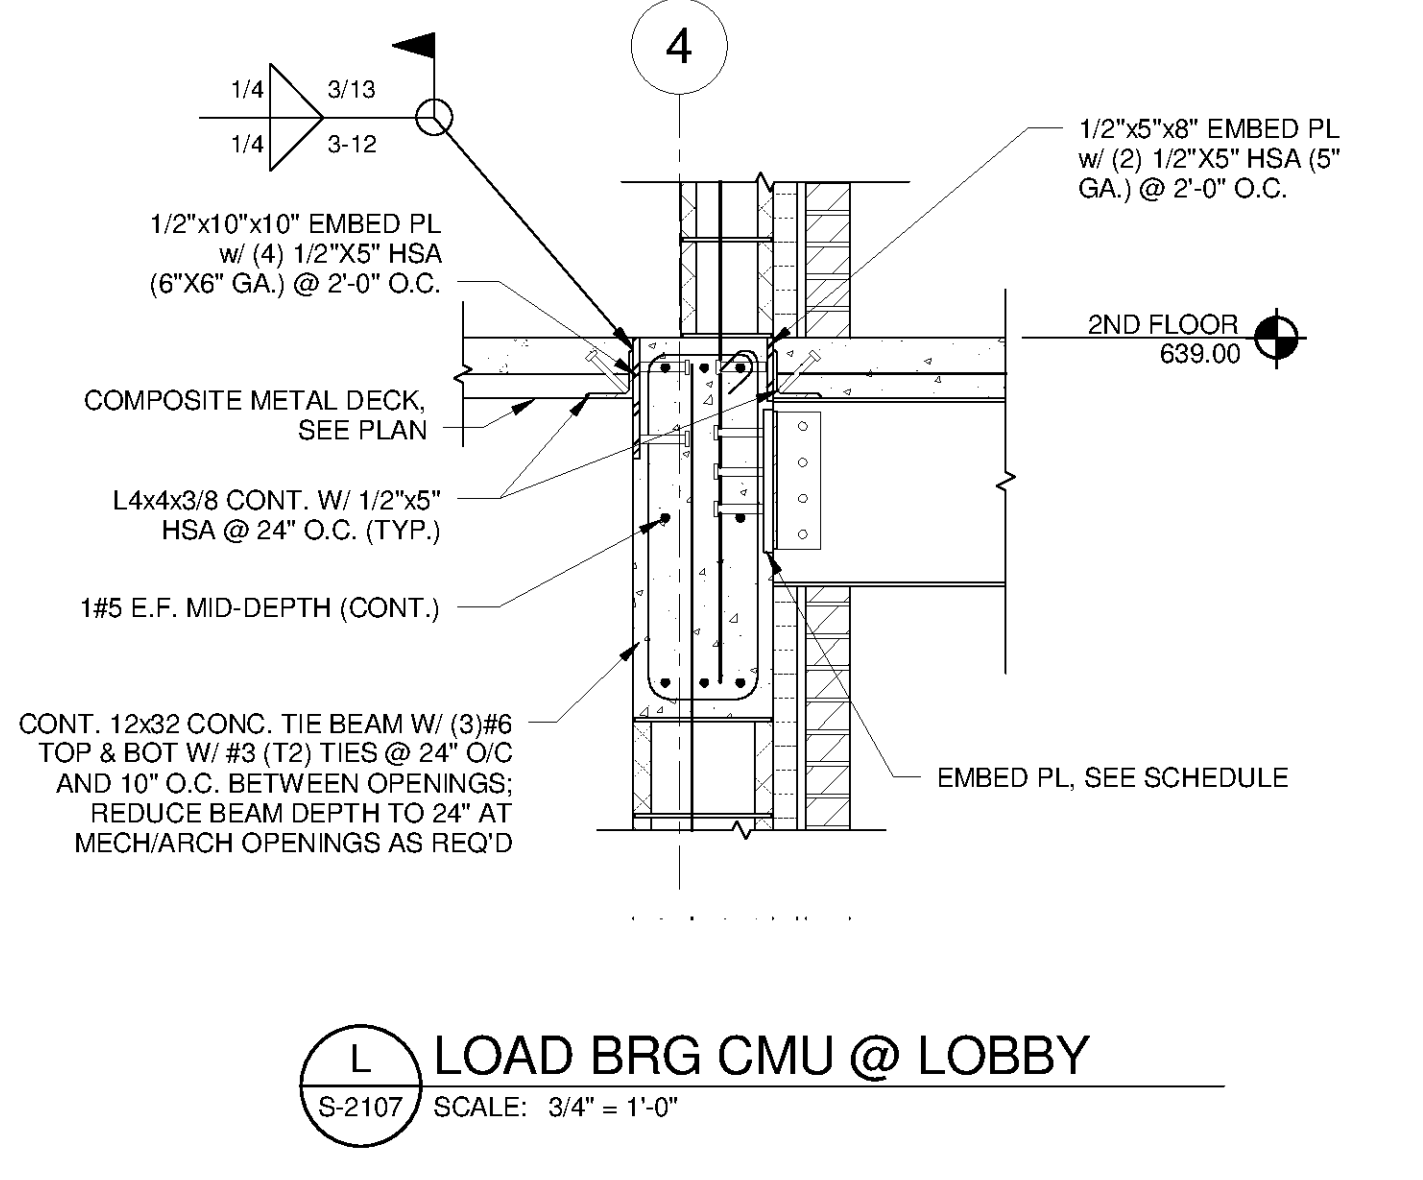

**L LOAD BRG CMU @ LOBBY**  
S-2107 SCALE: 3/4" = 1'-0"

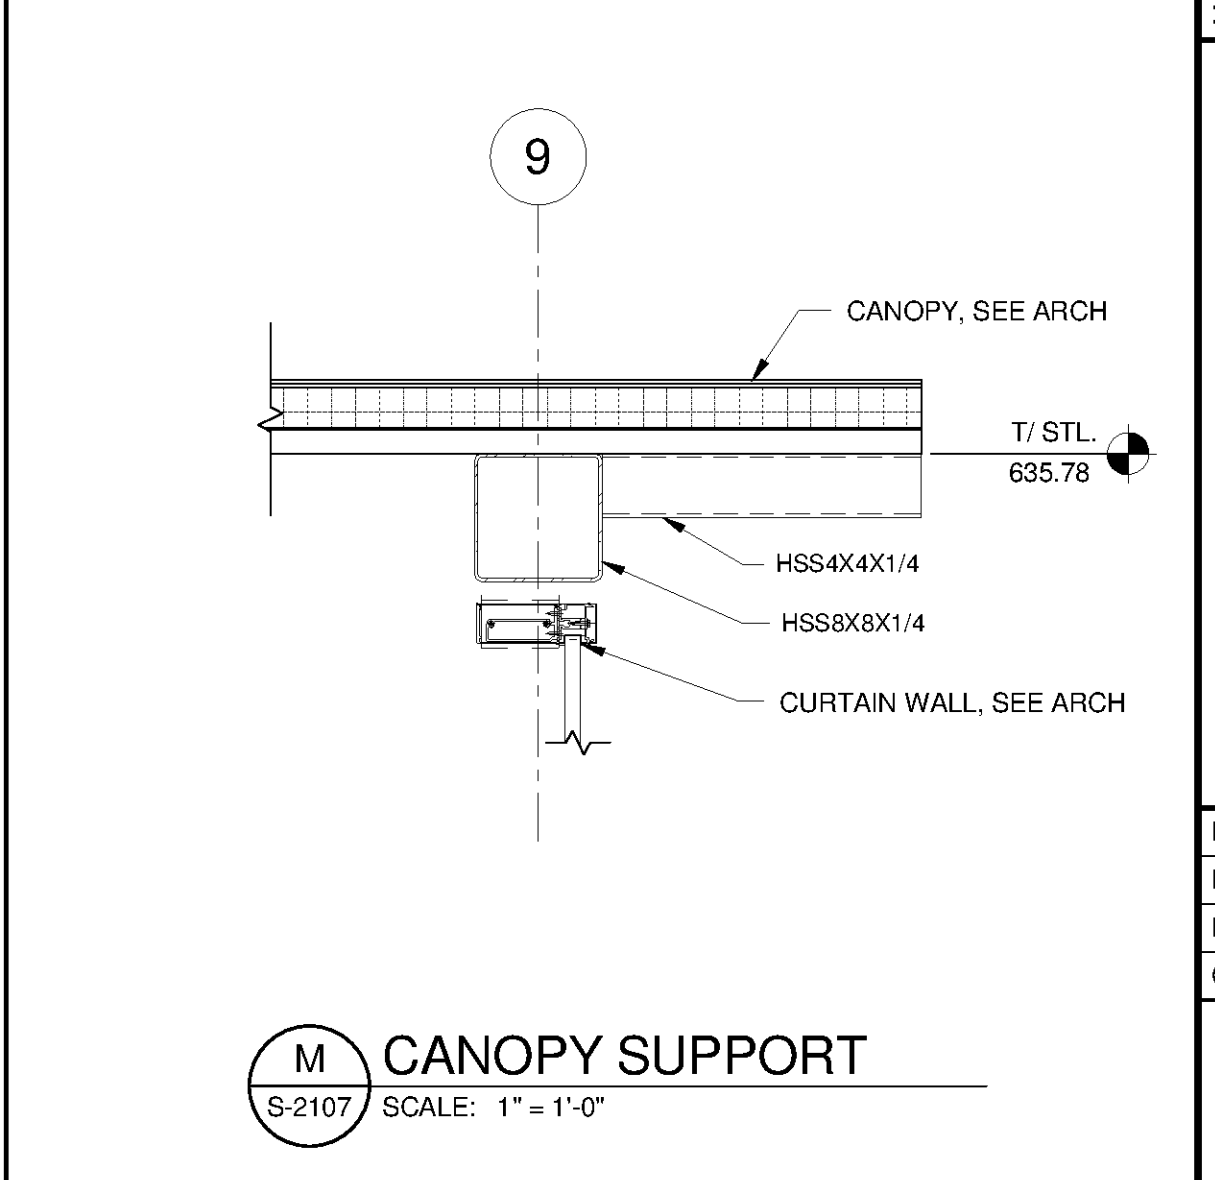

**M CANOPY SUPPORT**  
S-2107 SCALE: 1" = 1'-0"

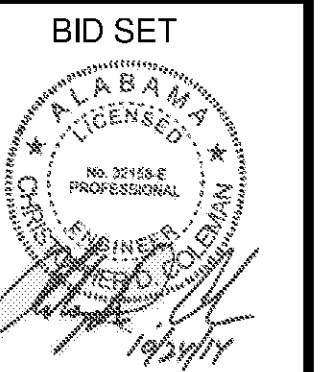

| BY | DATE | DESCRIPTION |
|----|------|-------------|
|    |      |             |
|    |      |             |
| MARK | DATE | DESCRIPTION |
|------|------|-------------|
|      |      |             |
|      |      |             |
HUNTSVILLE UTILITIES  
SOUTHEAST WATER TREATMENT PLANT  
**MAIN PROCESS BUILDING**  
SECTIONS AND DETAILS

Project No.: 200-11740-10003  
Designed By: JLB  
Drawn By: BRF  
Checked By: CDC

**S-2311**

Copyright: Tetra Tech  
Bar Measures 1 Inch