


- PLAN NOTES:**
- REFER TO G-0003 FOR OVERALL SITE PLAN AND PROCESS AREA LOCATIONS
 - REFER TO S-001 THRU S-003 FOR GENERAL NOTES

1 DRYING BED ENLARGED PLAN
 S-6101 SCALE: 3/8" = 1'-0"

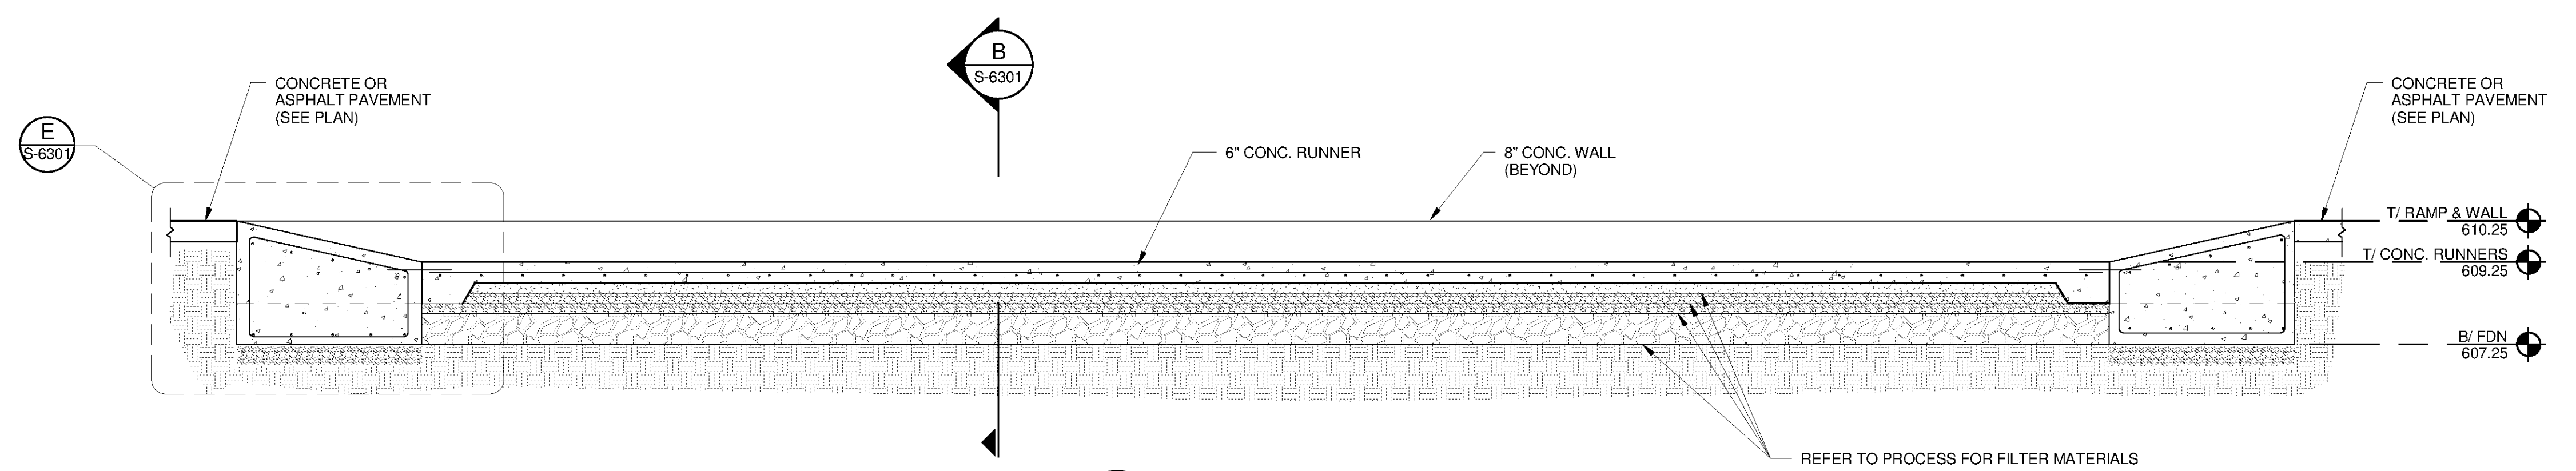

A SLUDGE DRYING BED SECTION
 S-6102 SCALE: 3/8" = 1'-0"

TETRA TECH
 www.tetra-tech.com
 101 QUALITY CIRCLE, SUITE 140
 HUNTSVILLE, ALABAMA 35806
 PHONE: (256) 424-4077 FAX: (256) 424-4087

BID SET
 ALABAMA
 LICENSED PROFESSIONAL ENGINEER
 No. 35103-E
 State of Alabama
 10/24/14

MARK	DATE	DESCRIPTION	BY

HUNTSVILLE UTILITIES
 SOUTHEAST WATER TREATMENT PLANT
**SLUDGE DRYING BEDS
 ENLARGED PLAN AND
 SECTION**

Project No.: 200-11740-10003
 Designed By: JLB
 Drawn By: BRF
 Checked By: CDC

S-6102