




10/21/2014 8:38:03 AM C:\Users\Quintin.Biagi\Documents\WTP-11740-A-MAINPR_Quintin.Biagi.rvt

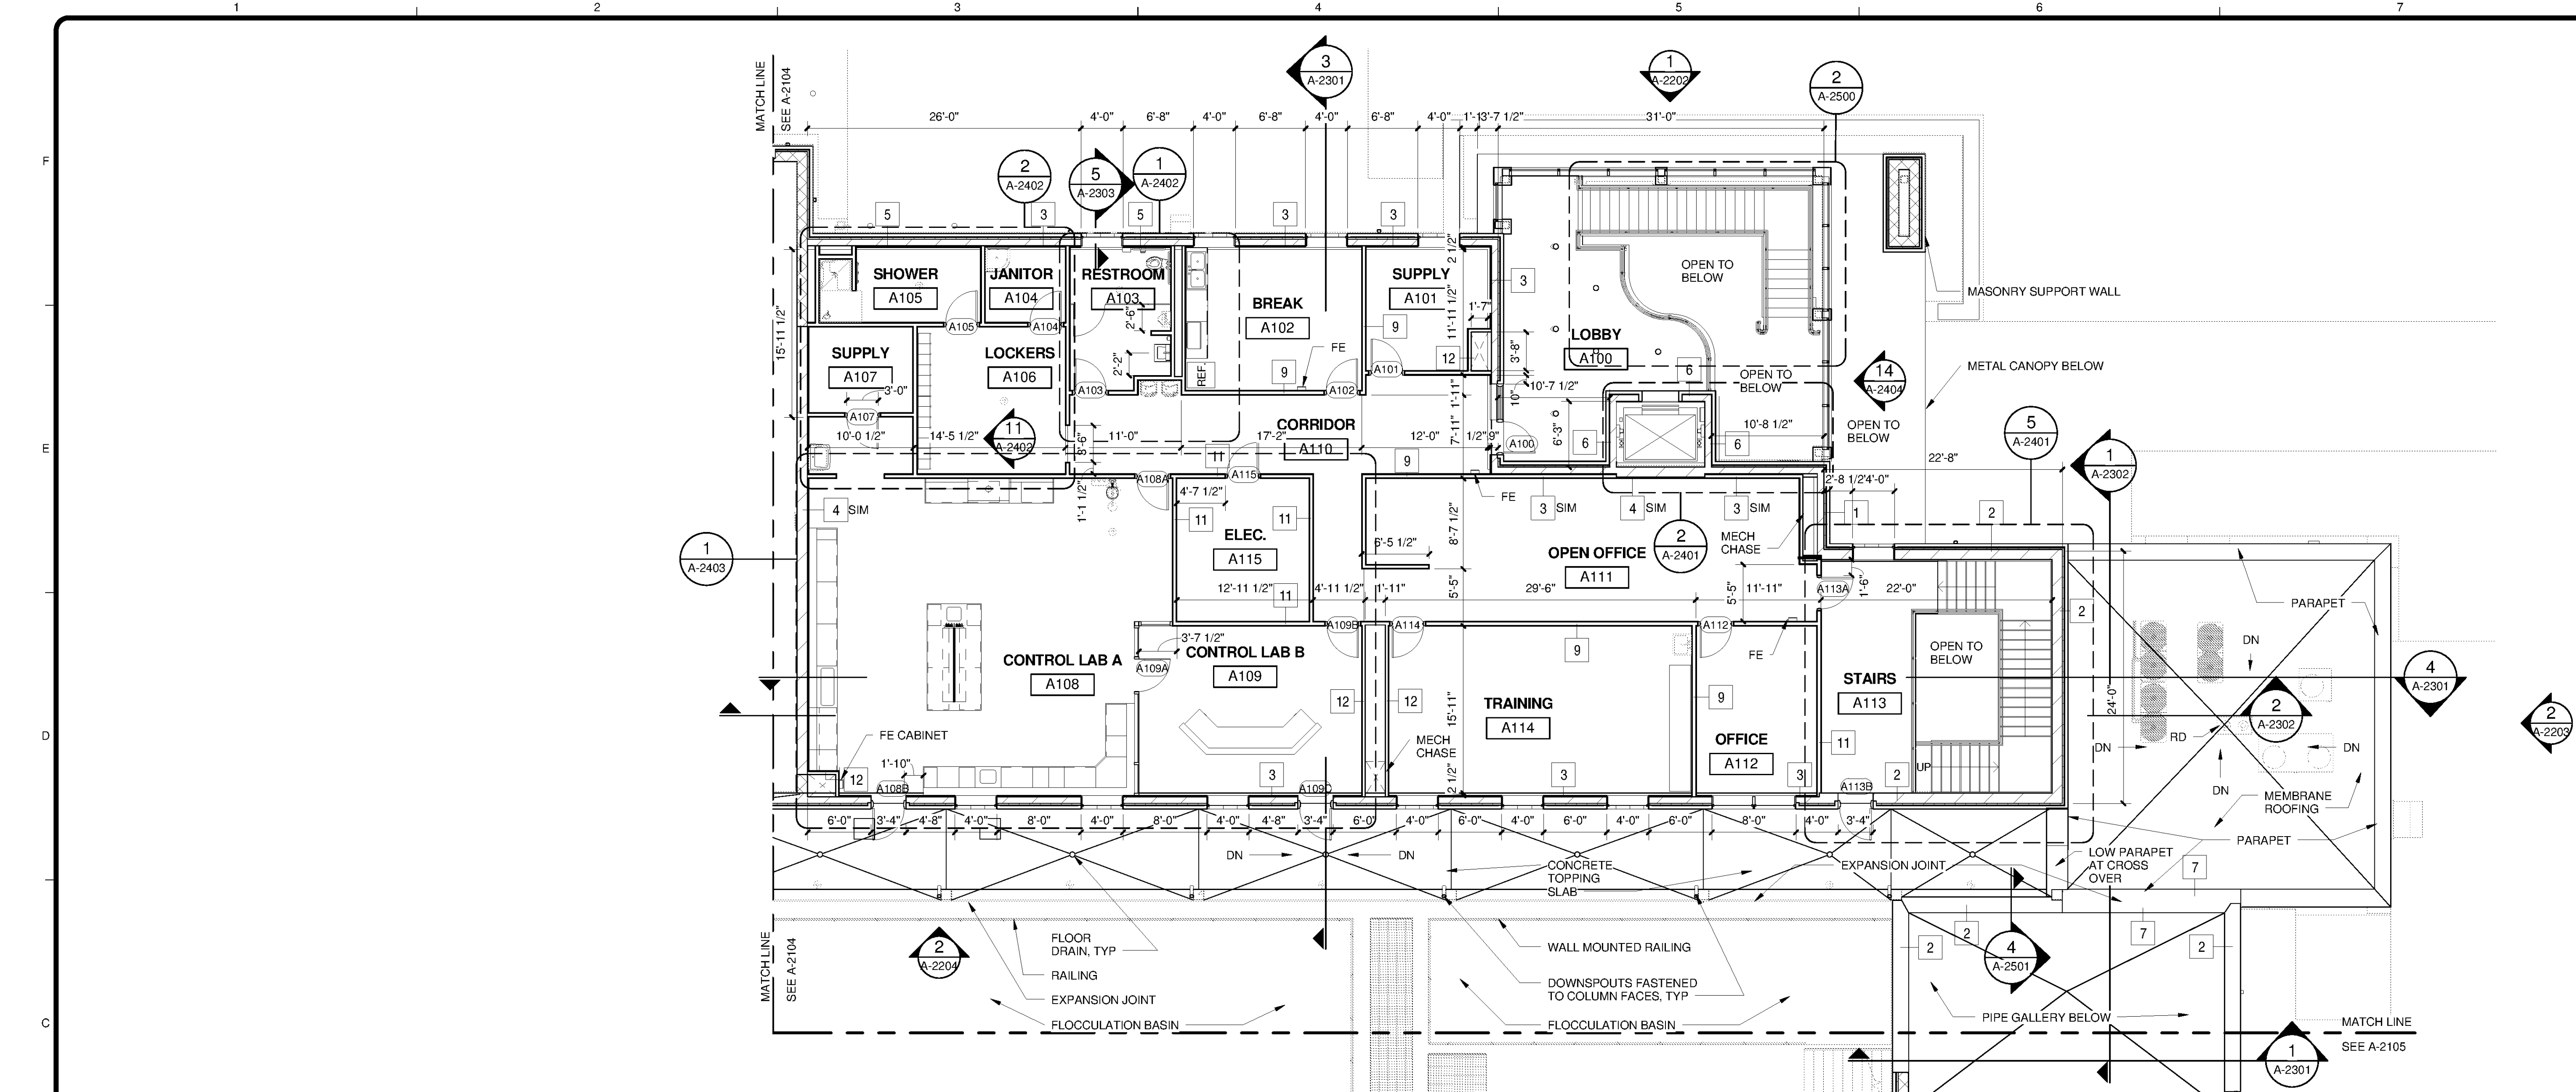


OPERATIONS 2ND FLOOR PLAN - 639
SCALE: 1/8" = 1'-0"

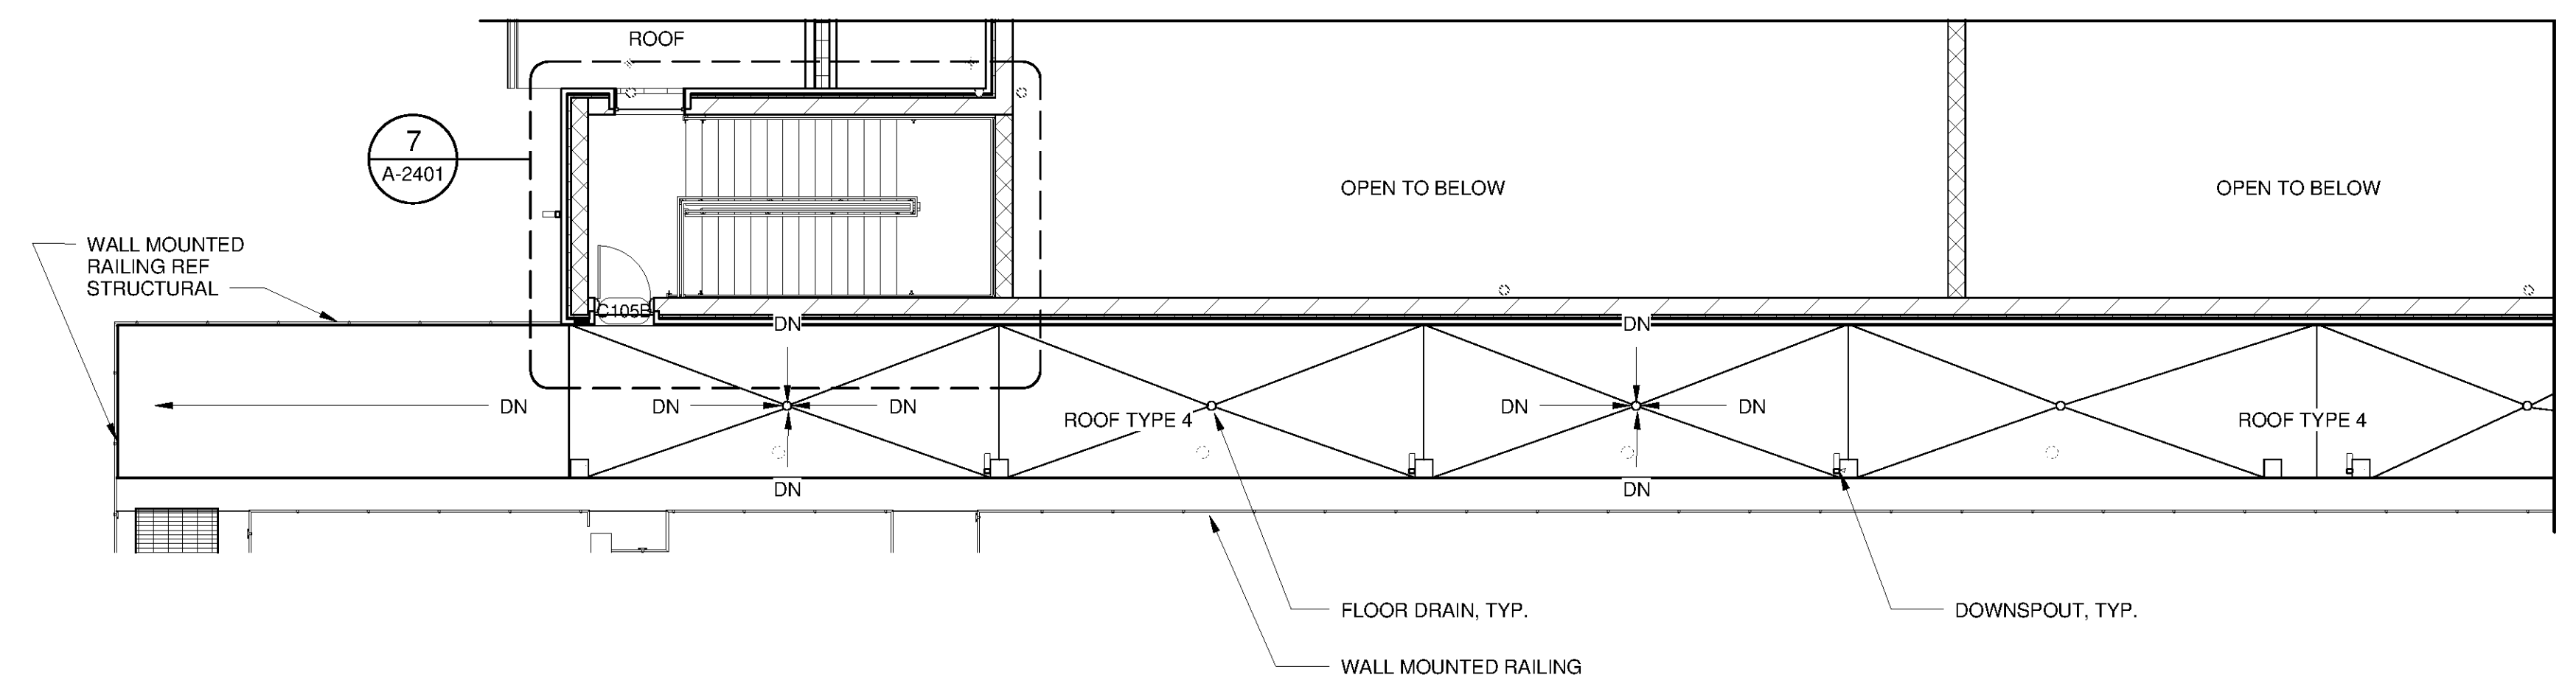

CHEM FEED 2ND FLOOR PLAN - ELEV. 639
SCALE: 1/8" = 1'-0"

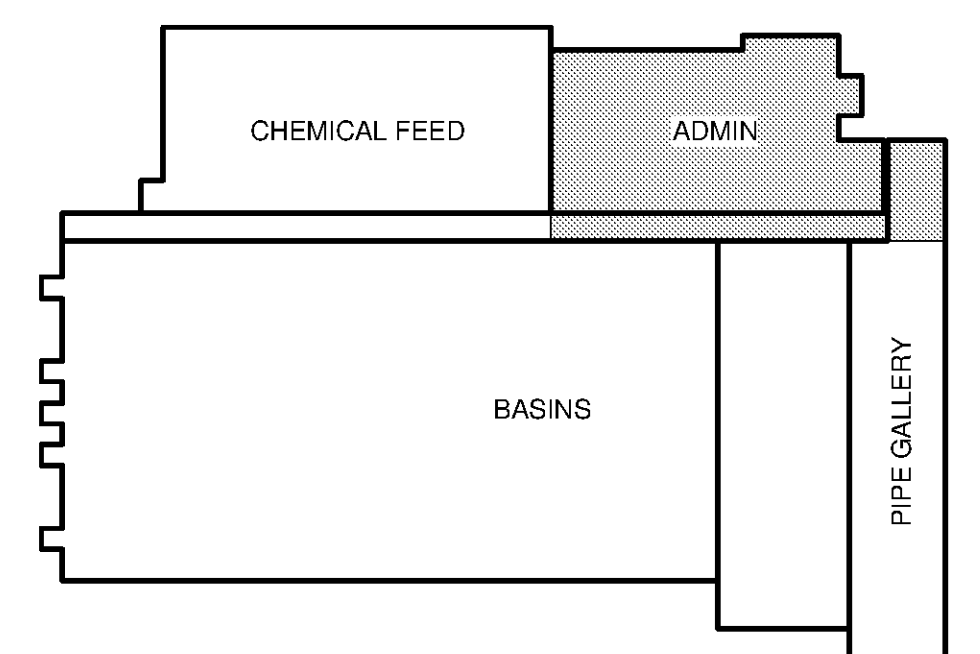

KEY PLAN

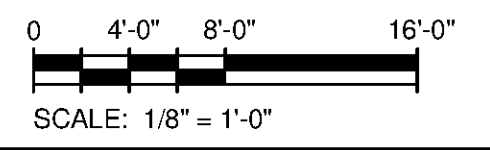

TETRA TECH
www.tetrattech.com
101 QUALITY CIRCLE, SUITE 140
HUNTSVILLE, ALABAMA 35896
PHONE: (256) 424-4077 FAX: (256) 424-4087

BID SET
STATE OF ALABAMA
J. QUINCY BRADLEY
ARCHITECT
6512
10/21/14

MARK	DATE	DESCRIPTION	BY

HUNTSVILLE UTILITIES
SOUTHEAST WATER TREATMENT PLANT
OPS/CHEM FEED SECOND FLOOR PLAN

Project No.: 200-11740-10003
Designed By: Q.BIAGI
Drawn By: S.SWEARER
Checked By: D.GALANTE

A-2103

Bar Measures 1 inch

Copyright: Tetra Tech