




10/21/2014 8:33:12 AM C:\Users\Quintin.Blagi\Documents\WTP-11740-A-MAINPR\_Quintin.Blagi.rvt

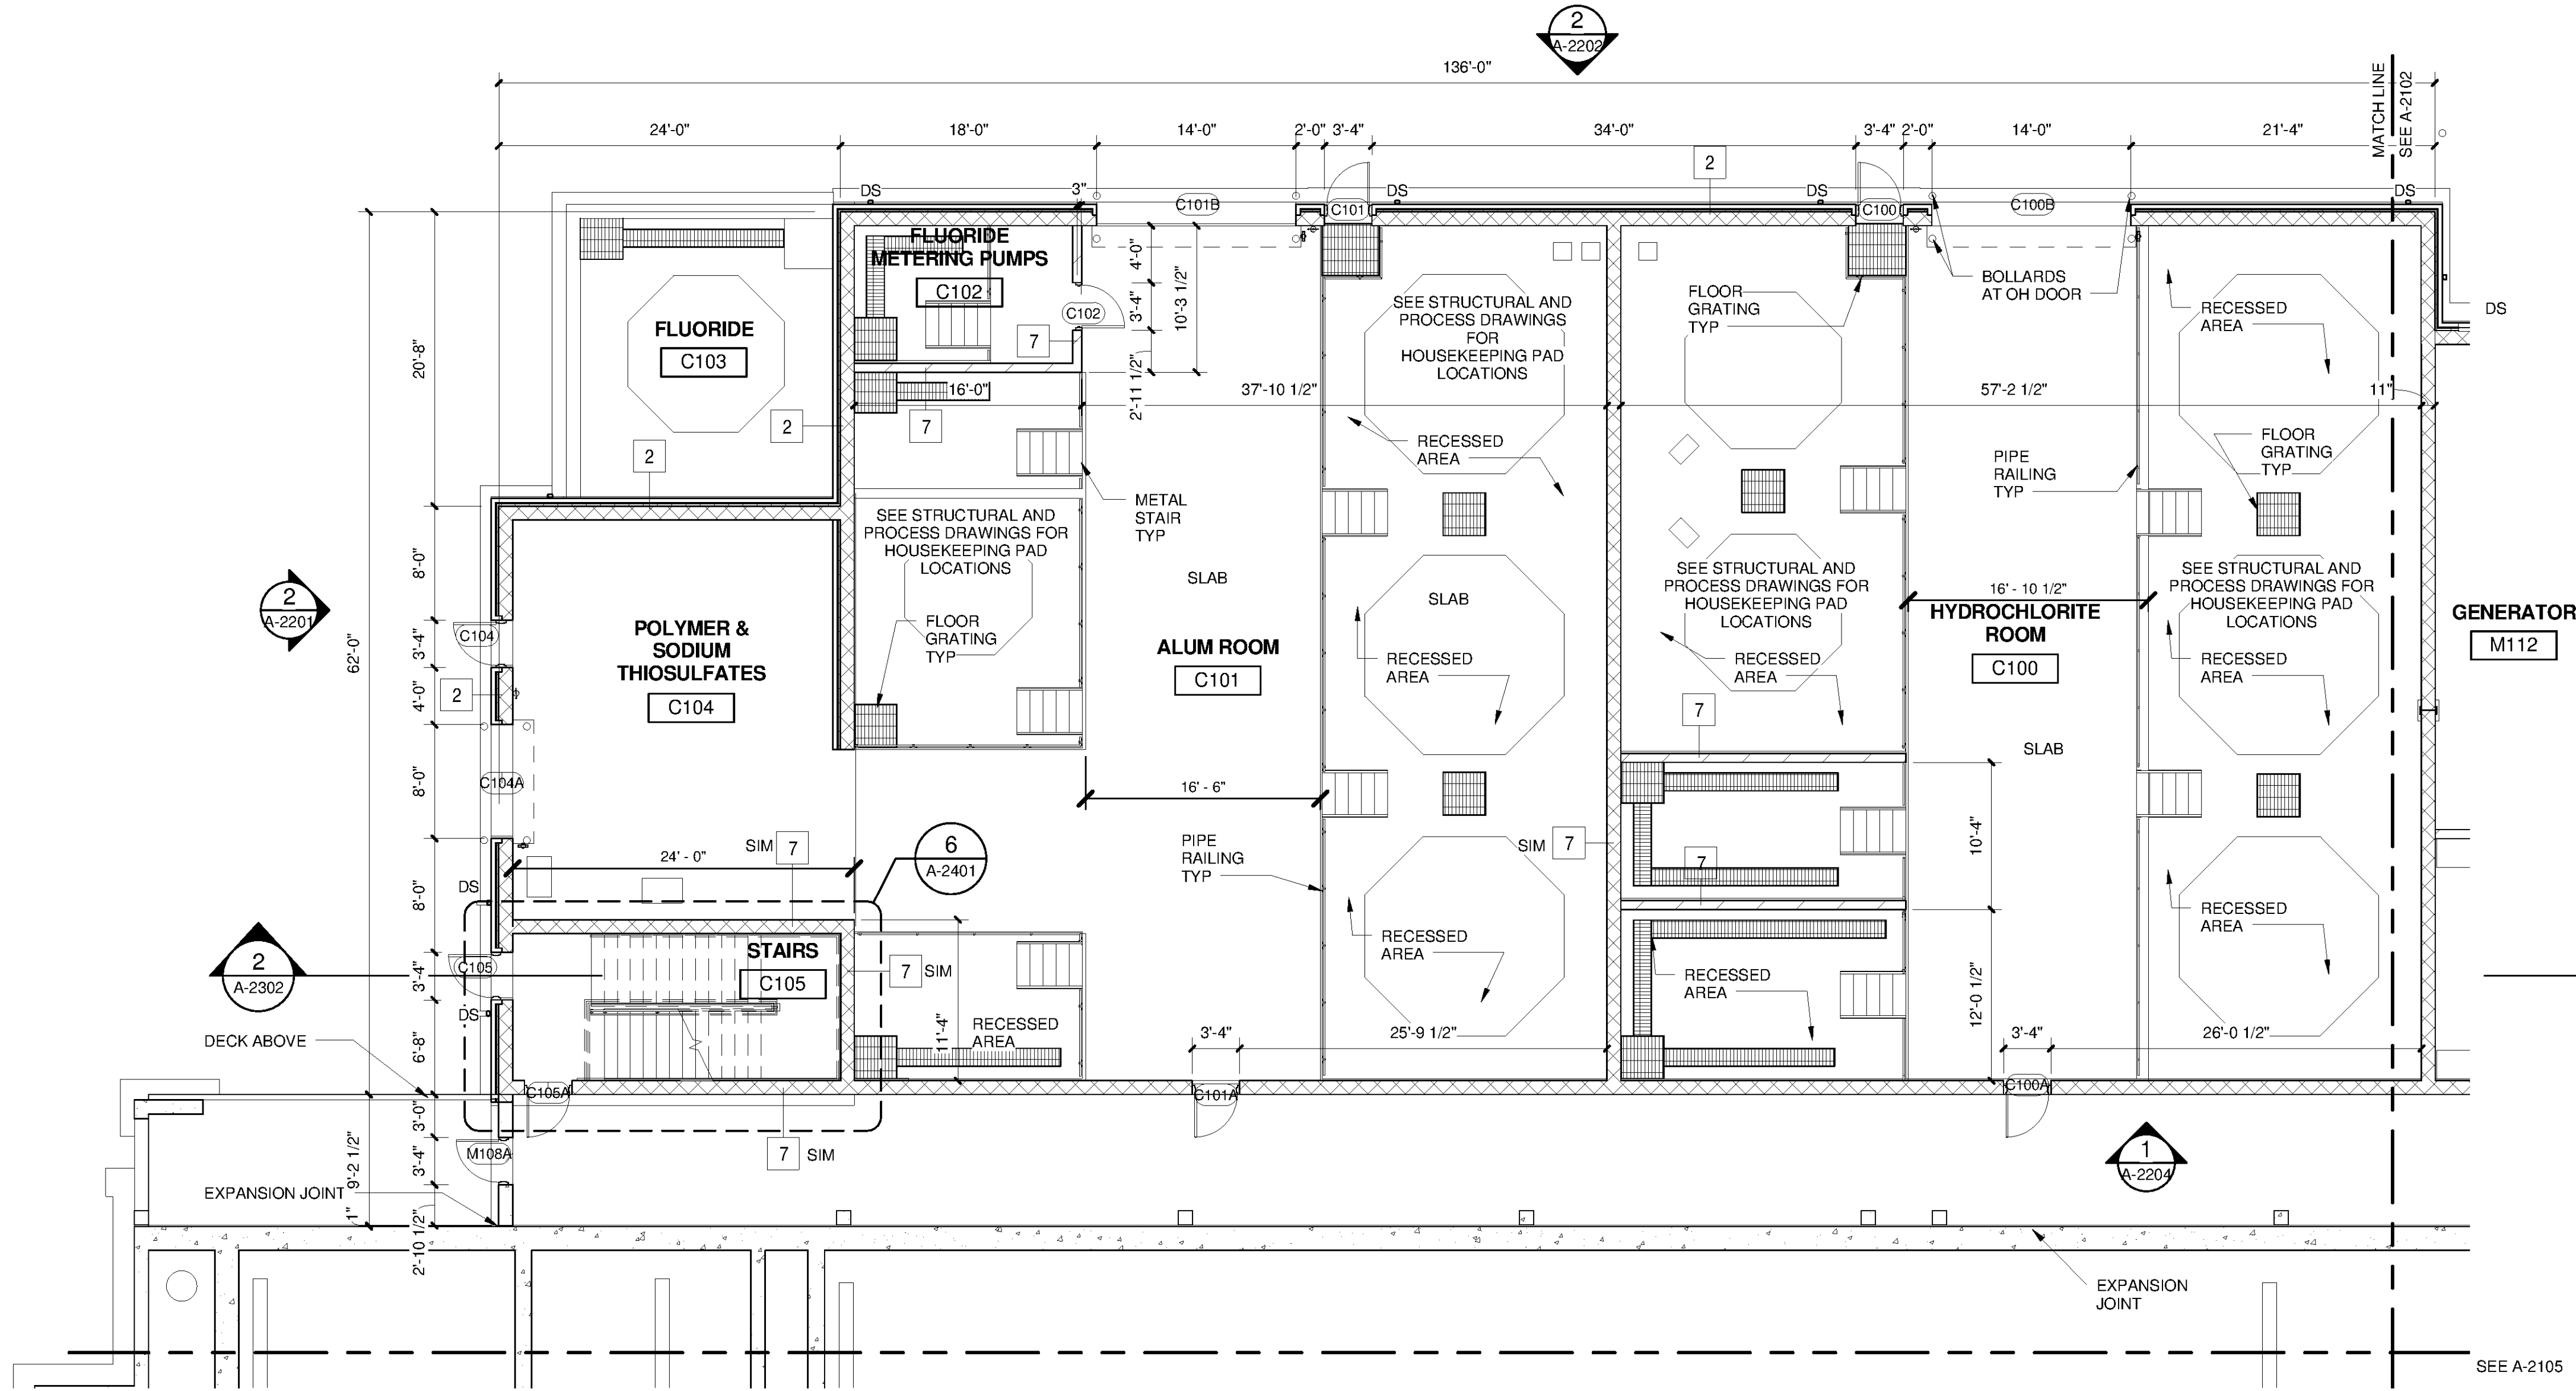

**CHEM FEED FIRST FLOOR PLAN ELEV. 623**  
SCALE: 1/8" = 1'-0"

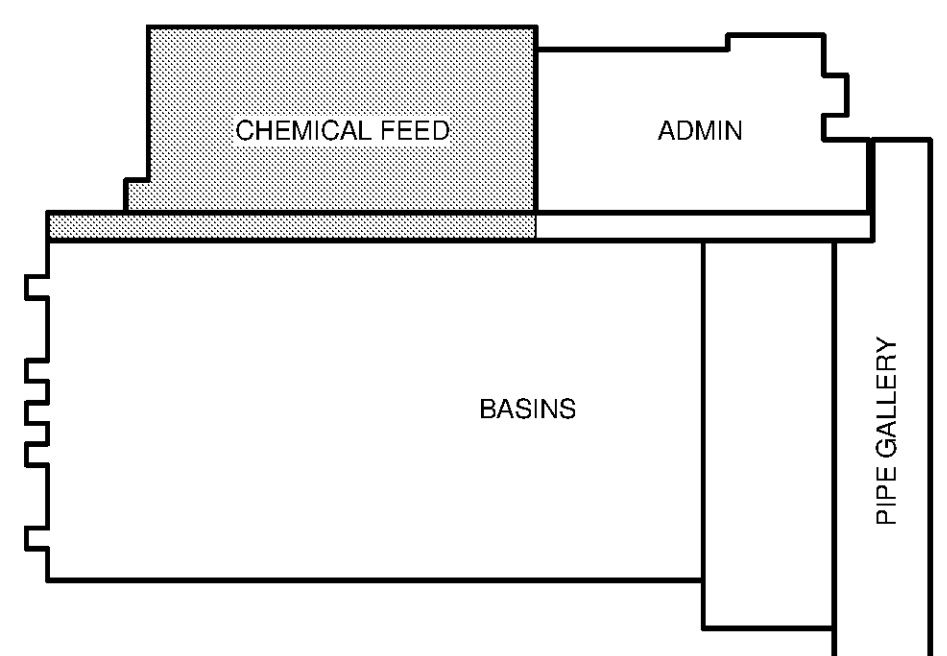

**KEY PLAN**

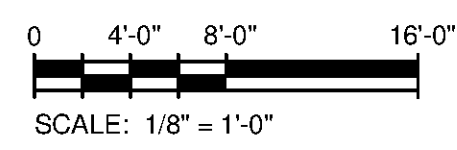

MARK	DATE	DESCRIPTION	BY

HUNTSVILLE UTILITIES  
SOUTHEAST WATER TREATMENT PLANT  
**CHEMICAL FEED FLOOR PLAN**

Project No.: 200-11740-10003  
Designed By: Q.BIAGI  
Drawn By: S.SWEARER  
Checked By: D.GALANTIE

**A-2104**

Bar Measures 1 inch

**TETRA TECH**  
www.tetra-tech.com  
101 QUALITY CIRCLE, SUITE 140  
HUNTSVILLE, ALABAMA 35896  
PHONE: (256) 424-4077 FAX: (256) 424-4087

BID SET  
STATE OF ALABAMA  
J. QUINCY BRADLEY, JR.  
ARCHITECT  
6512  
10/21/14

Copyright: Tetra Tech