



10/3/2014 3:01:41 PM C:\Users\Quintin.Biagi\Documents\WTP-11740-A-MAINPR\_Quintin.Biagi.rvt

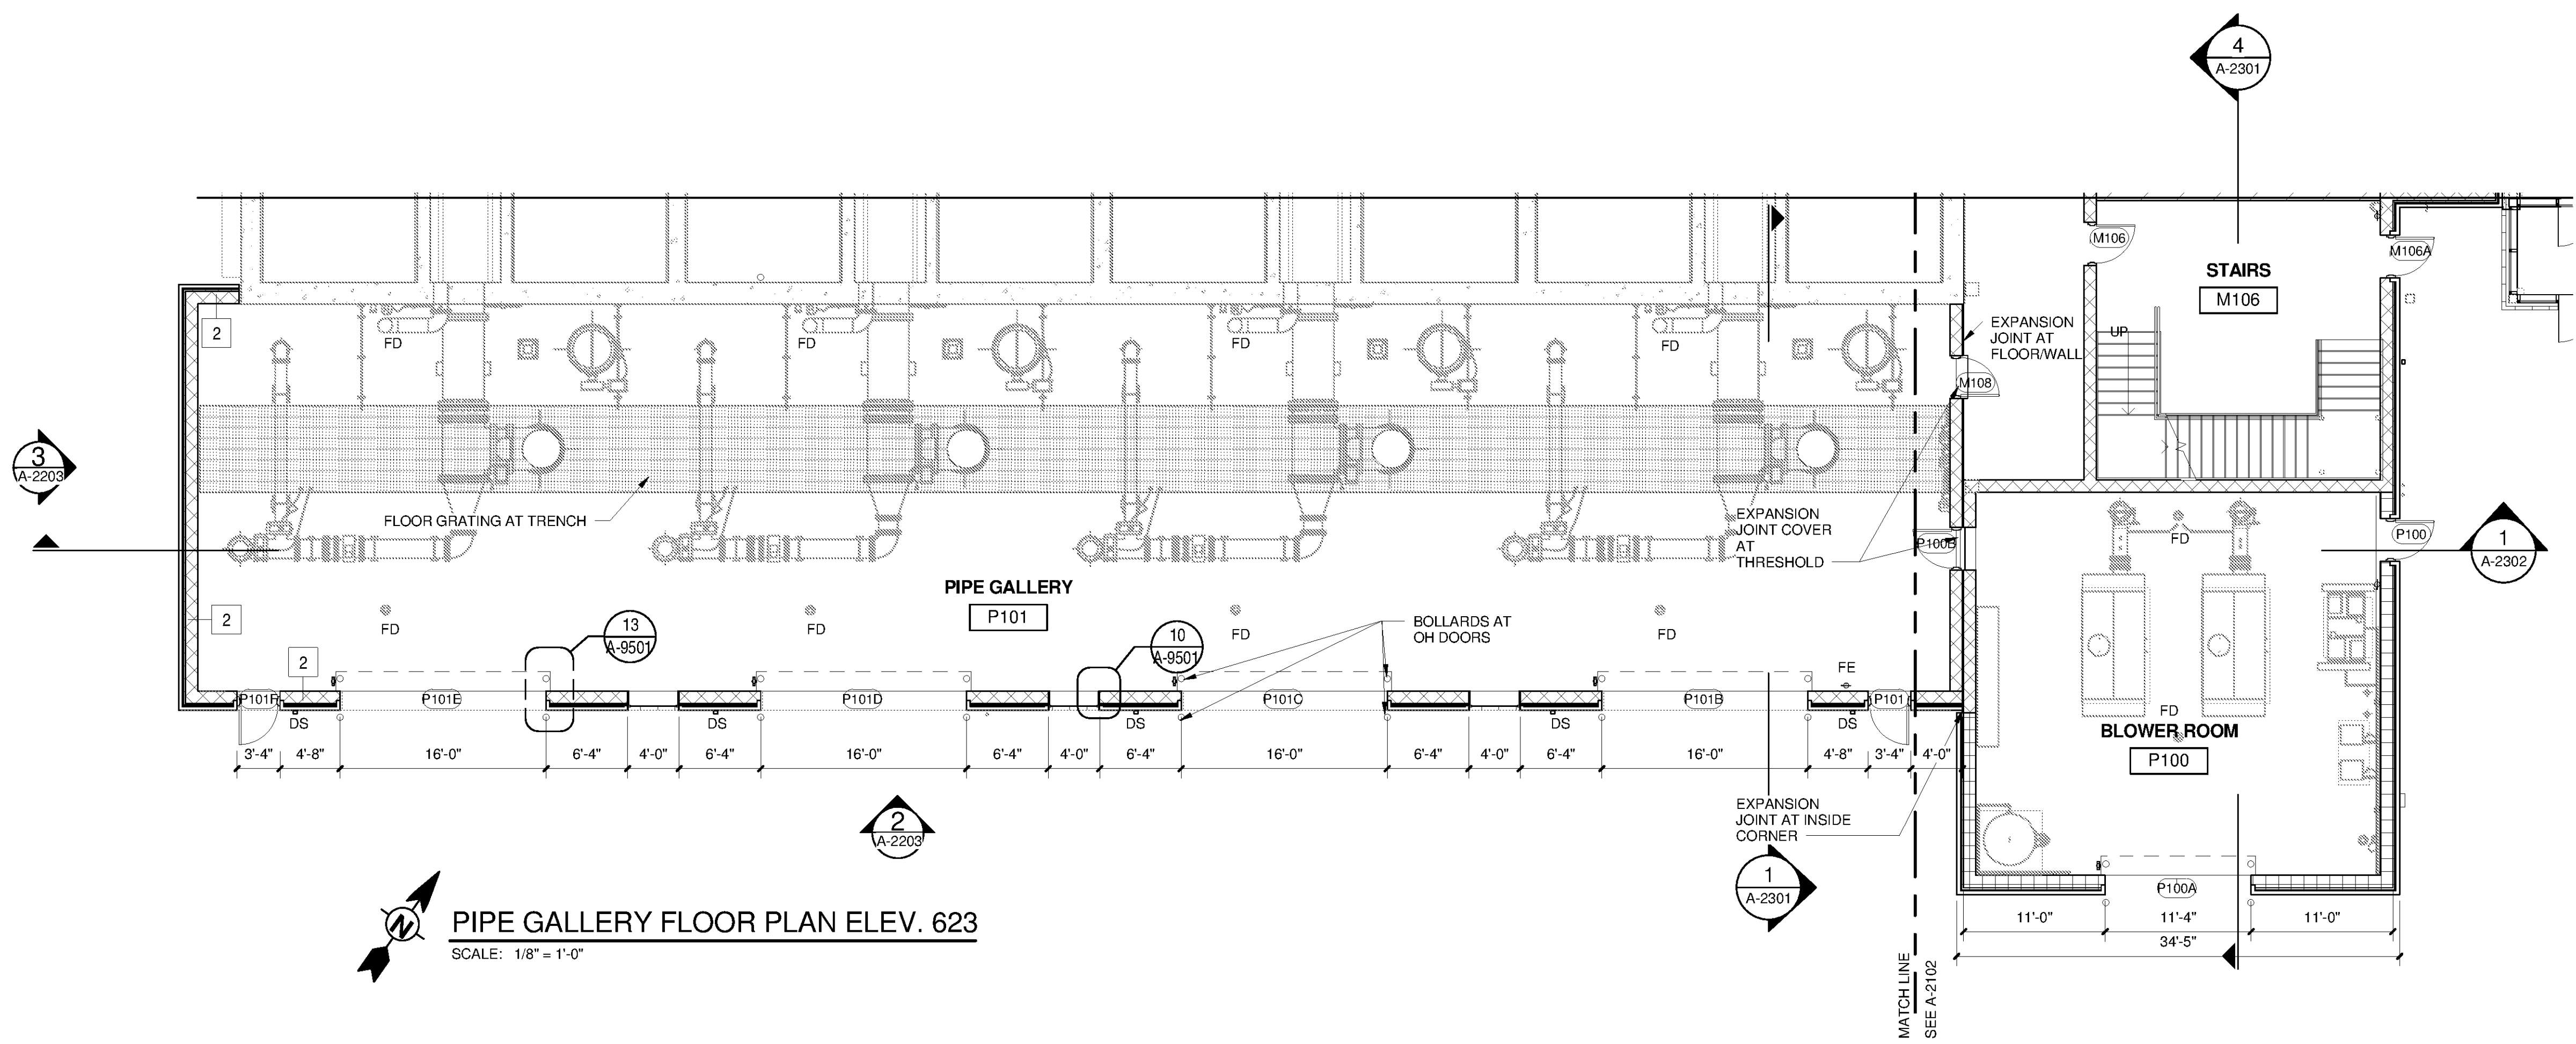

**PIPE GALLERY FLOOR PLAN ELEV. 623**  
 SCALE: 1/8" = 1'-0"

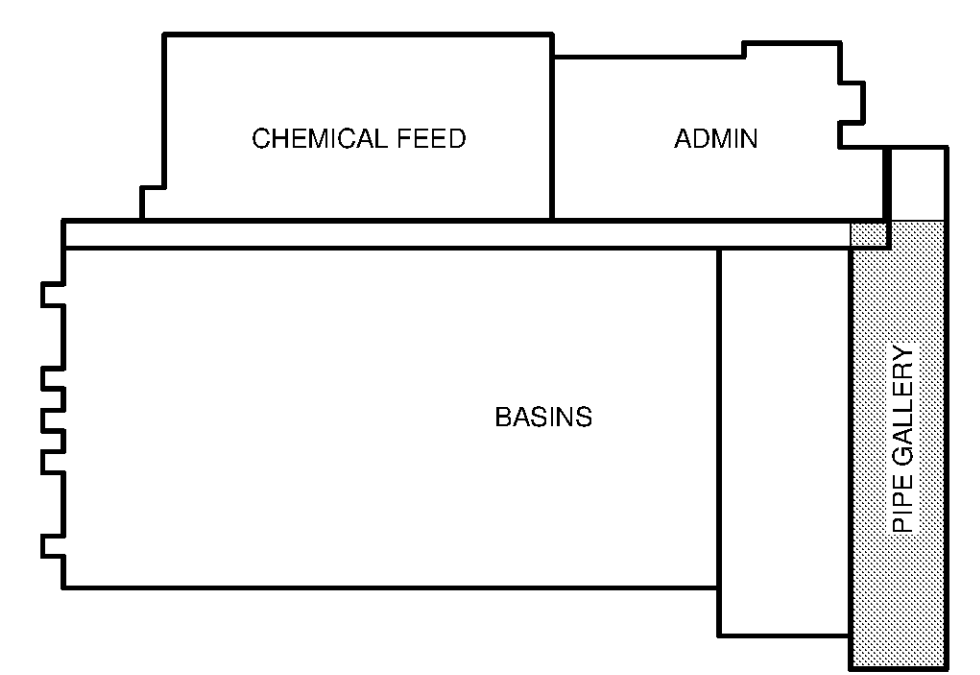

**KEY PLAN**

0 4'-0" 8'-0" 16'-0"  
 SCALE: 1/8" = 1'-0"

**TETRA TECH**  
 www.tetra.tech.com  
 101 QUALITY CIRCLE, SUITE 140  
 HUNTSVILLE, ALABAMA 35806  
 PHONE: (256) 424-4077 FAX: (256) 424-4087

**BID SET**  
 STATE OF ALABAMA  
 J. QUINCY BAGL JR.  
 ARCHITECT  
 6512  
 10/21/14

MARK	DATE	DESCRIPTION	BY

HUNTSVILLE UTILITIES  
 SOUTHEAST WATER TREATMENT PLANT  
**PIPE GALLERY FLOOR PLAN**

Project No.: 200-11740-10003  
 Designed By: Q.BIAGI  
 Drawn By: S.SWEARER  
 Checked By: D.GALANTIE

**A-2105**

Copyright: Tetra Tech  
 Bar Measures 1 inch