




10/3/2014 3:04:51 PM C:\Users\Quintin.Blagi\Documents\WTP-11740-A-MAINPE_Quintin.Blagi.rvt

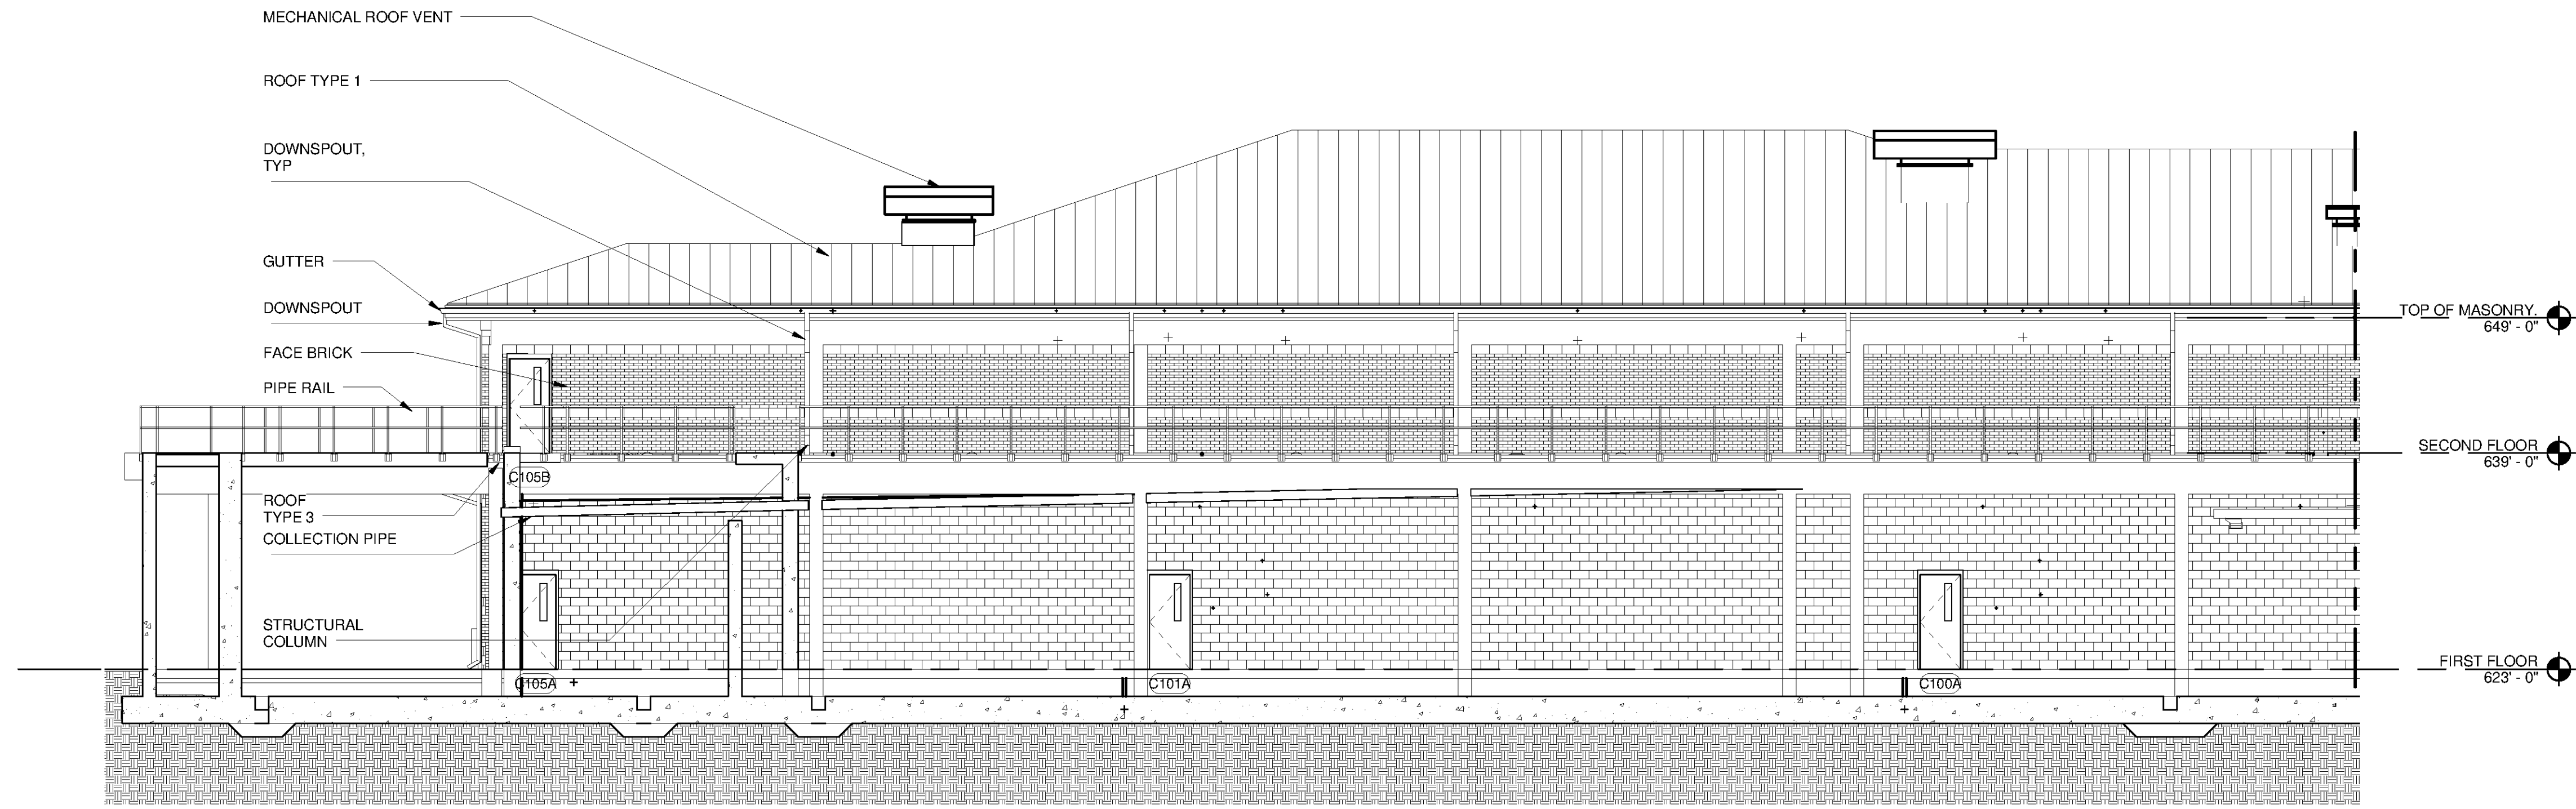

SOUTH ELEVATION - A
SCALE: 1/8" = 1'-0"

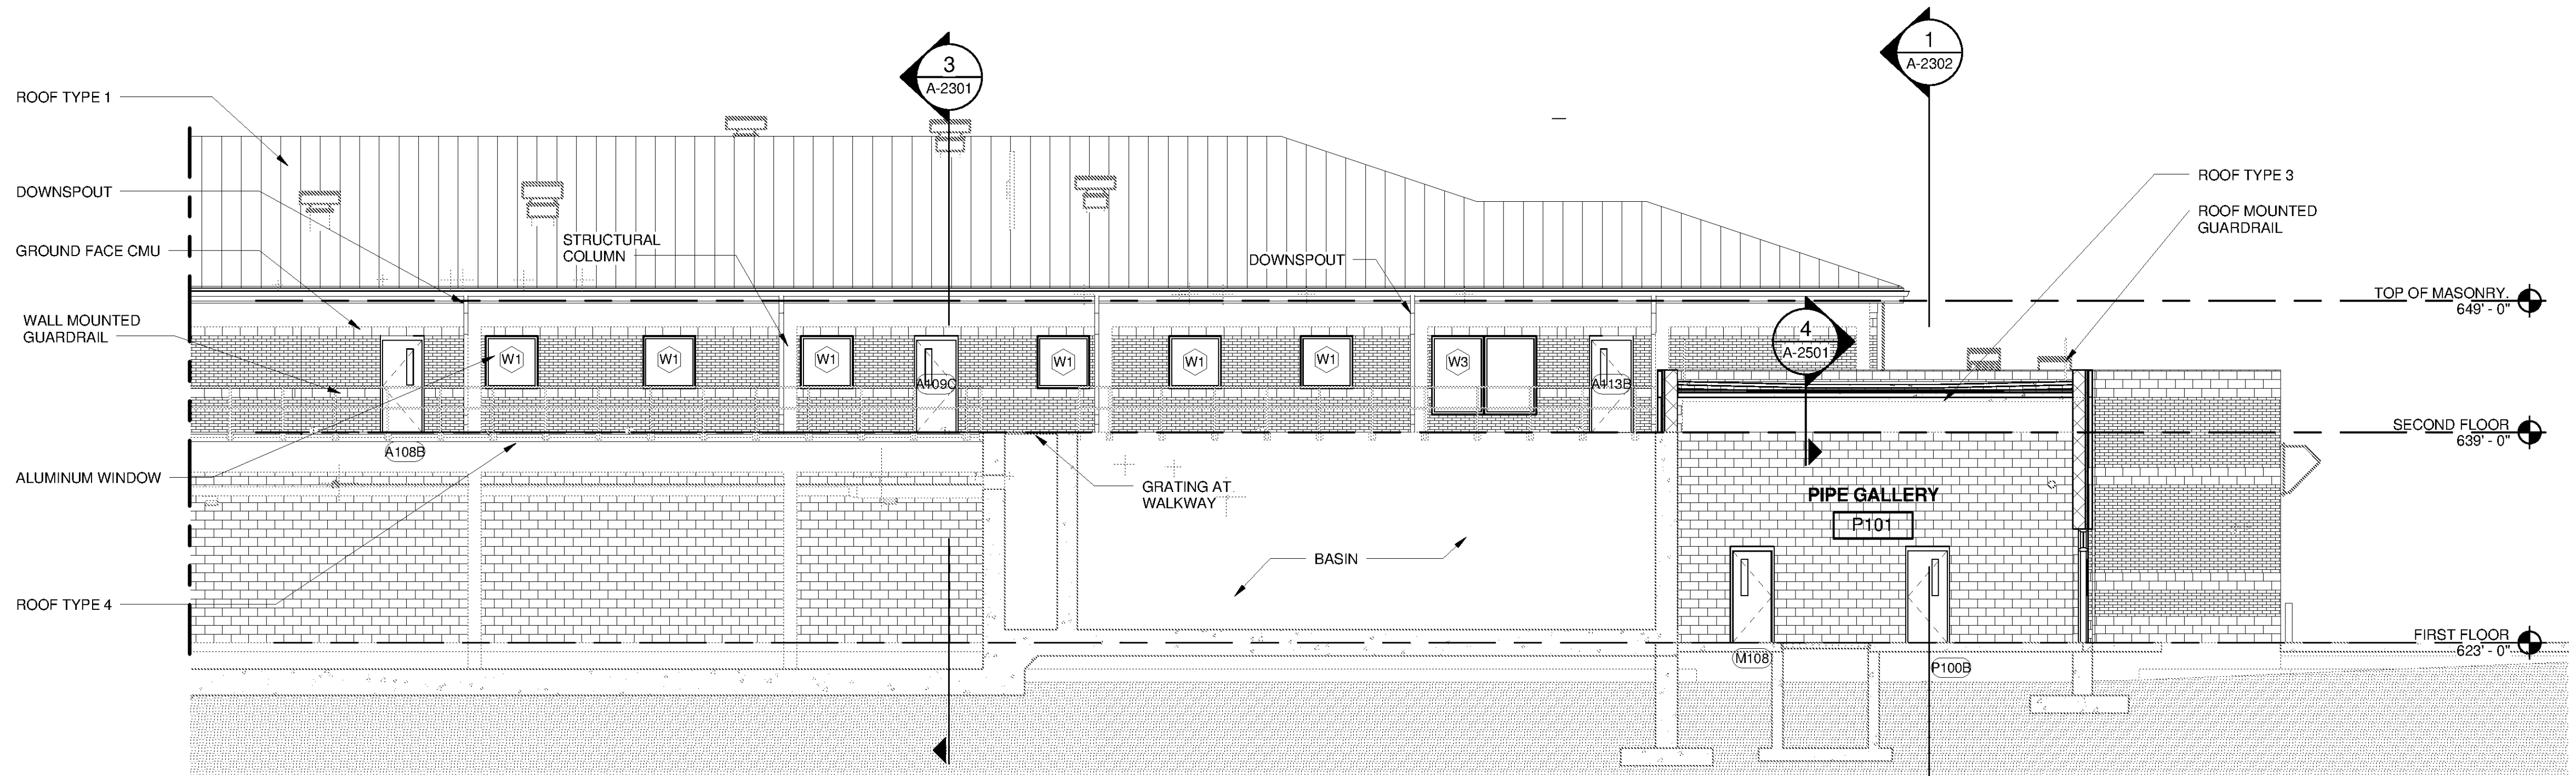

SOUTH ELEVATION - B
SCALE: 1/8" = 1'-0"

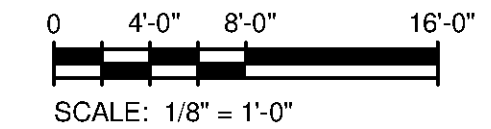

TETRA TECH
www.tetra-tech.com
101 QUALITY CIRCLE, SUITE 140
HUNTSVILLE, ALABAMA 35896
PHONE: (256) 424-4077 FAX: (256) 424-4087

BID SET
Seal of the State of Alabama
J. QUINCY BRADLEY, JR.
ARCHITECT
6512
10/21/14

BY	DESCRIPTION
MARK	DATE

HUNTSVILLE UTILITIES
SOUTHEAST WATER TREATMENT PLANT
EXTERIOR ELEVATIONS

Project No.: 200-11740-10003
Designed By: Q.BIAGI
Drawn By: S.SWEARER
Checked By: D.GALANTE

A-2204

Copyright: Tetra Tech
Bar Measures 1 inch