




C:\Users\brent.fox\Documents\WTP-11740-S-GACBAC\_brent.fox.rvt

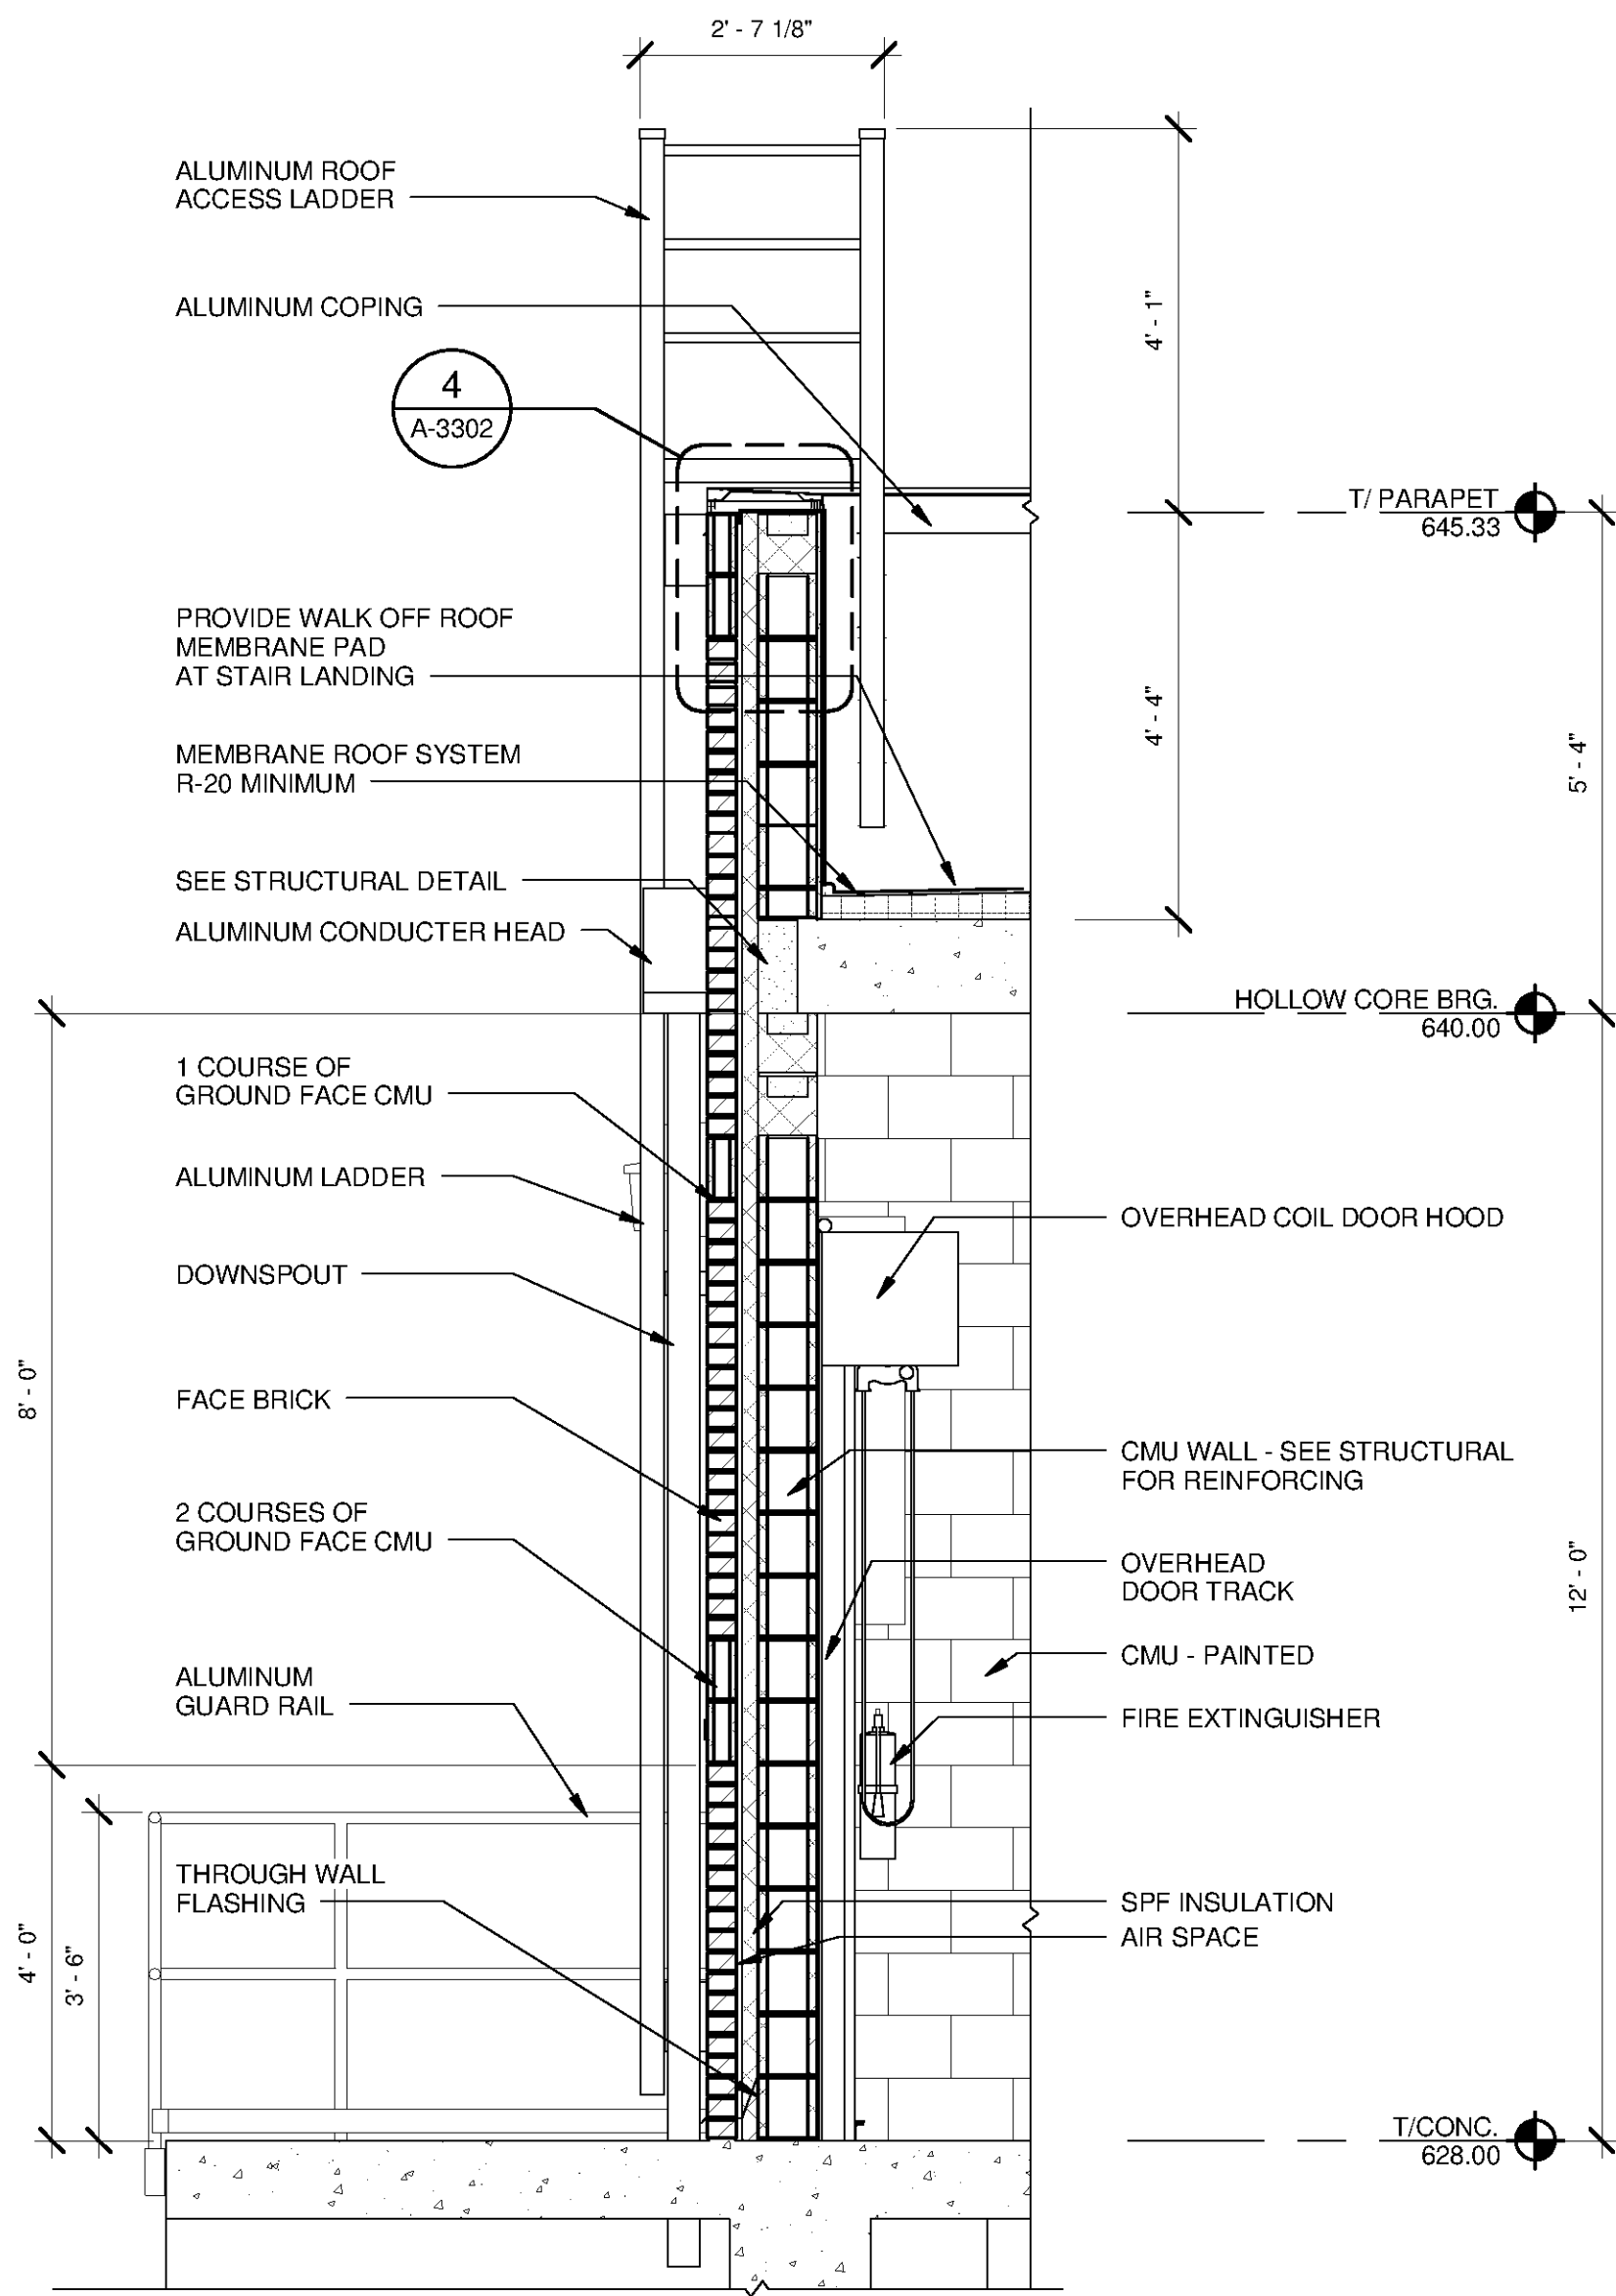


**3 WALL SECTION**  
A-3202 SCALE: 1/2" = 1'-0"

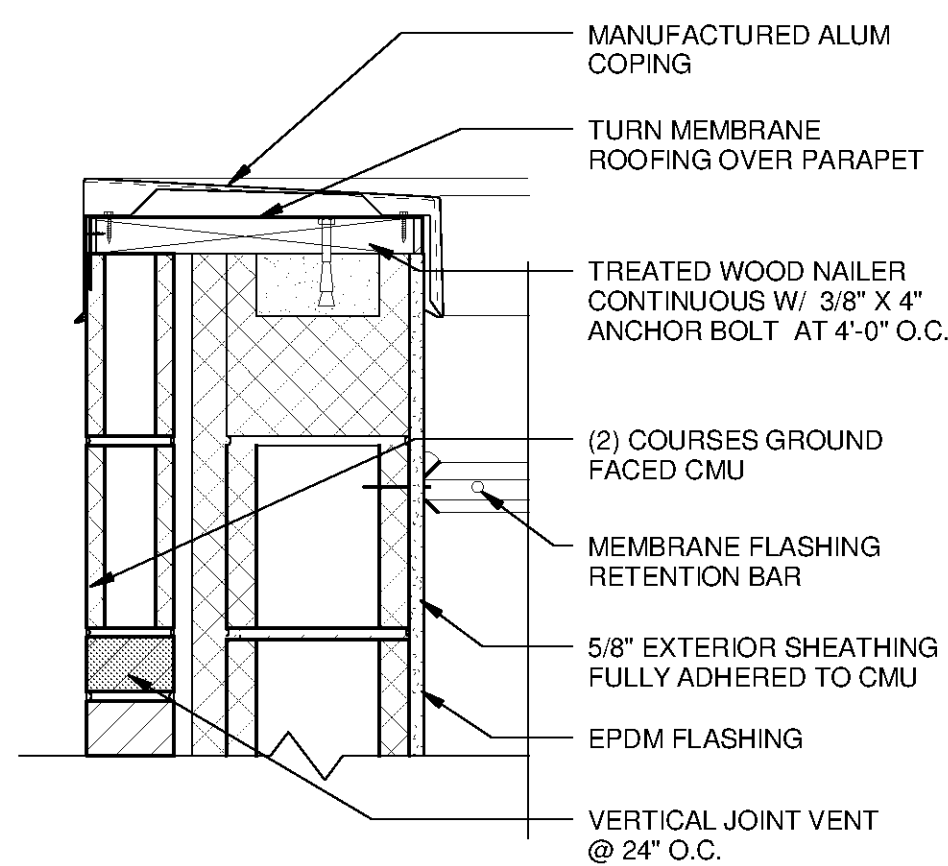


**4 PARAPET DETAIL**  
A-3302 SCALE: 1 1/2" = 1'-0"

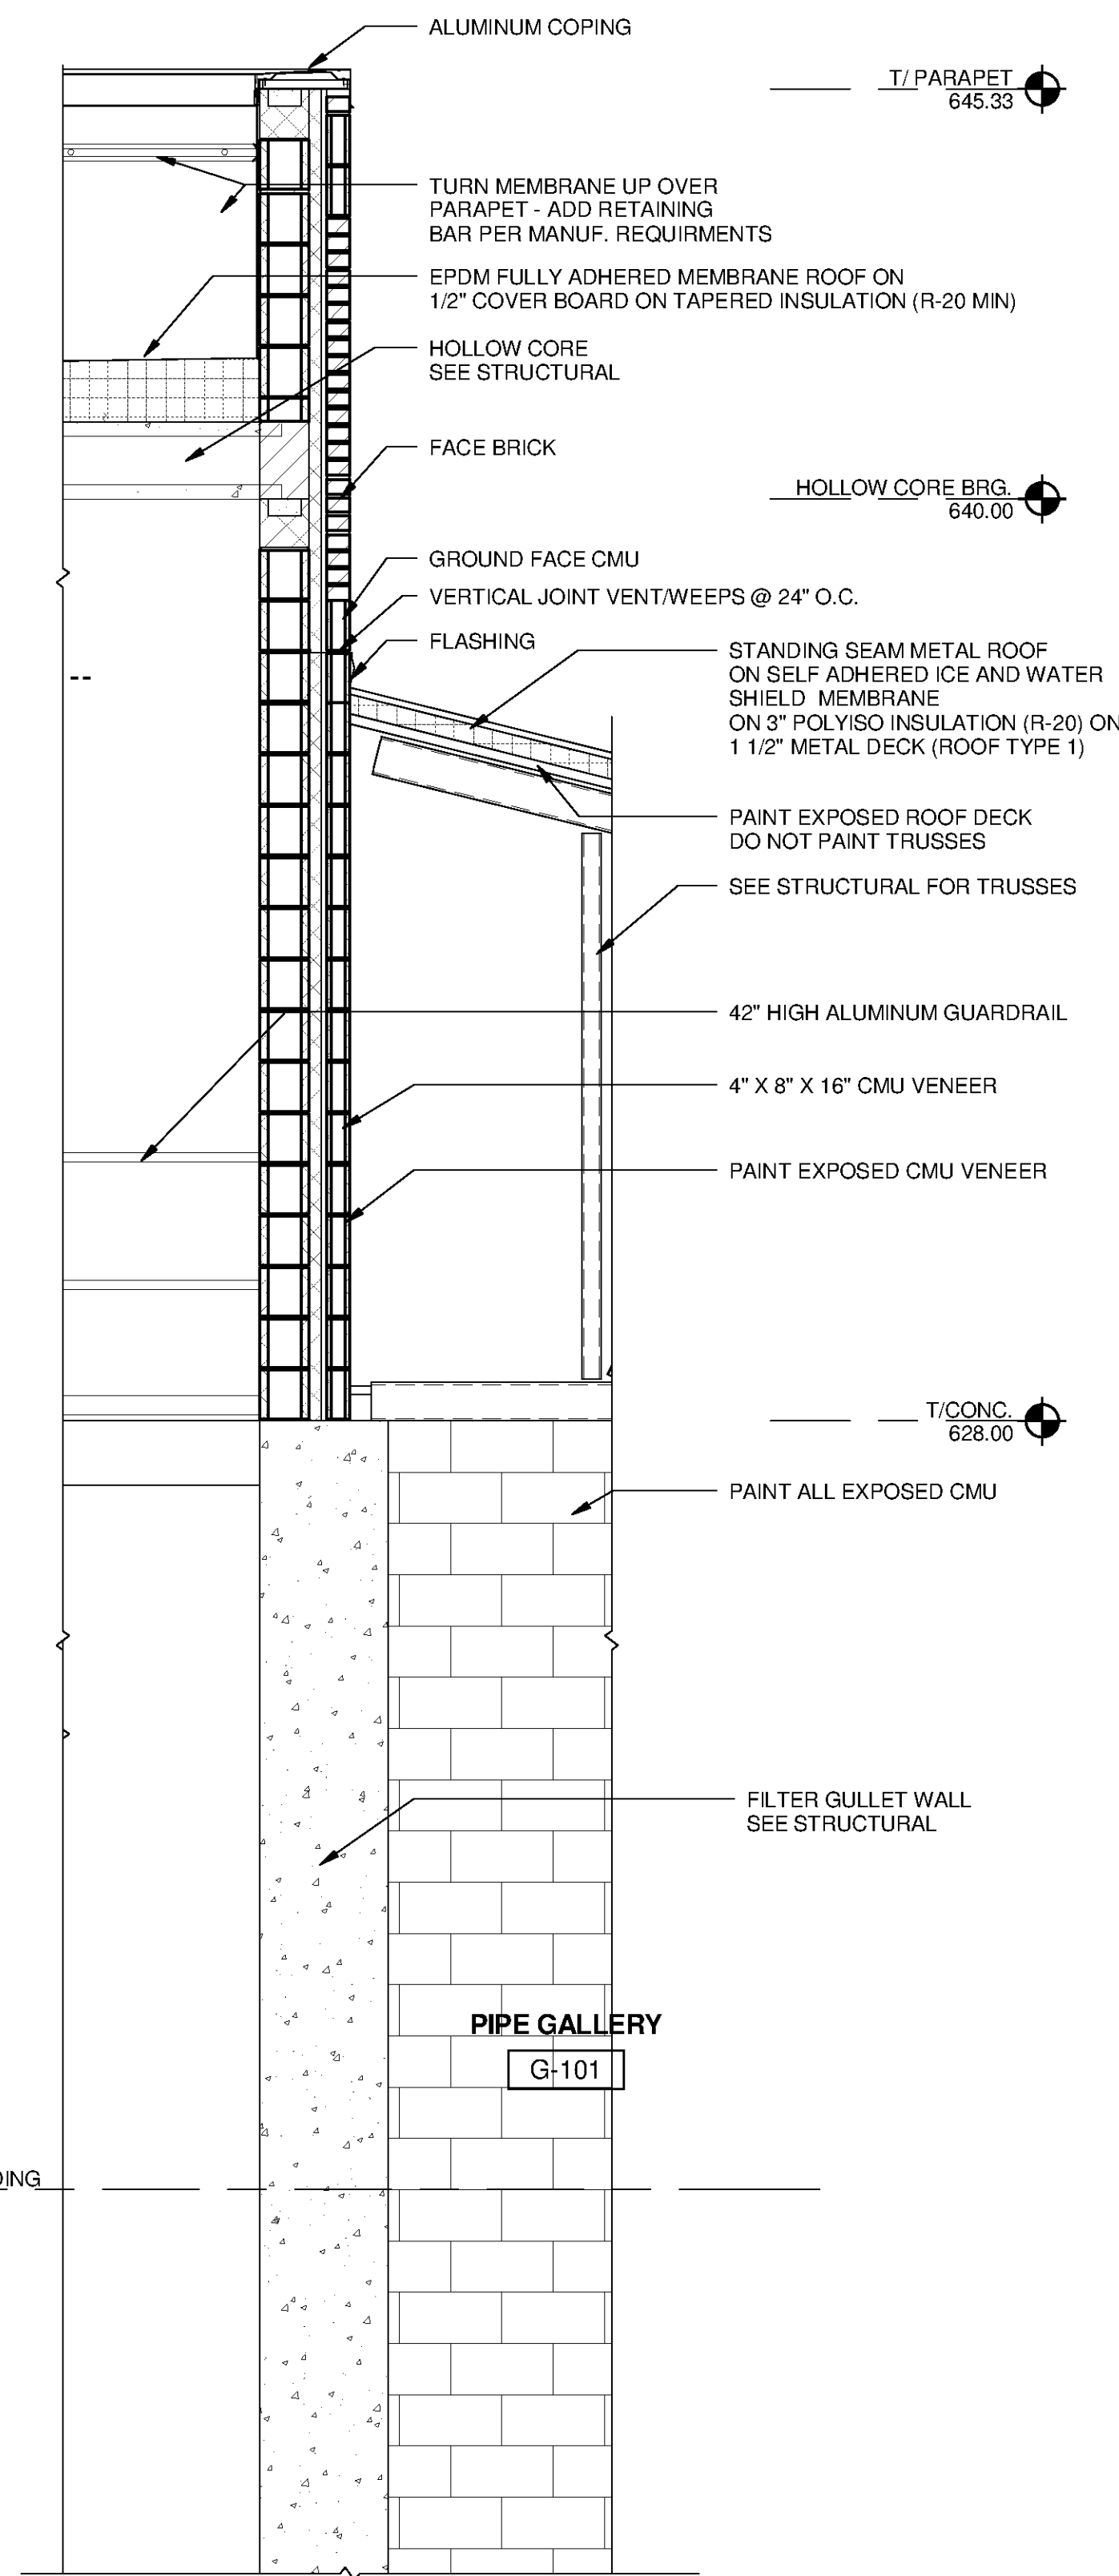

**2 WALL SECTION**  
A-3202 SCALE: 1/2" = 1'-0"

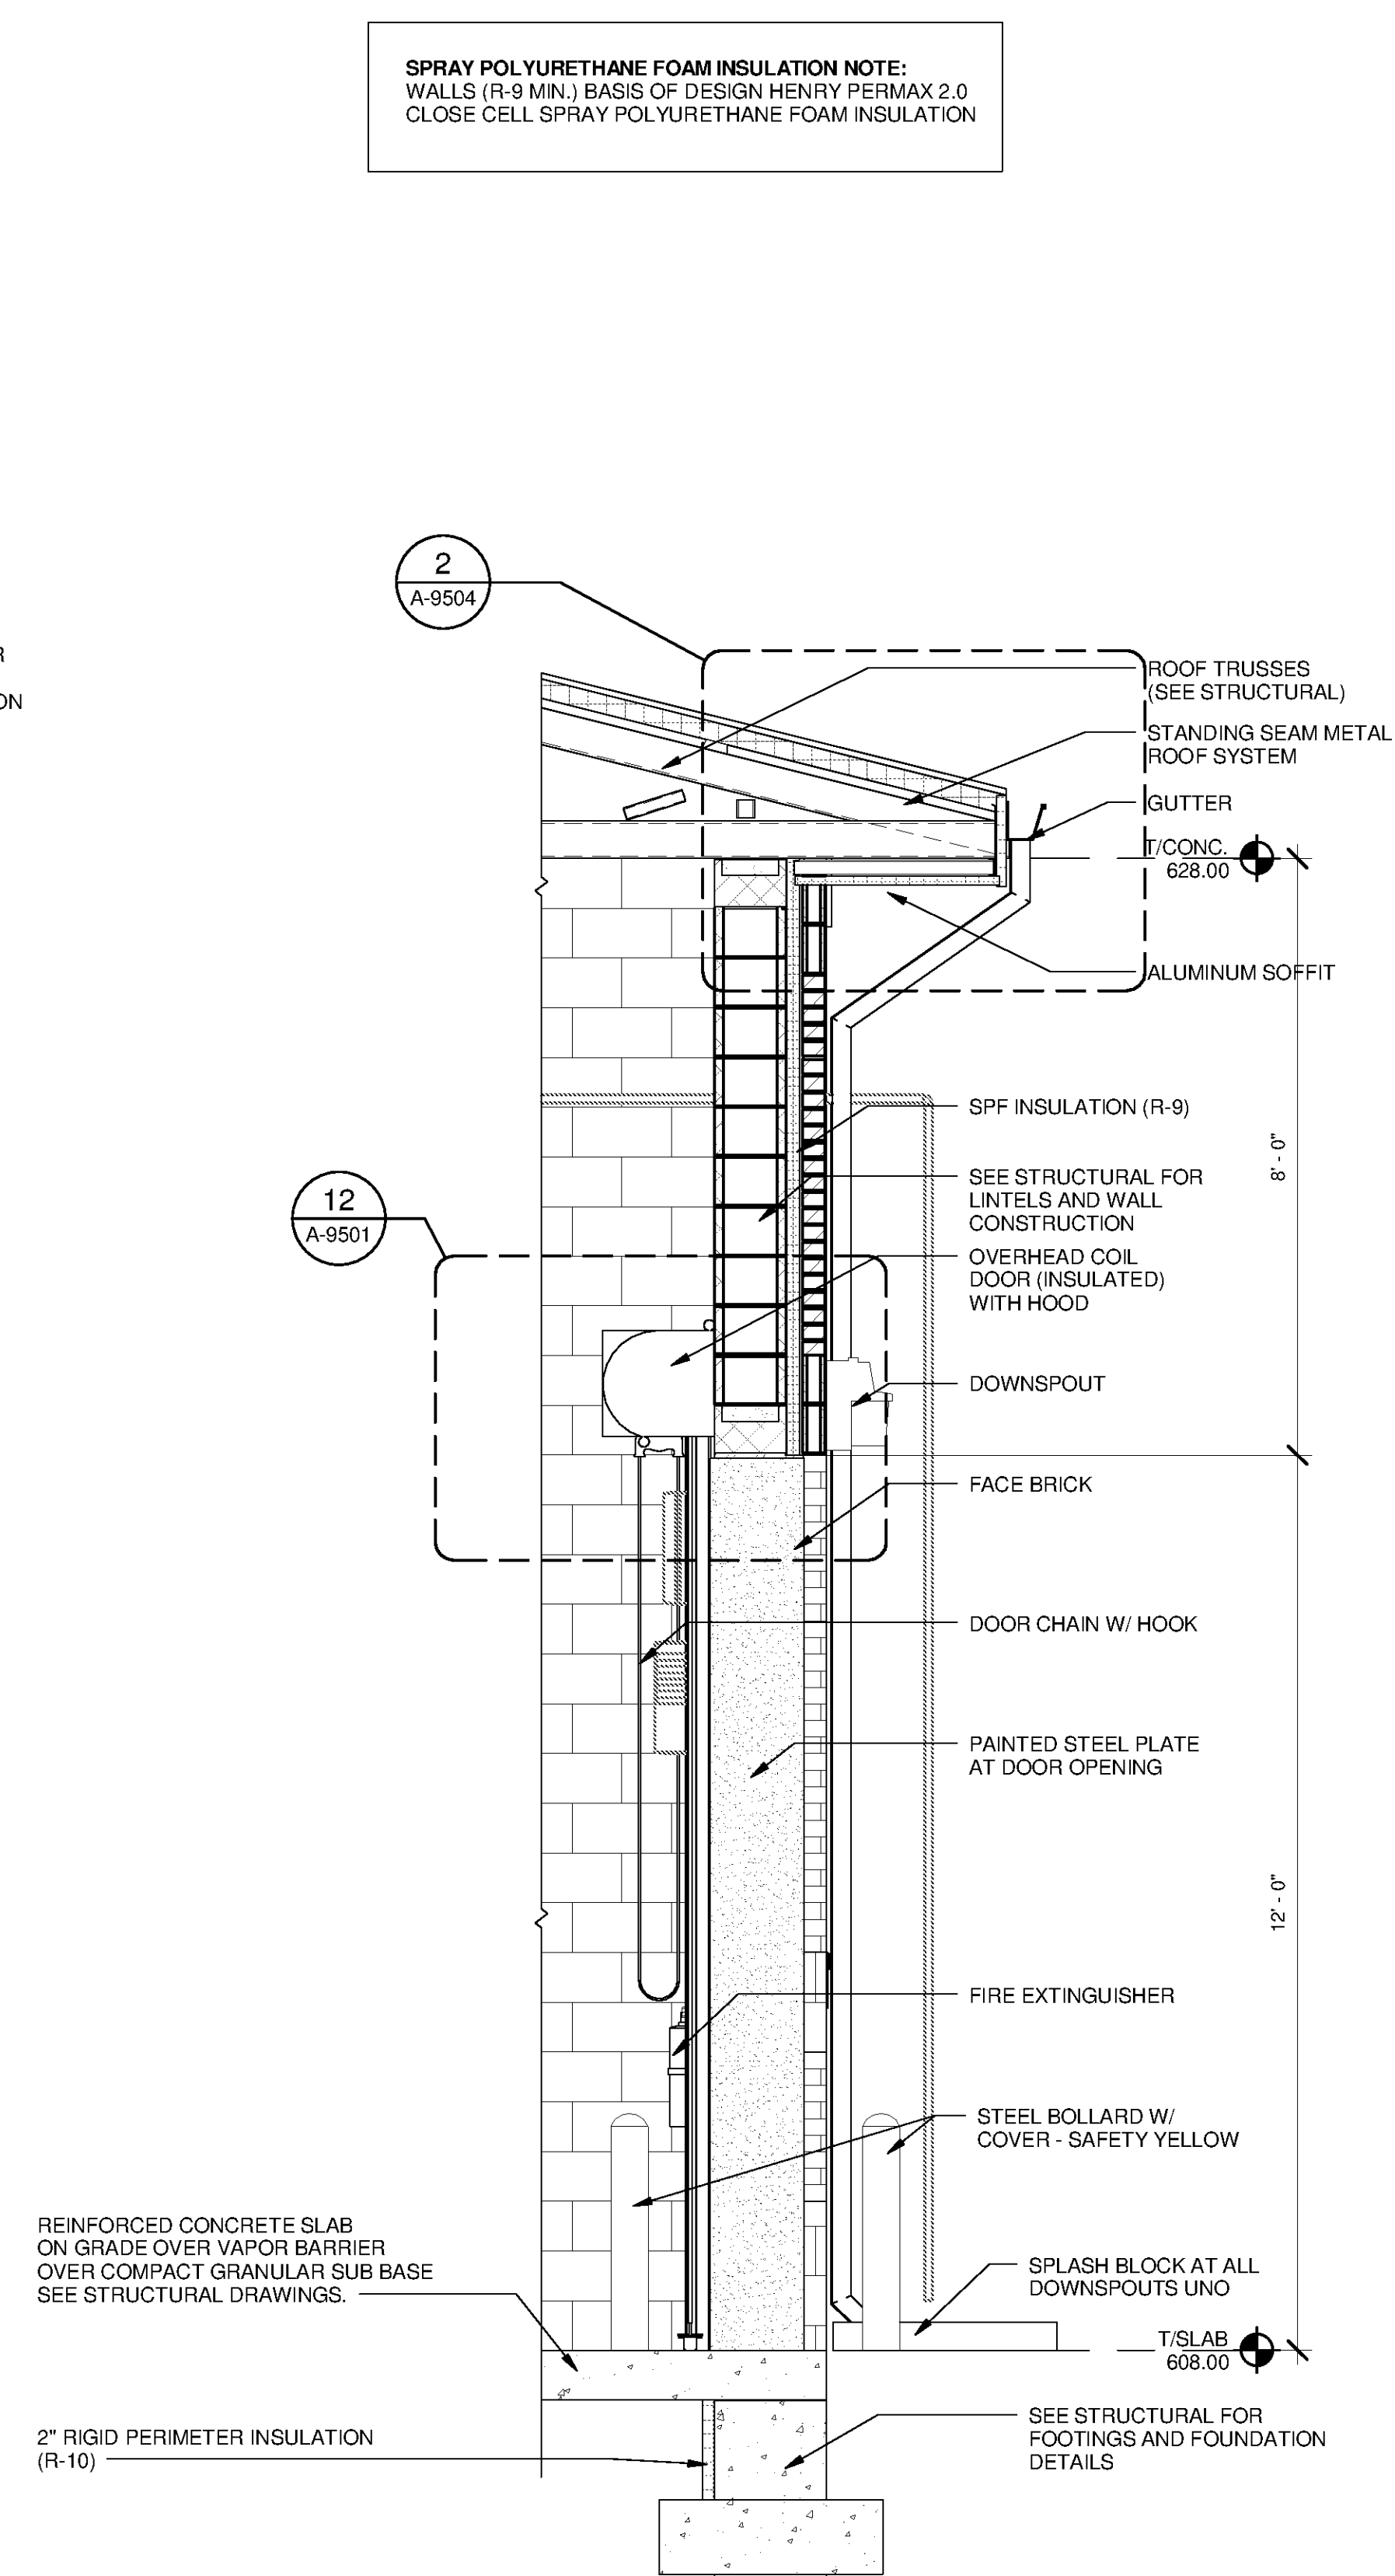

**1 WALL SECTION**  
A-3202 SCALE: 1/2" = 1'-0"

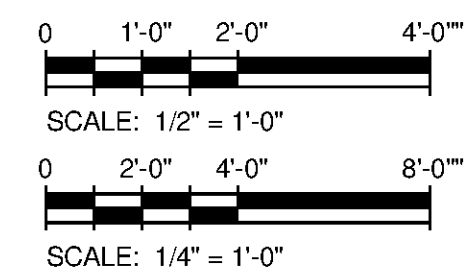

MARK	DATE	DESCRIPTION	BY

HUNTSVILLE UTILITIES  
SOUTHEAST WATER TREATMENT PLANT  
GAC/BAC FILTRATION  
BUILDING ARCHITECTURAL  
WALL SECTIONS

Project No.: 200-11740-10003  
Designed By: Q.BIAGI  
Drawn By: Q.BIAGI  
Checked By: D.GALANTE

**A-3302**