



9/30/2014 1:55:29 PM C:\Users\brent.lbx\Documents\WTF-11740-GENATR-Central_brent.lbx.rvt

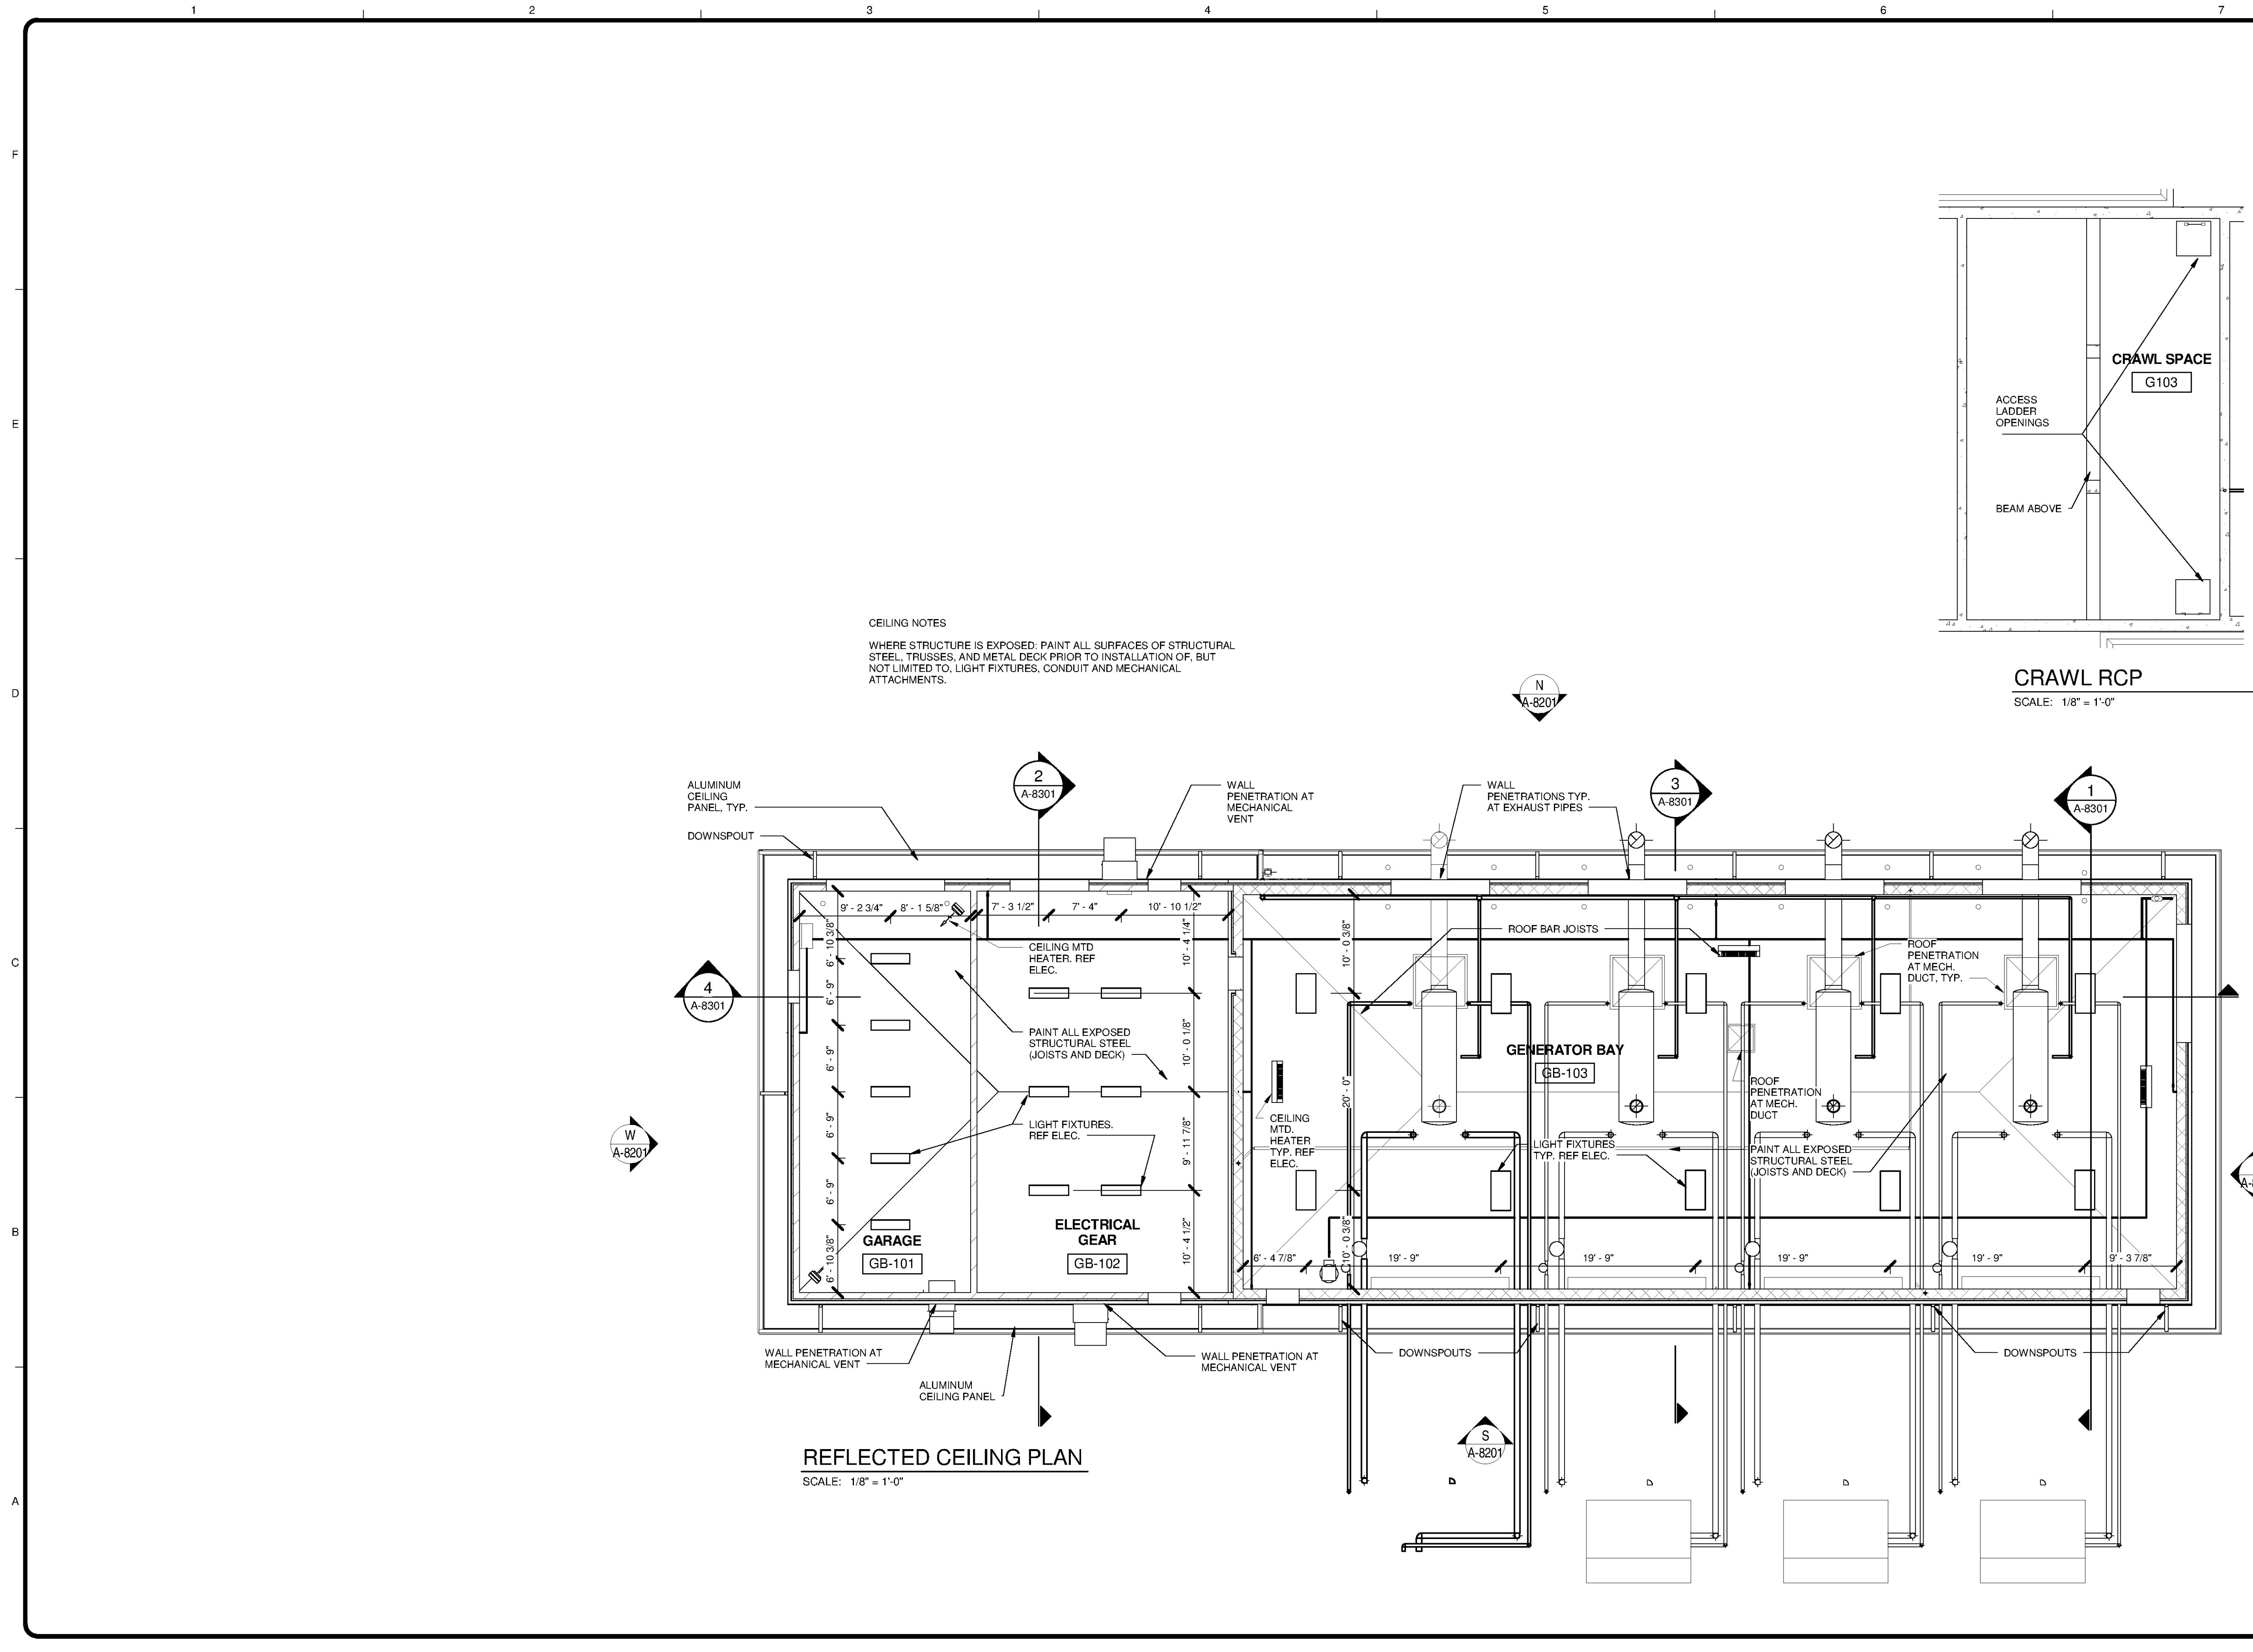

CEILING NOTES
 WHERE STRUCTURE IS EXPOSED, PAINT ALL SURFACES OF STRUCTURAL STEEL, TRUSSES, AND METAL DECK PRIOR TO INSTALLATION OF, BUT NOT LIMITED TO, LIGHT FIXTURES, CONDUIT AND MECHANICAL ATTACHMENTS.

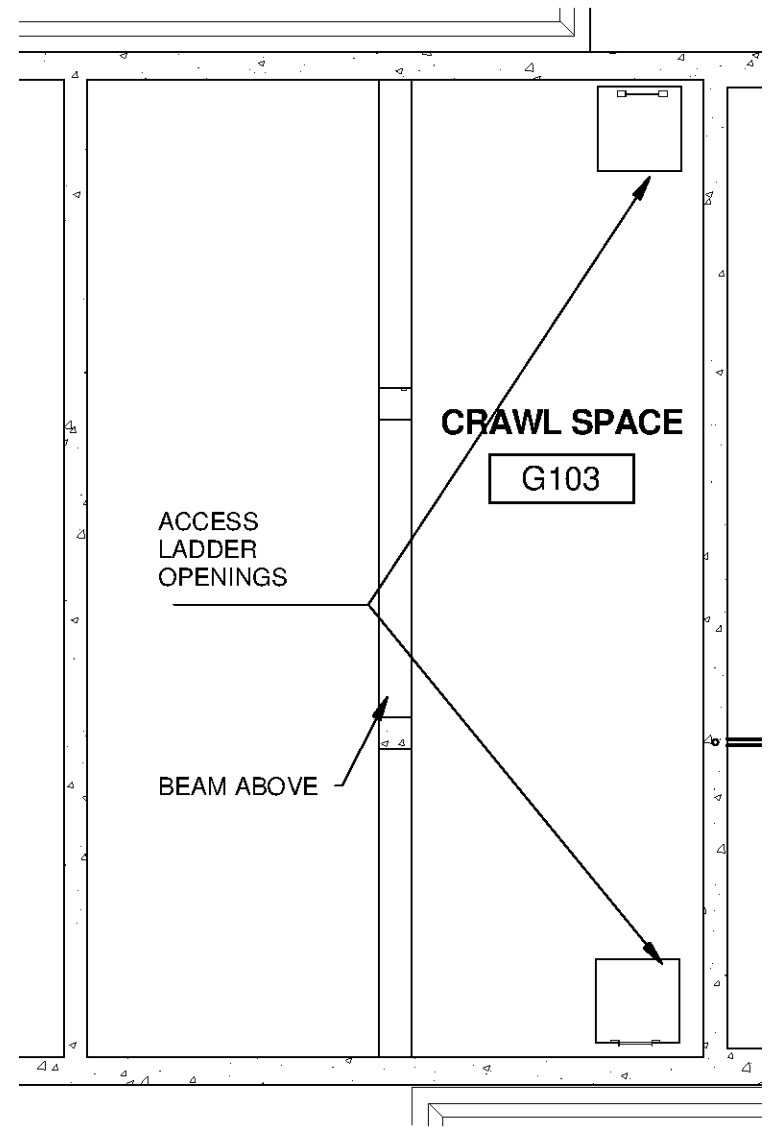

CRAWL RCP
 SCALE: 1/8" = 1'-0"

REFLECTED CEILING PLAN
 SCALE: 1/8" = 1'-0"



MARK	DATE	DESCRIPTION	BY

HUNTSVILLE UTILITIES
 SOUTHEAST WATER TREATMENT PLANT
**GENERATOR BUILDING
 CEILING PLAN**

Project No.: 200-11740-10003
 Designed By: Designer
 Drawn By: Author
 Checked By: Checker

A-8104

Bar Measures 1 Inch

Copyright Tetra Tech