

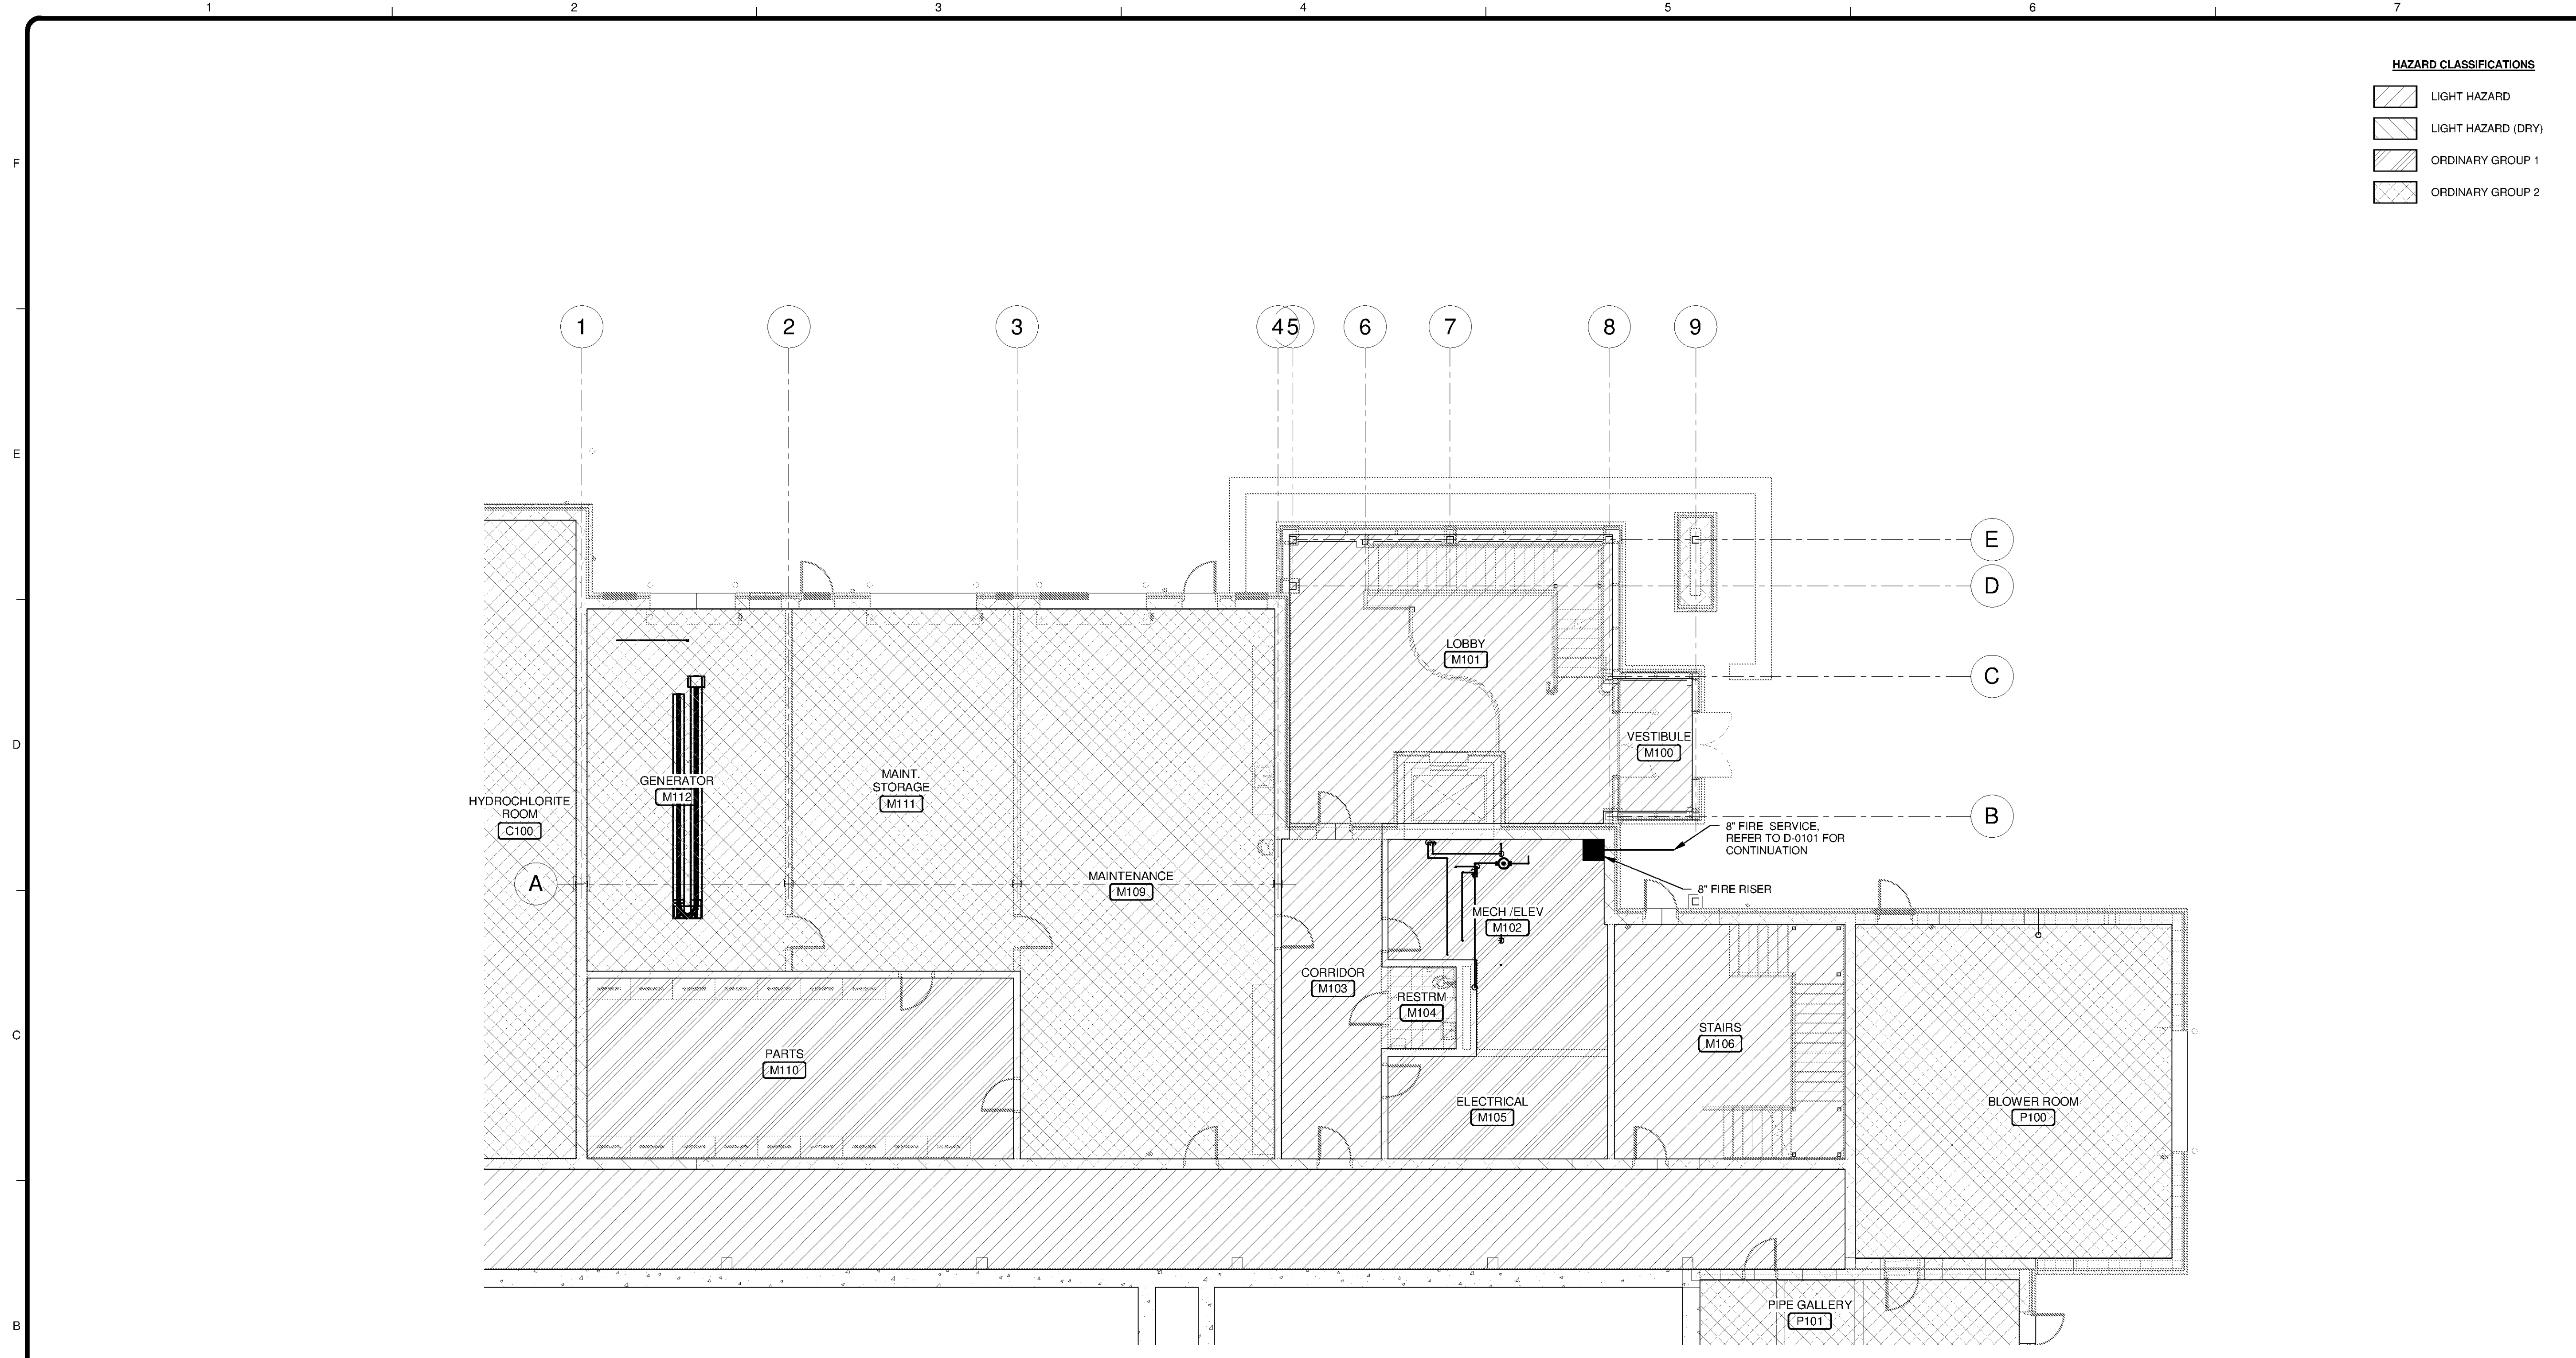


10/1/2014 4:45:23 PM C:\Users\madison.leffler\Documents\WTP-11740-M-MAIN\PP_madison.leffler.rvt

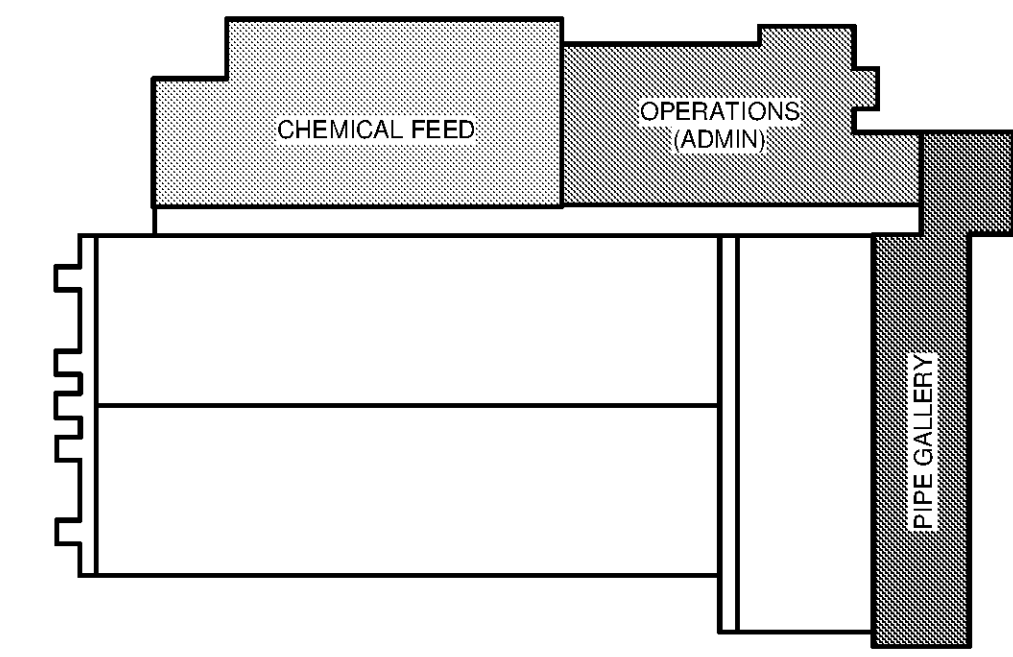

- HAZARD CLASSIFICATIONS**
- LIGHT HAZARD
 - LIGHT HAZARD (DRY)
 - ORDINARY GROUP 1
 - ORDINARY GROUP 2

OPERATIONS FIRST FLOOR FIRE PROTECTION PLAN
 SCALE: 1/8" = 1'-0"

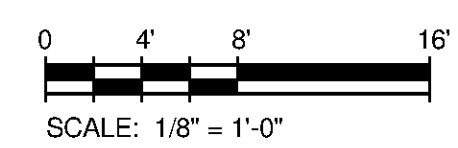

KEY PLAN

TETRA TECH
 www.tetra-tech.com
 101 QUALITY CIRCLE, SUITE 140
 HUNTSVILLE, ALABAMA 35895
 PHONE: (256) 424-4077 FAX: (256) 424-4087

BID SET

MARK	DATE	DESCRIPTION	BY

HUNTSVILLE UTILITIES
 SOUTHEAST WATER TREATMENT PLANT
**MAIN PROCESS BUILDING
 OPERATIONS FIRST FLOOR
 FIRE PROTECTION**

Project No.: 200-11740-10003
 Designed By: JWM
 Drawn By: JWM
 Checked By: DSB

F-2101