





C:\Users\madison.leffler\Documents\WTP-11740-M-MAIN\PP madison.leffler.rvt

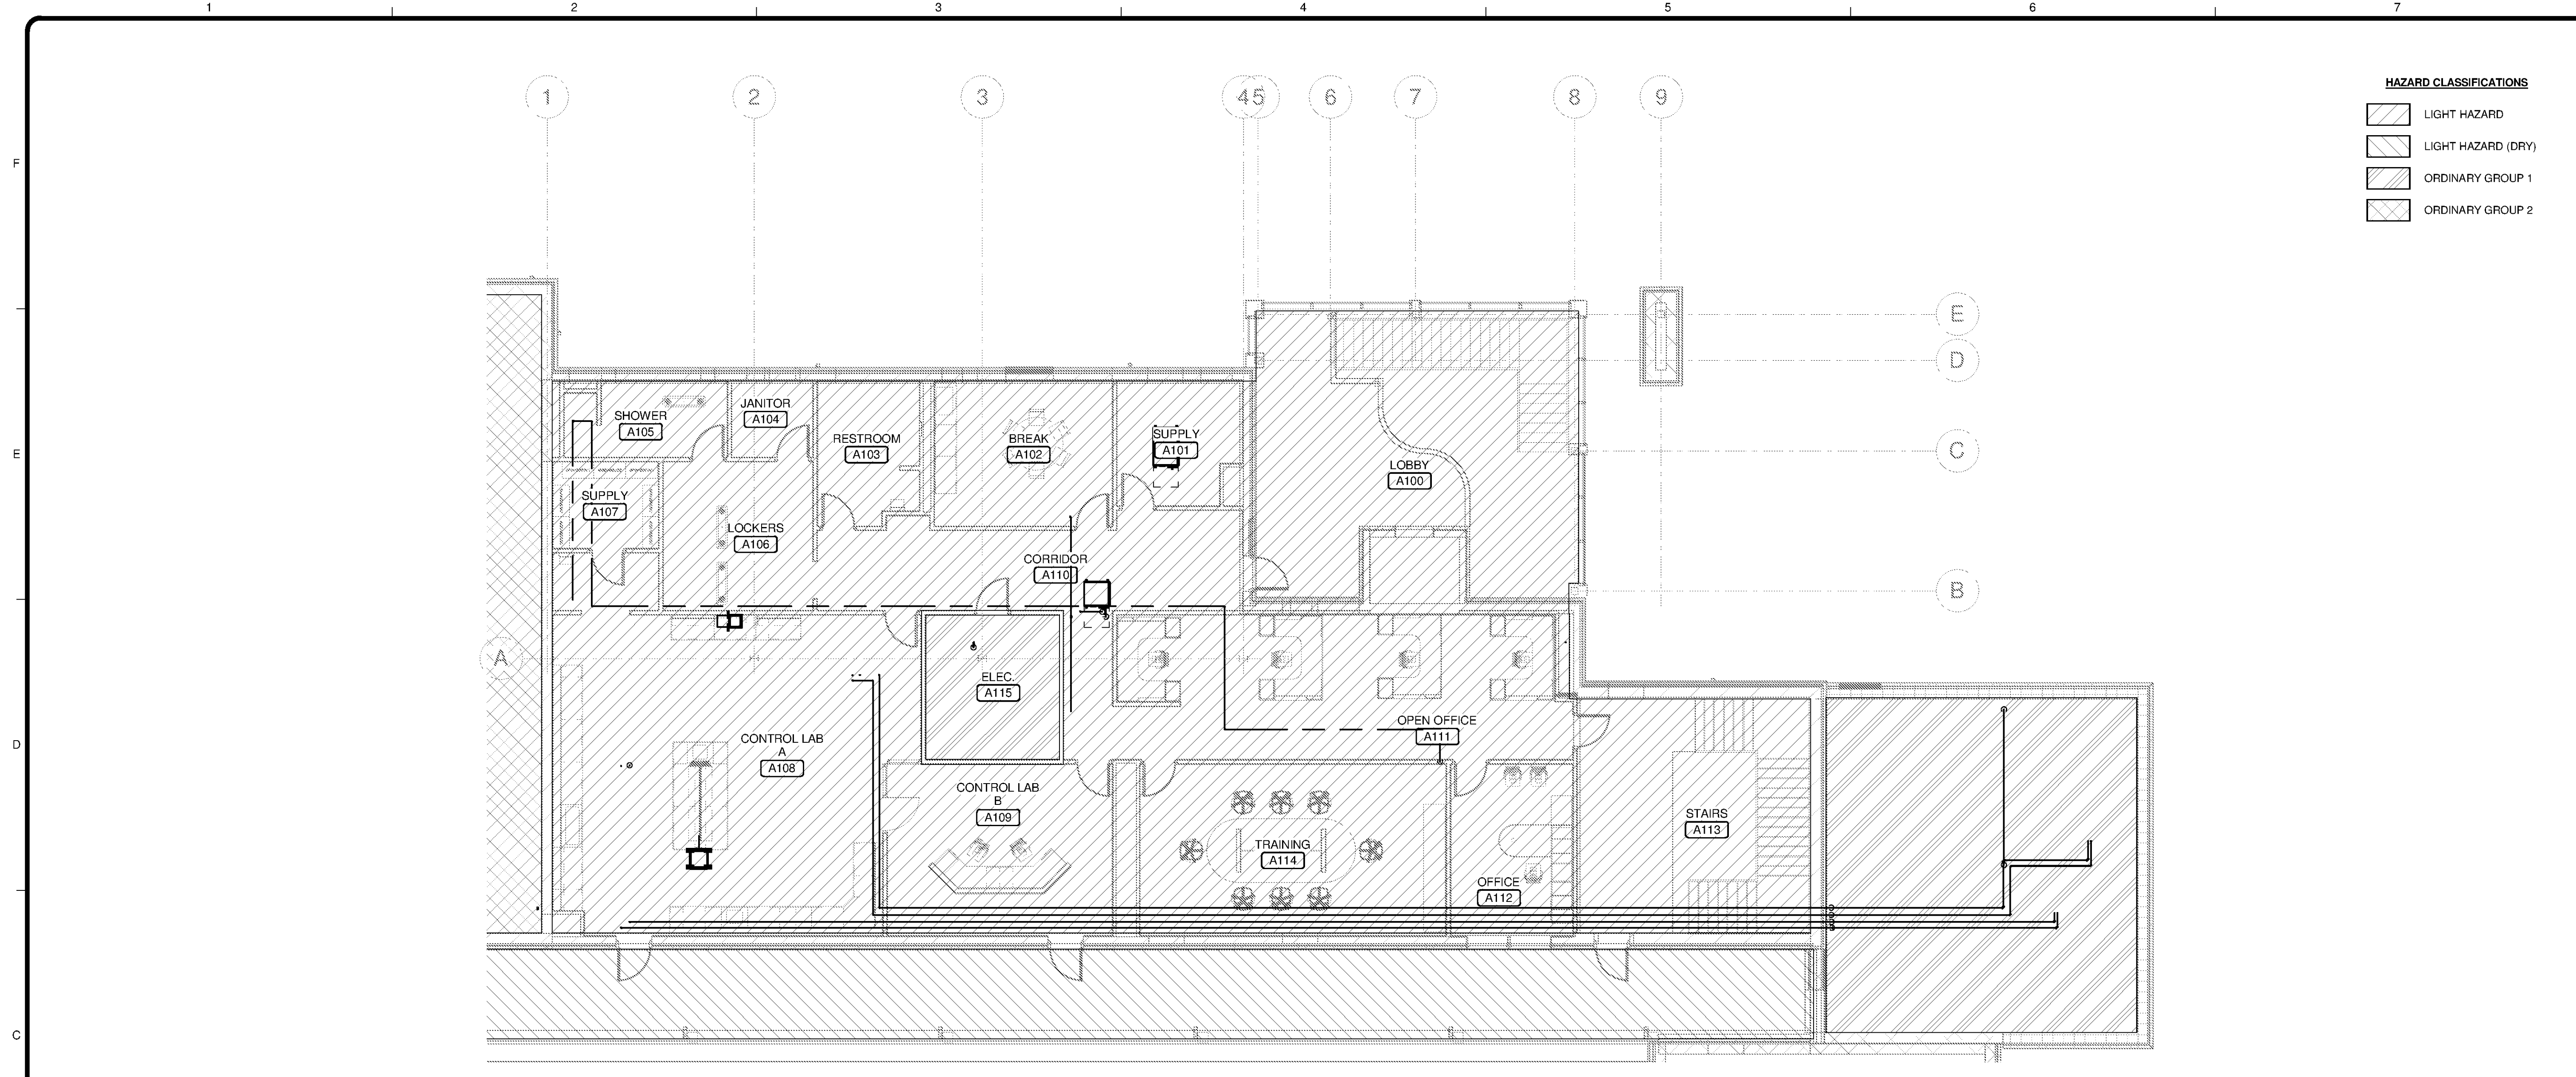



- HAZARD CLASSIFICATIONS**
- LIGHT HAZARD
 - LIGHT HAZARD (DRY)
 - ORDINARY GROUP 1
 - ORDINARY GROUP 2

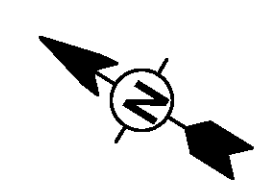

OPERATIONS SECOND FLOOR FIRE PROTECTION PLAN
SCALE: 1/8" = 1'-0"

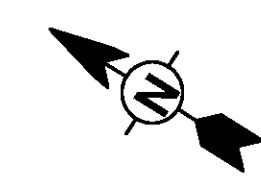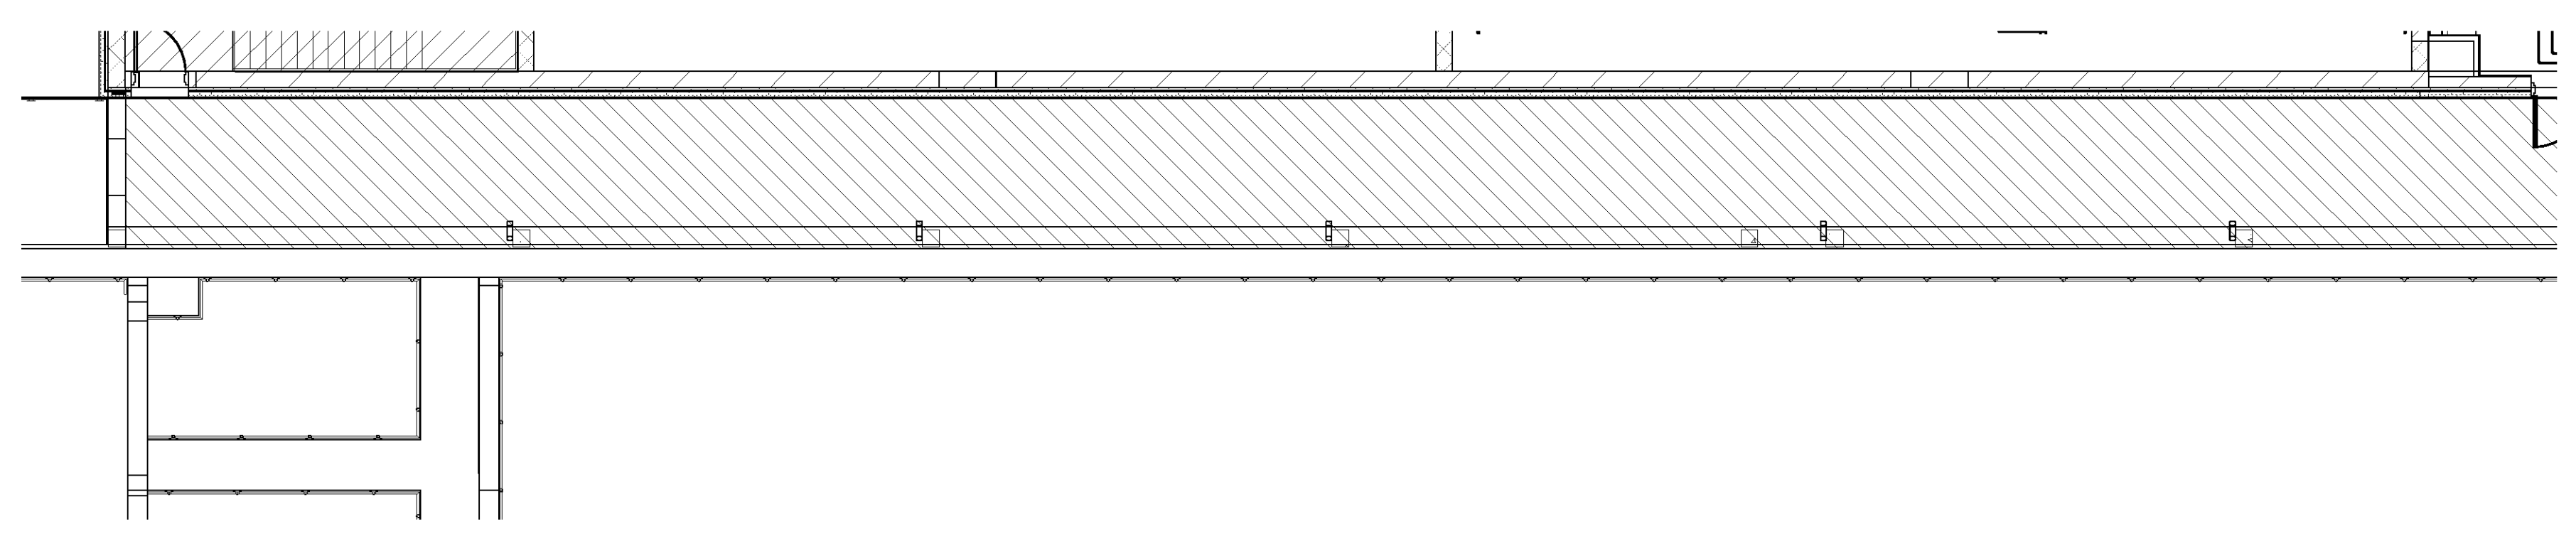

CHEMICAL FEED SECOND FLOOR FIRE PROTECTION PLAN
SCALE: 1/8" = 1'-0"

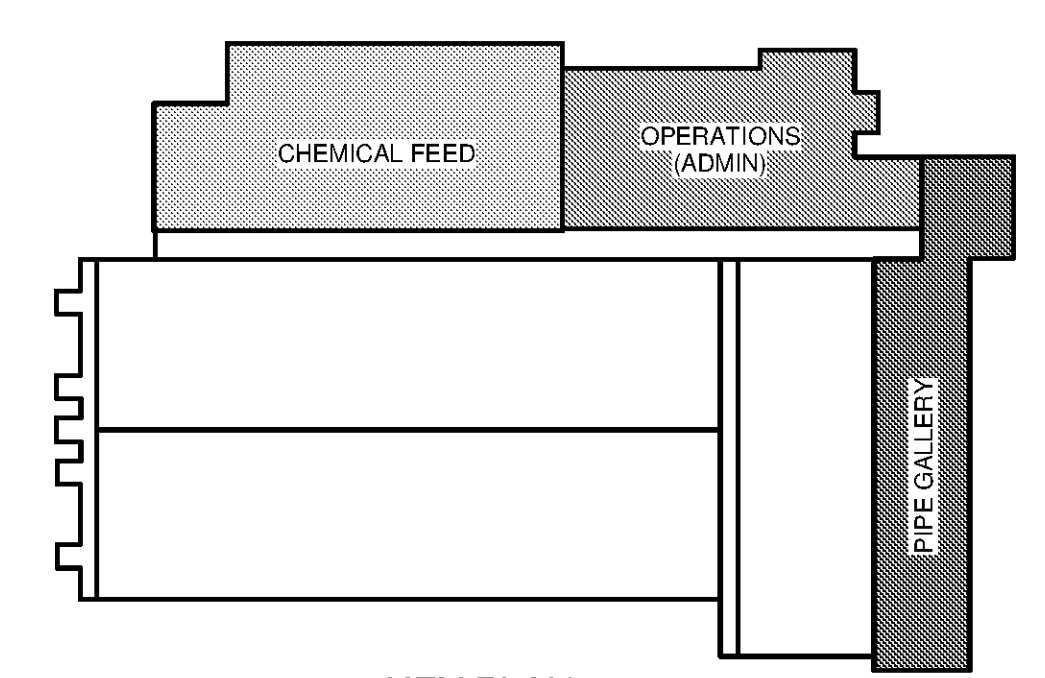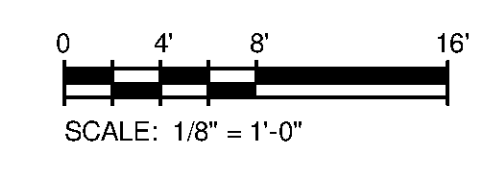

TETRA TECH

www.tetrattech.com
101 QUALITY CIRCLE, SUITE 140
HUNTSVILLE, ALABAMA 35895
PHONE: (256) 424-4077 FAX: (256) 424-4087

BID SET

BY	DATE	DESCRIPTION

HUNTSVILLE UTILITIES
SOUTHEAST WATER TREATMENT PLANT

**MAIN PROCESS BUILDING
OPERATIONS SECOND
FLOOR FIRE PROTECTION**

Project No.: 200-11740-10003
Designed By: JWM
Drawn By: JWM
Checked By: DSB

F-2102

Copyright: Tetra Tech
Bar Measures 1 Inch