

 
 

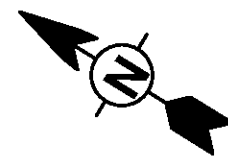




C:\Users\madison.leffler\Documents\WTP-11740-M-MAIN\PP_madison.leffler.rvt



- HAZARD CLASSIFICATIONS**
-  LIGHT HAZARD
 -  LIGHT HAZARD (DRY)
 -  ORDINARY GROUP 1
 -  ORDINARY GROUP 2

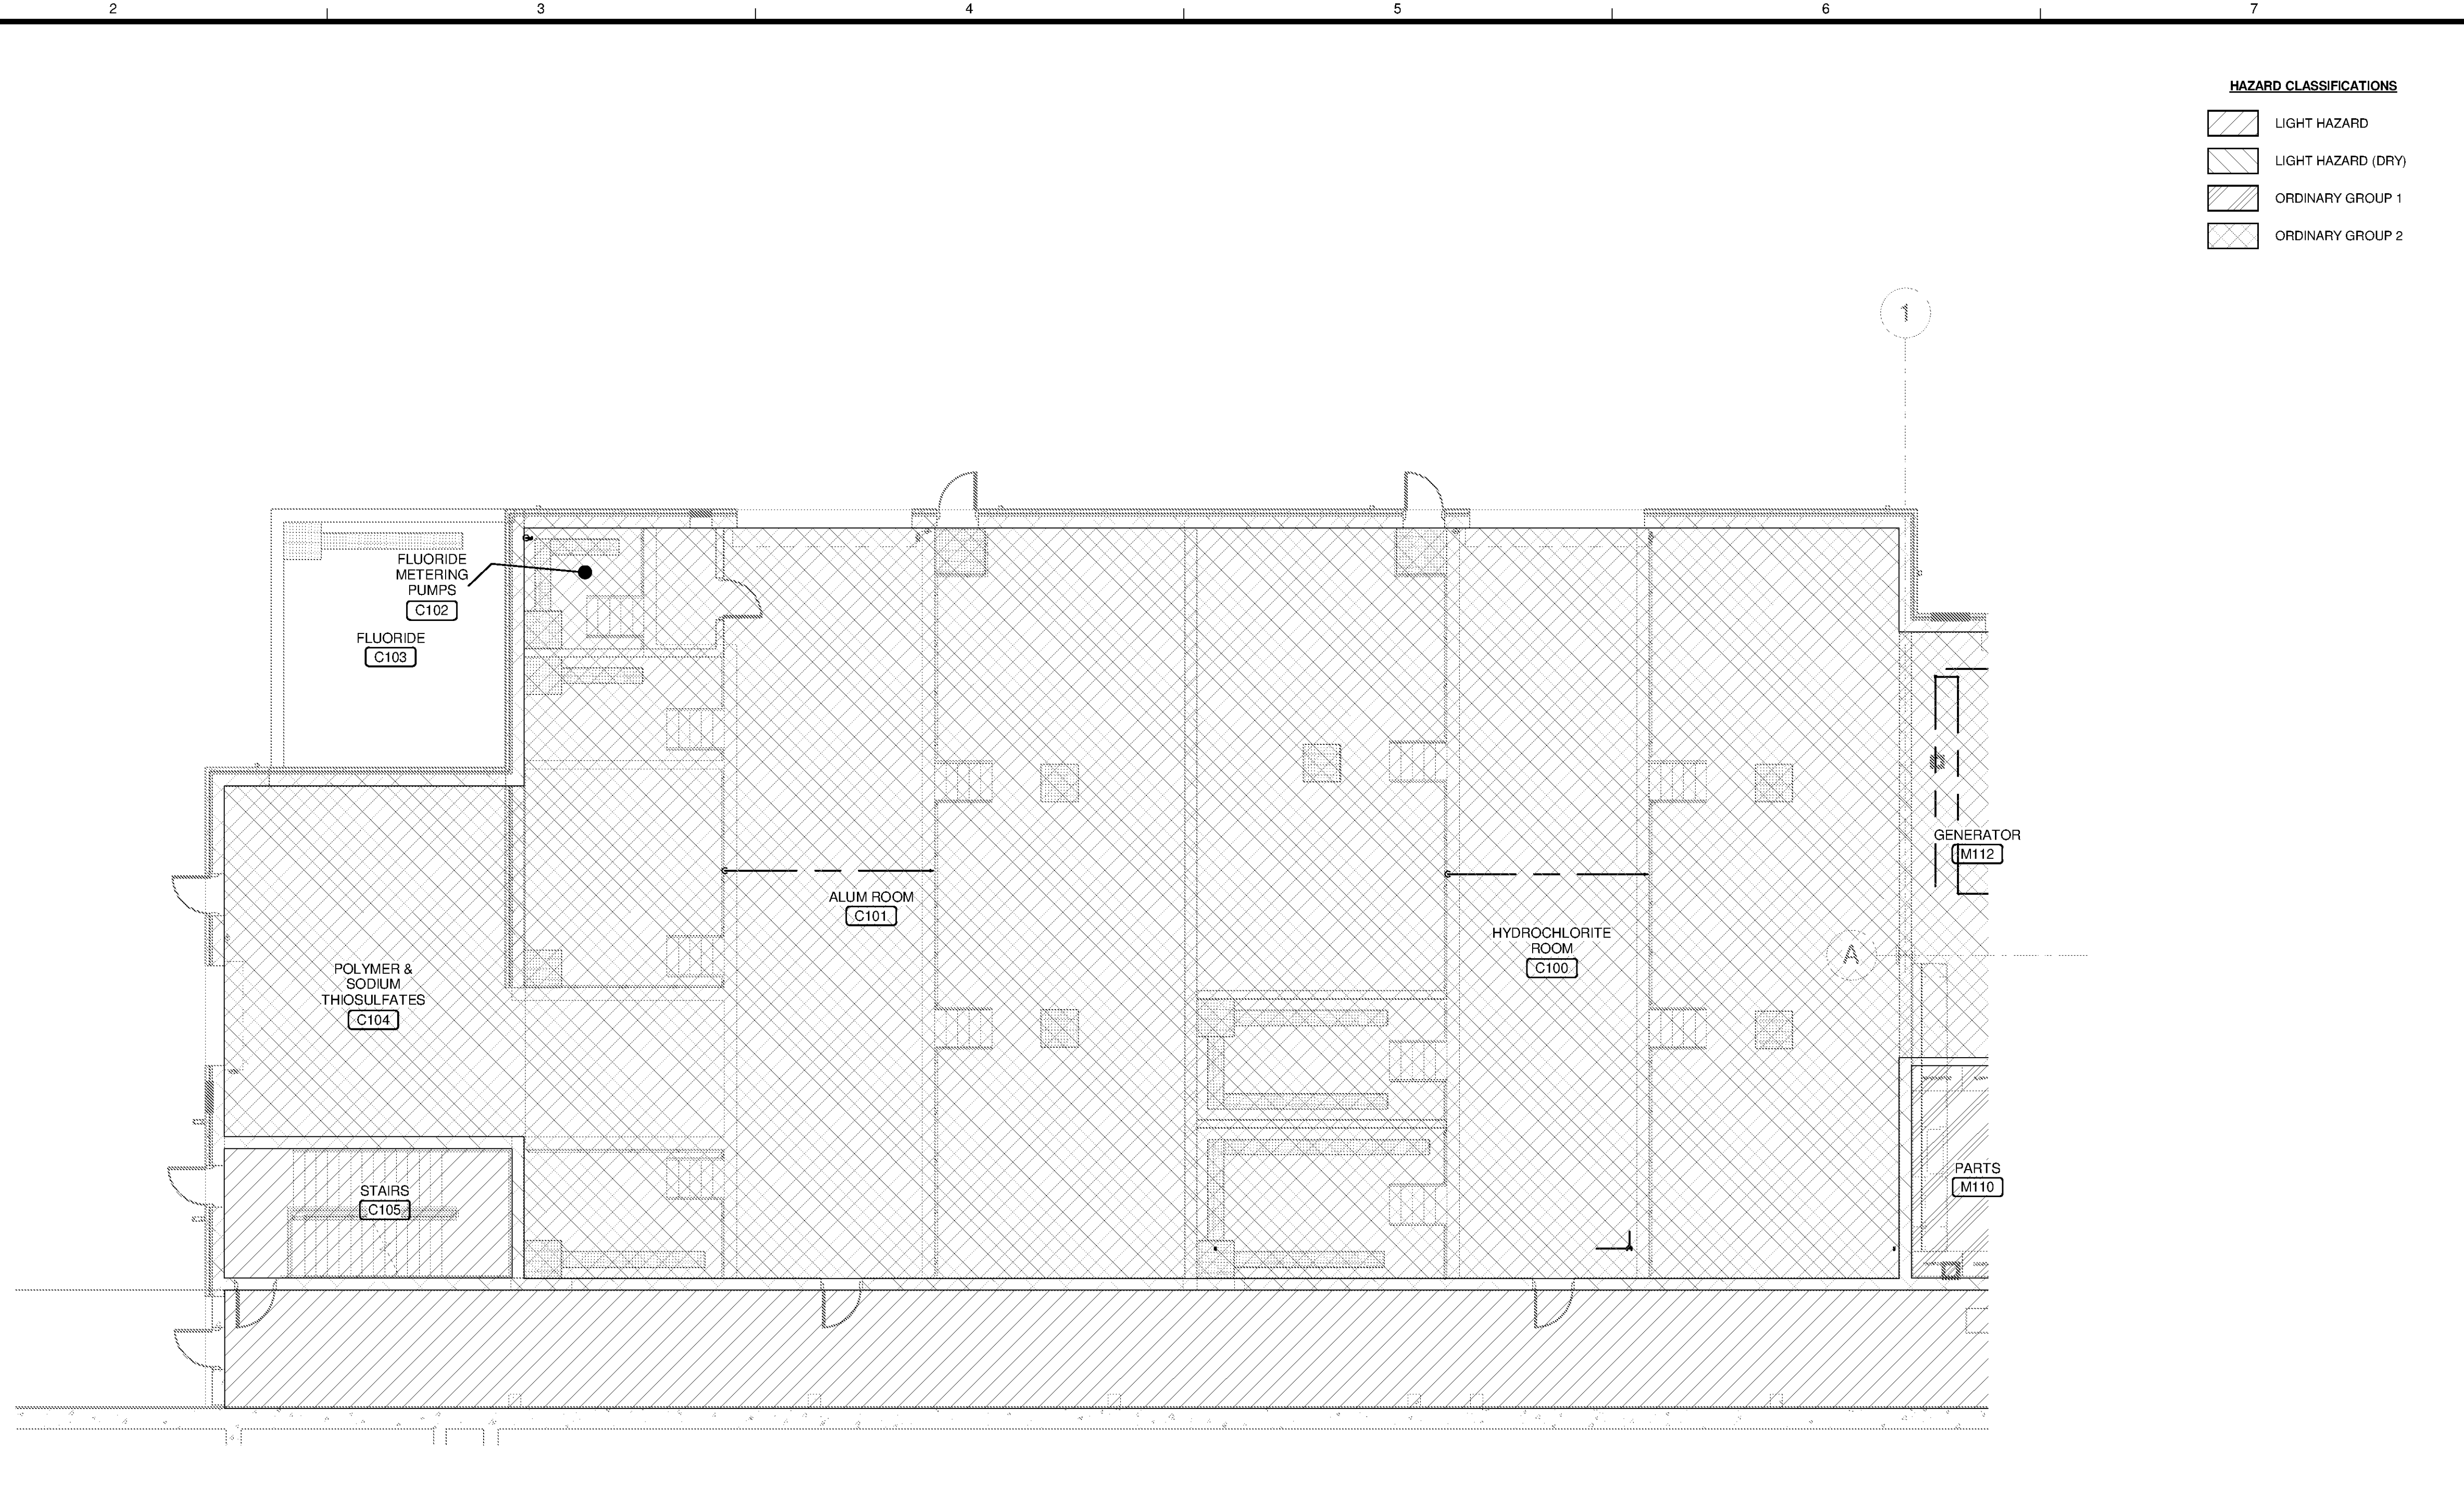

CHEMICAL FEED FIRE PROTECTION PLAN
SCALE: 1/8" = 1'-0"

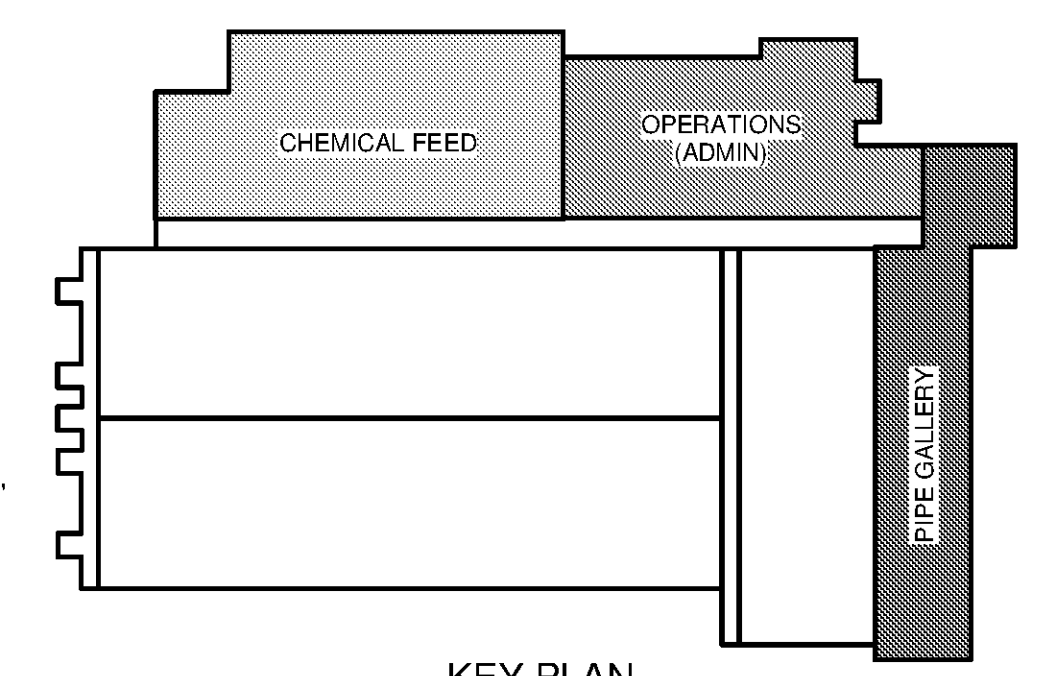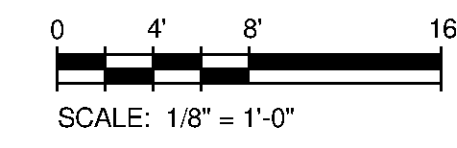


KEY PLAN

TETRA TECH

www.tetra-tech.com
101 QUALITY CIRCLE, SUITE 140
HUNTSVILLE, ALABAMA 35806
PHONE: (256) 424-4077 FAX: (256) 424-4087

BID SET

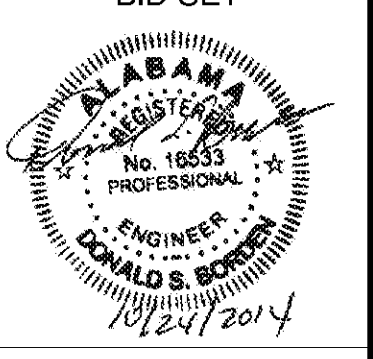

BY	DATE	MARK	DESCRIPTION

HUNTSVILLE UTILITIES

SOUTHEAST WATER TREATMENT PLANT

MAIN PROCESS BUILDING

CHEMICAL FEED FIRE

PROTECTION

Project No.: 200-11740-10003
Designed By: JWM
Drawn By: JWM
Checked By: DSB

F-2103

Copyright Tetra Tech
Bar Measures 1 Inch