


- HAZARD CLASSIFICATIONS**
- LIGHT HAZARD
 - LIGHT HAZARD (DRY)
 - ORDINARY GROUP 1
 - ORDINARY GROUP 2

PIPE GALLERY FIRE PROTECTION PLAN
SCALE: 1/8" = 1'-0"

SCALE: 1/8" = 1'-0"

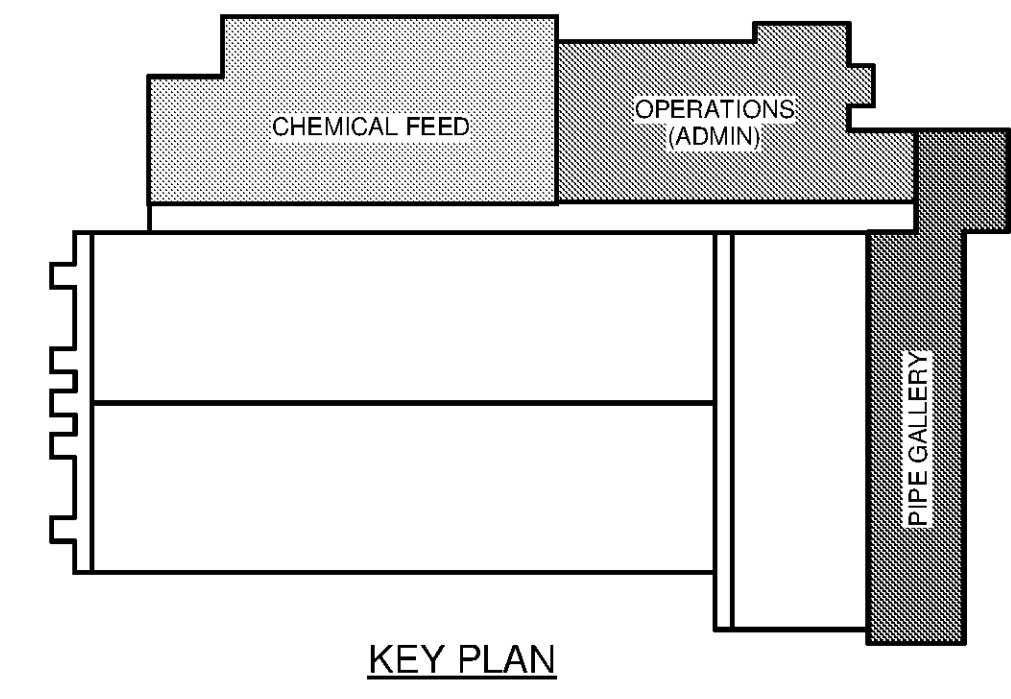

TETRA TECH
www.tetra.tech.com
101 QUALITY CIRCLE, SUITE 140
HUNTSVILLE, ALABAMA 35895
PHONE: (256) 424-4077 FAX: (256) 424-4087

BID SET

MARK	DATE	DESCRIPTION	BY

HUNTSVILLE UTILITIES
SOUTHEAST WATER TREATMENT PLANT
**MAIN PROCESS BUILDING
PIPE GALLERY FIRE
PROTECTION**

Project No.: 200-11740-10003
Designed By: JWM
Drawn By: JWM
Checked By: DSB

F-2104
Copyright Tetra Tech
Bar Measures 1 Inch