



10/1/2014 1:47:35 PM C:\Users\justin.marsh\Documents\WTP-11740-M-MAINPR\_justin.marsh.rvt

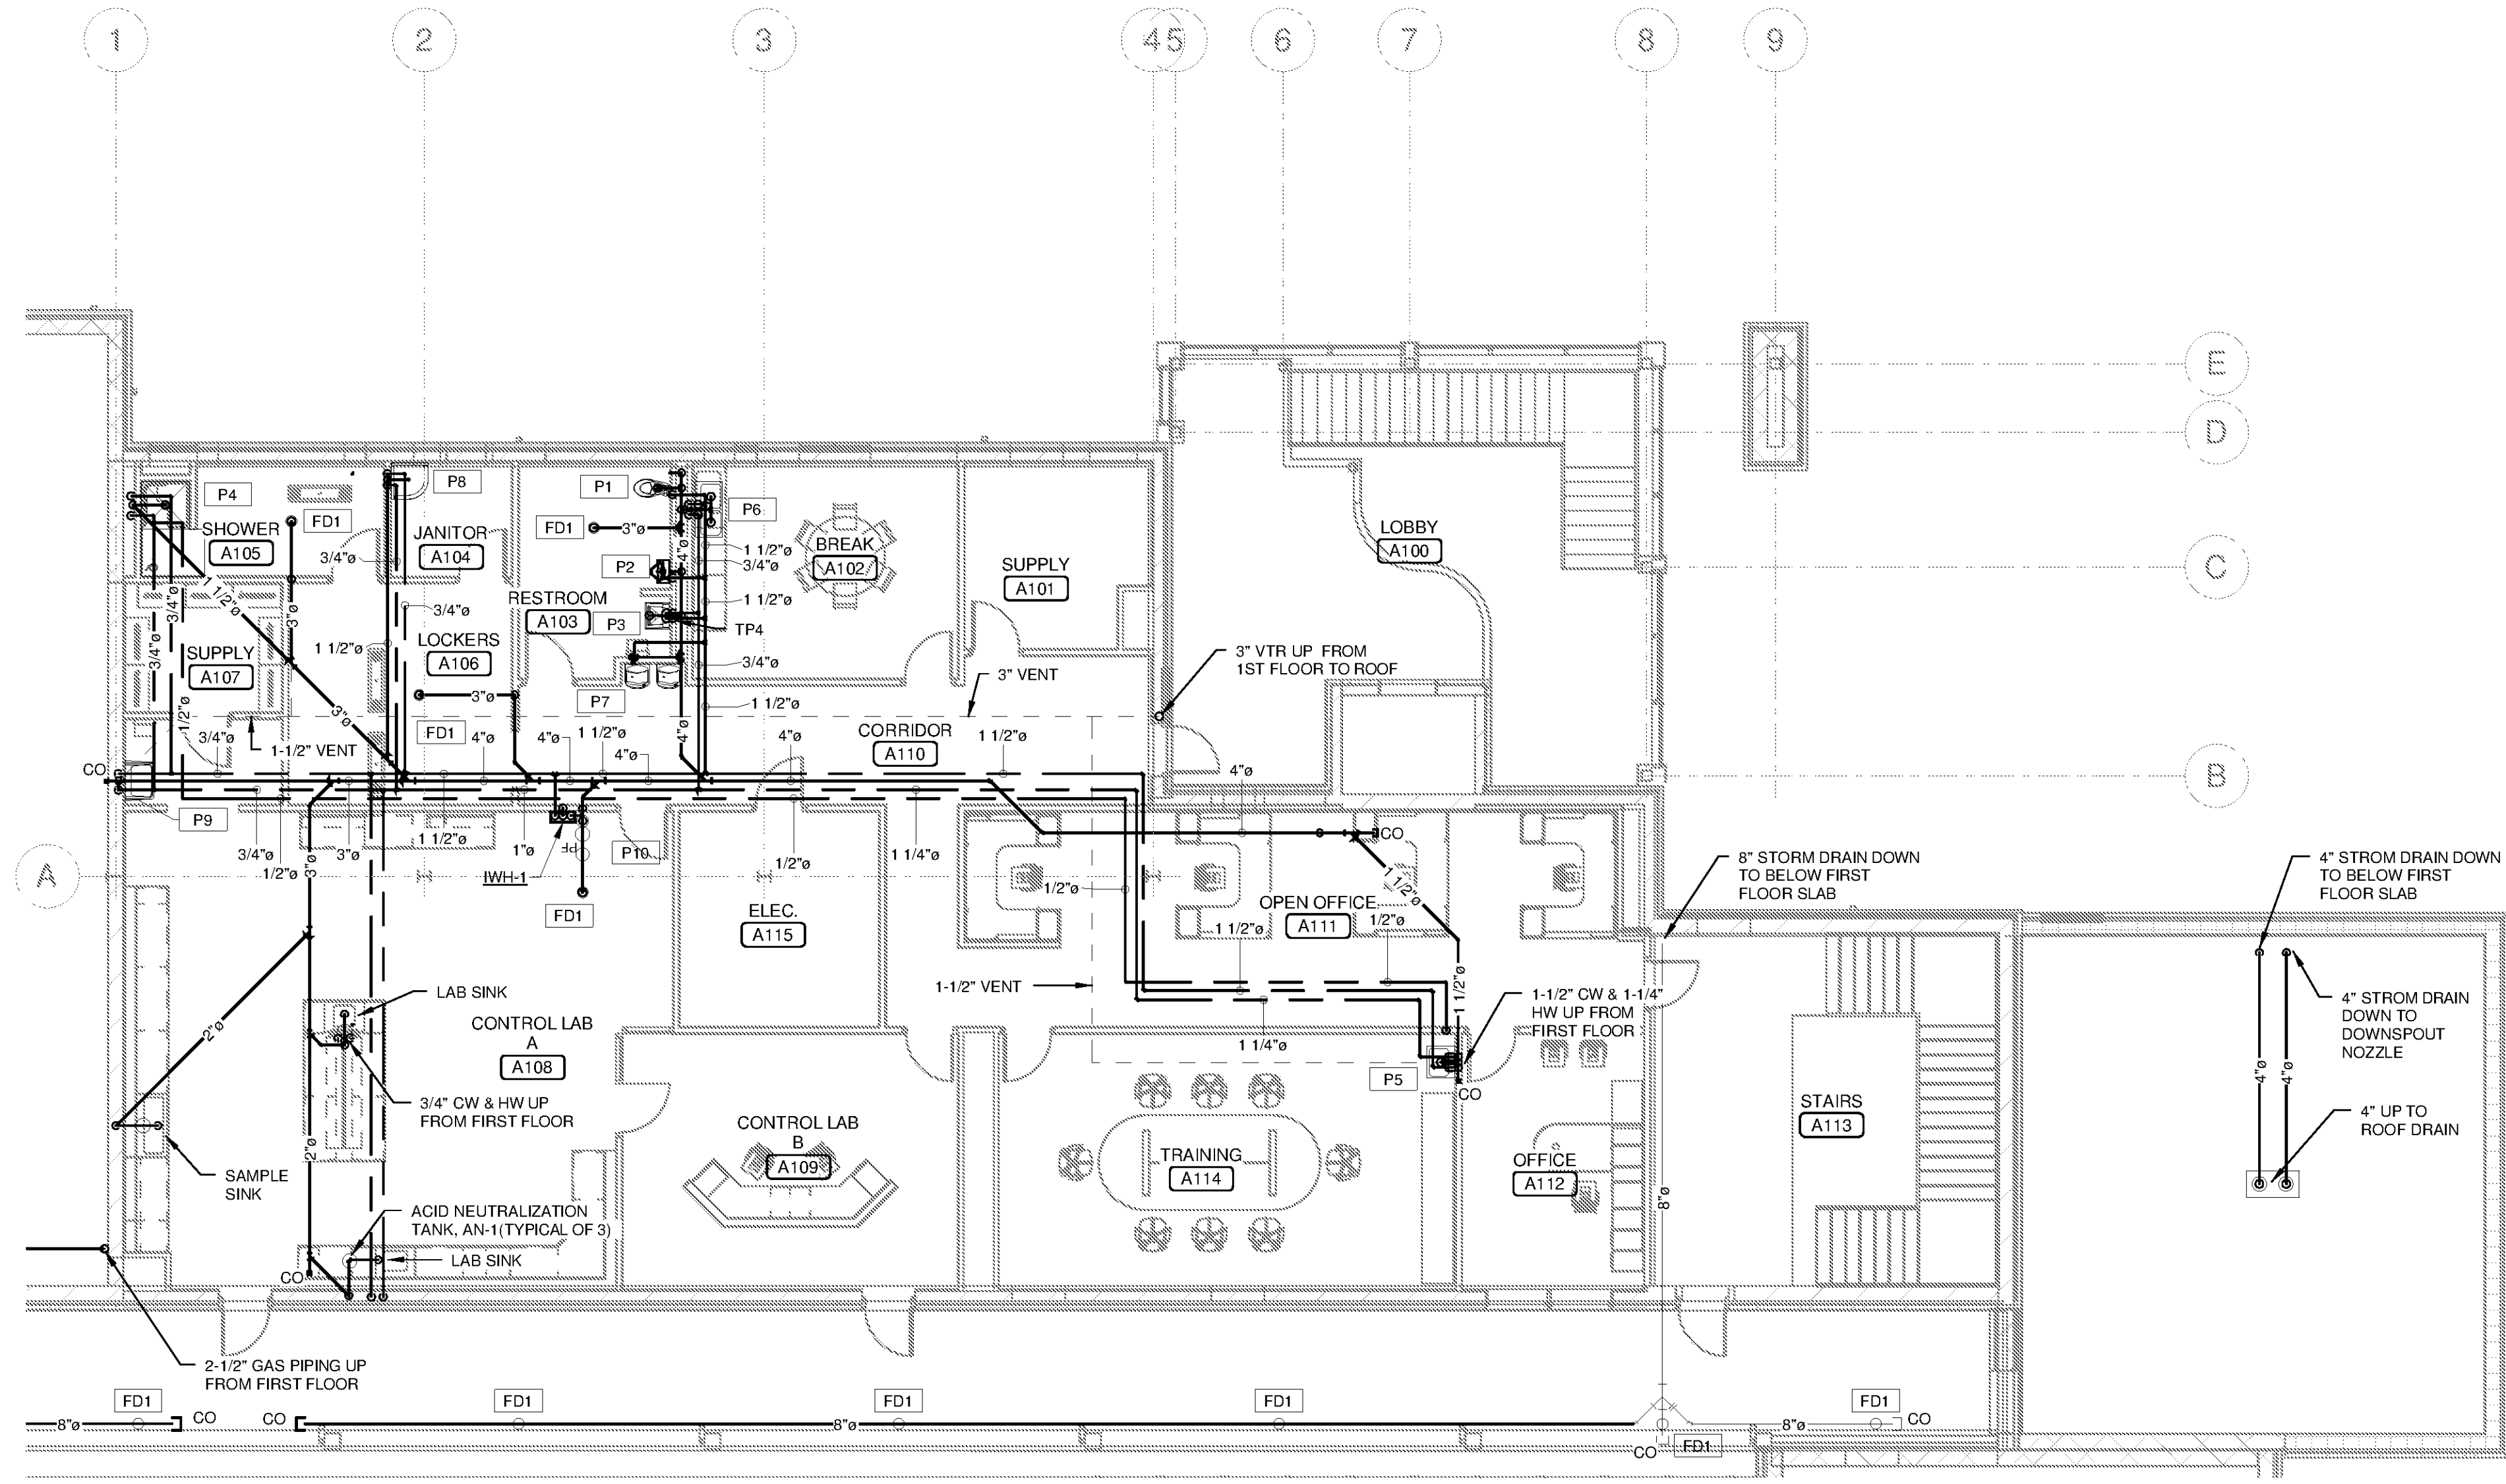



**OPERATIONS SECOND FLOOR PLUMBING PLAN**

SCALE: 1/8" = 1'-0"

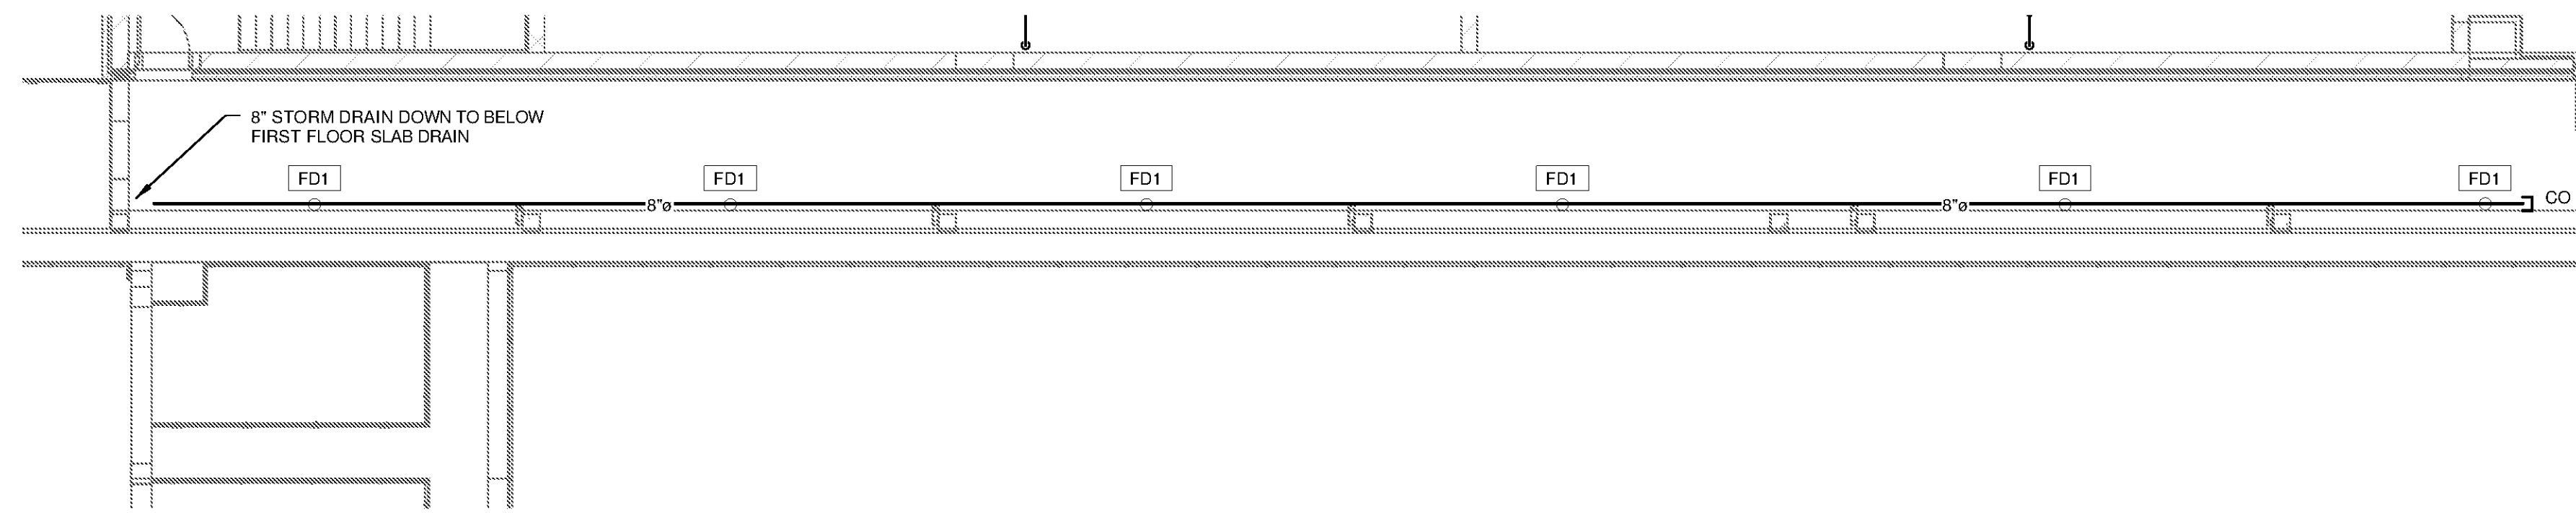


**CHEMICAL FEED SECOND FLOOR PLUMBING PLAN**

SCALE: 1/8" = 1'-0"

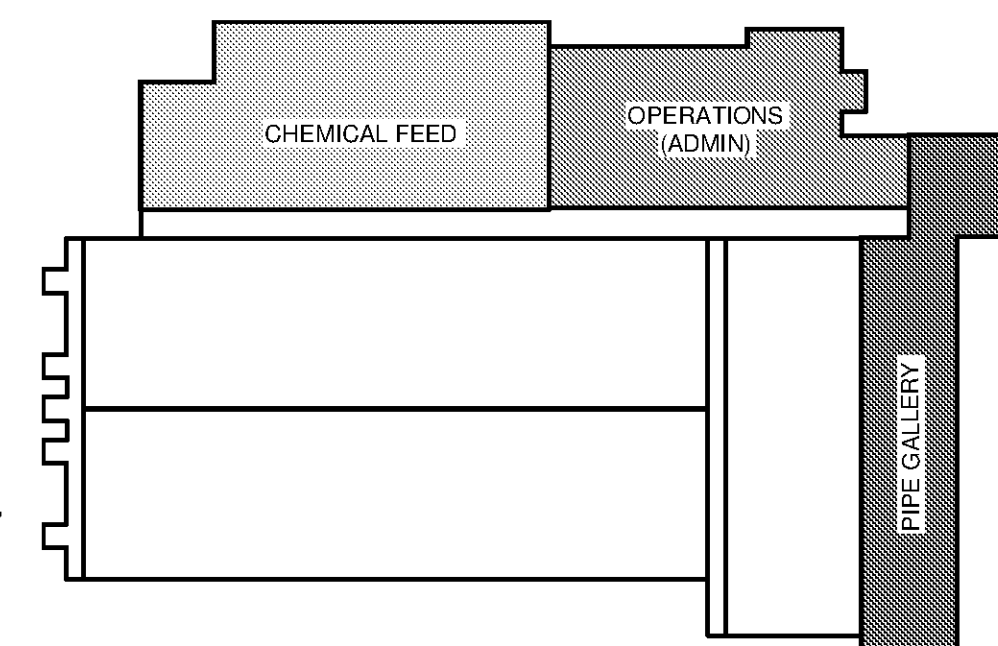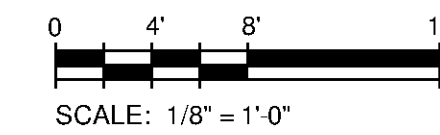

**KEY PLAN**

**TETRA TECH**

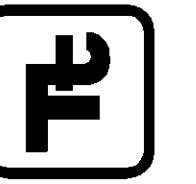

www.tetrattech.com  
101 QUALITY CIRCLE, SUITE 140  
HUNTSVILLE, ALABAMA 35896  
PHONE: (256) 424-4077 FAX: (256) 424-4097

BID SET



BY

DESCRIPTION

MARK DATE

HUNTSVILLE UTILITIES

SOUTHEAST WATER TREATMENT PLANT  
**MAIN PROCESS BUILDING  
OPERATIONS SECOND  
FLOOR PLUMBING PLAN**

Project No.: 200-11740-10003

Designed By: JWM

Drawn By: JWM

Checked By: DSB

**P-2102**

Copyright Tetra Tech  
Bar Measures 1 inch