

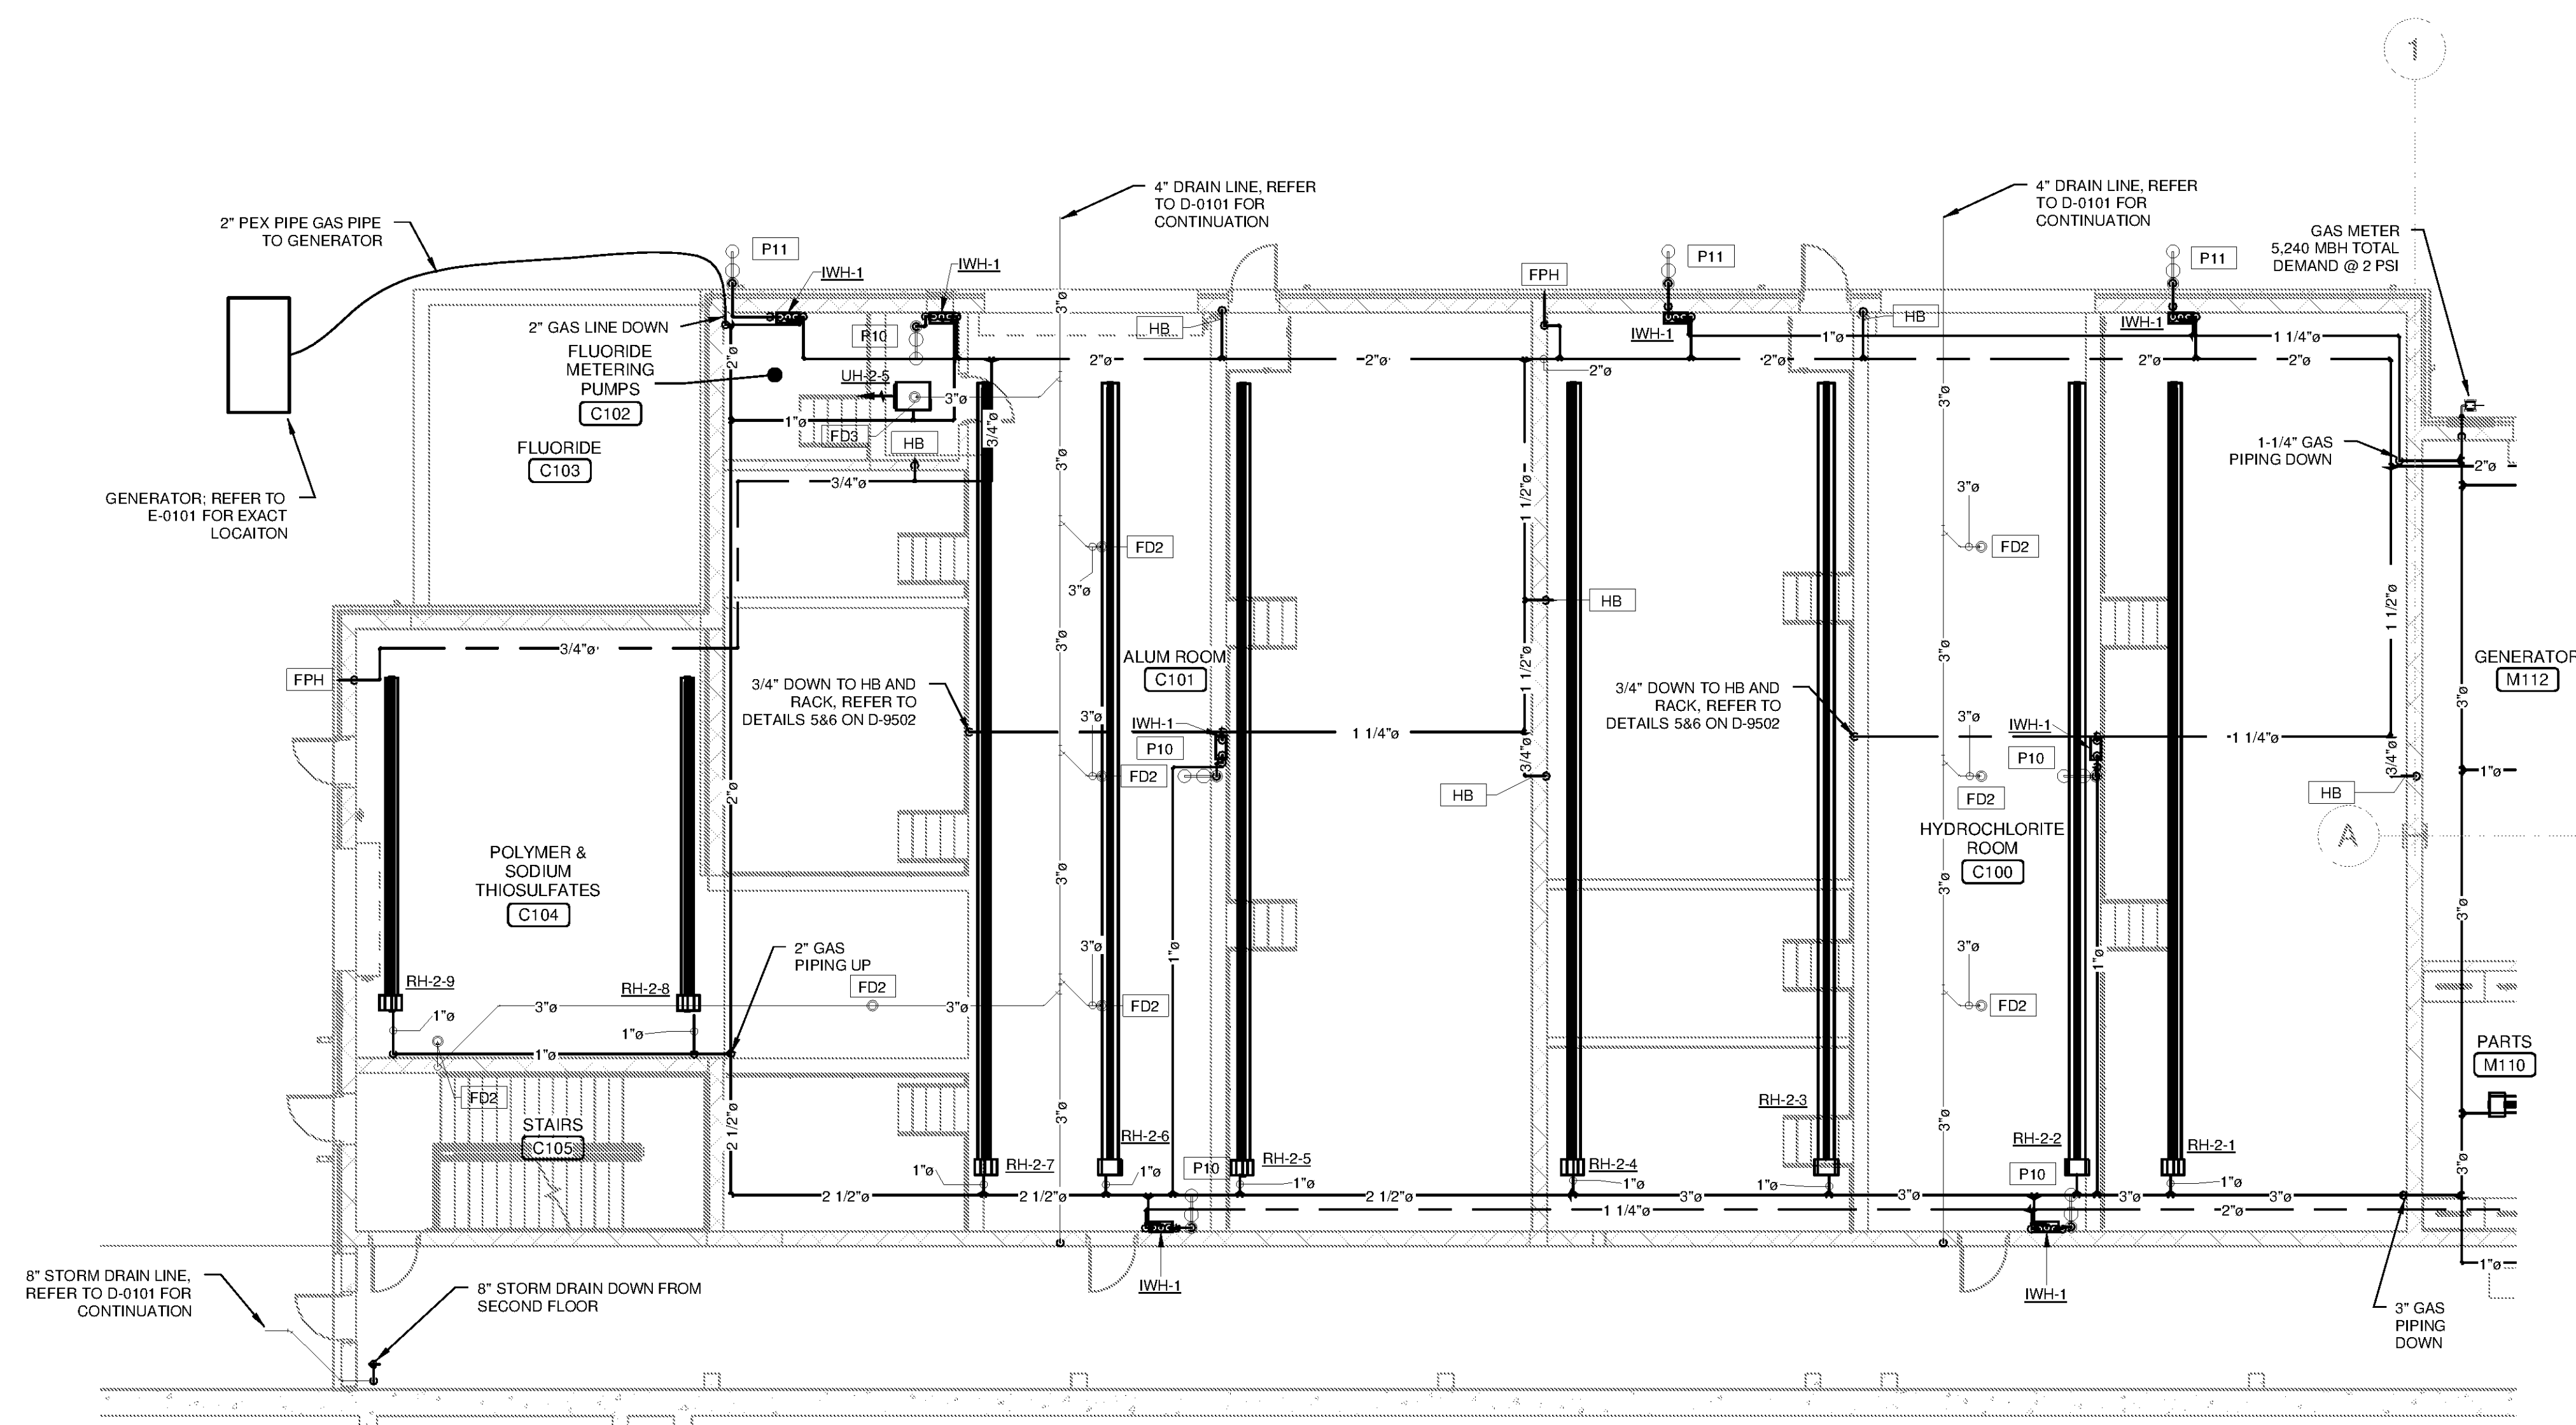


10/1/2014 1:47:37 PM C:\Users\justin.marsh\Documents\WTP-11740-M-MAINPR_justin.marsh.rvt

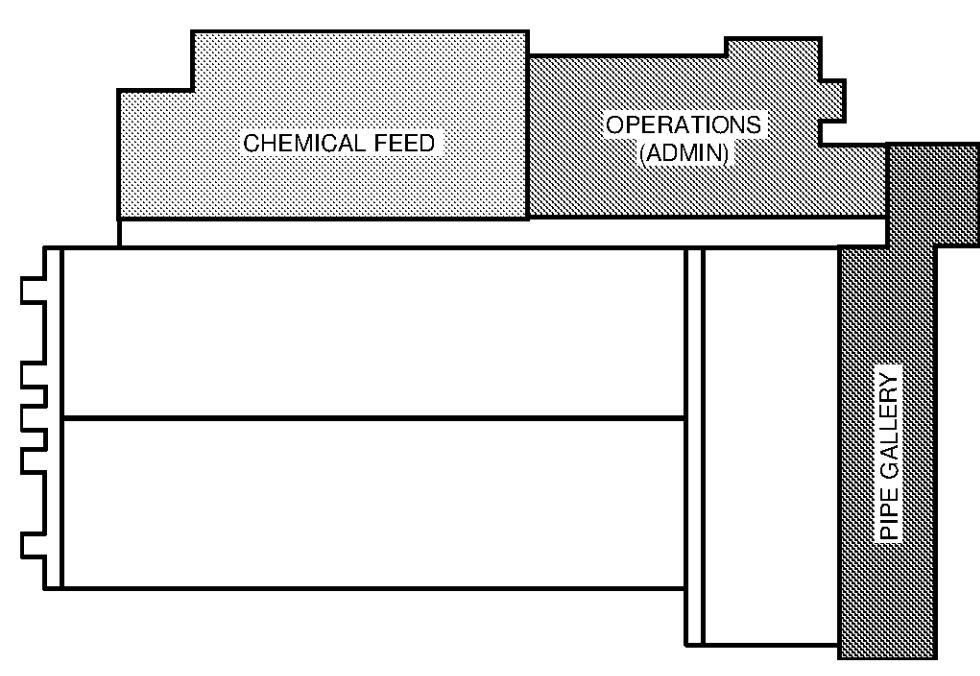

CHEMICAL FEED PLUMBING PLAN
SCALE: 1/8" = 1'-0"

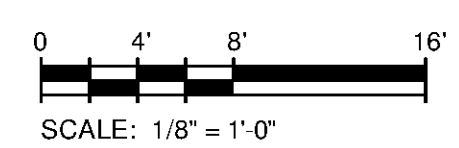

TETRA TECH
www.tetrattech.com
101 QUALITY CIRCLE, SUITE 140
HUNTSVILLE, ALABAMA 35896
PHONE: (256) 424-4077 FAX: (256) 424-4097

BID SET

ALABAMA REGISTERED PROFESSIONAL ENGINEER
No. 16553
DONALD S. BOYER
11/24/2014

MARK	DATE	DESCRIPTION	BY

HUNTSVILLE UTILITIES	SOUTHEAST WATER TREATMENT PLANT
MAIN PROCESS BUILDING	
CHEMICAL FEED	
PLUMBING PLAN	
Project No.:	200-11740-10003
Designed By:	JWM
Drawn By:	JWM
Checked By:	DSB

P-2103