




10/1/2014 1:47:44 PM C:\Users\justin.marsh\Documents\WTP-11740-M-MAINPR_justin.marsh.rvt

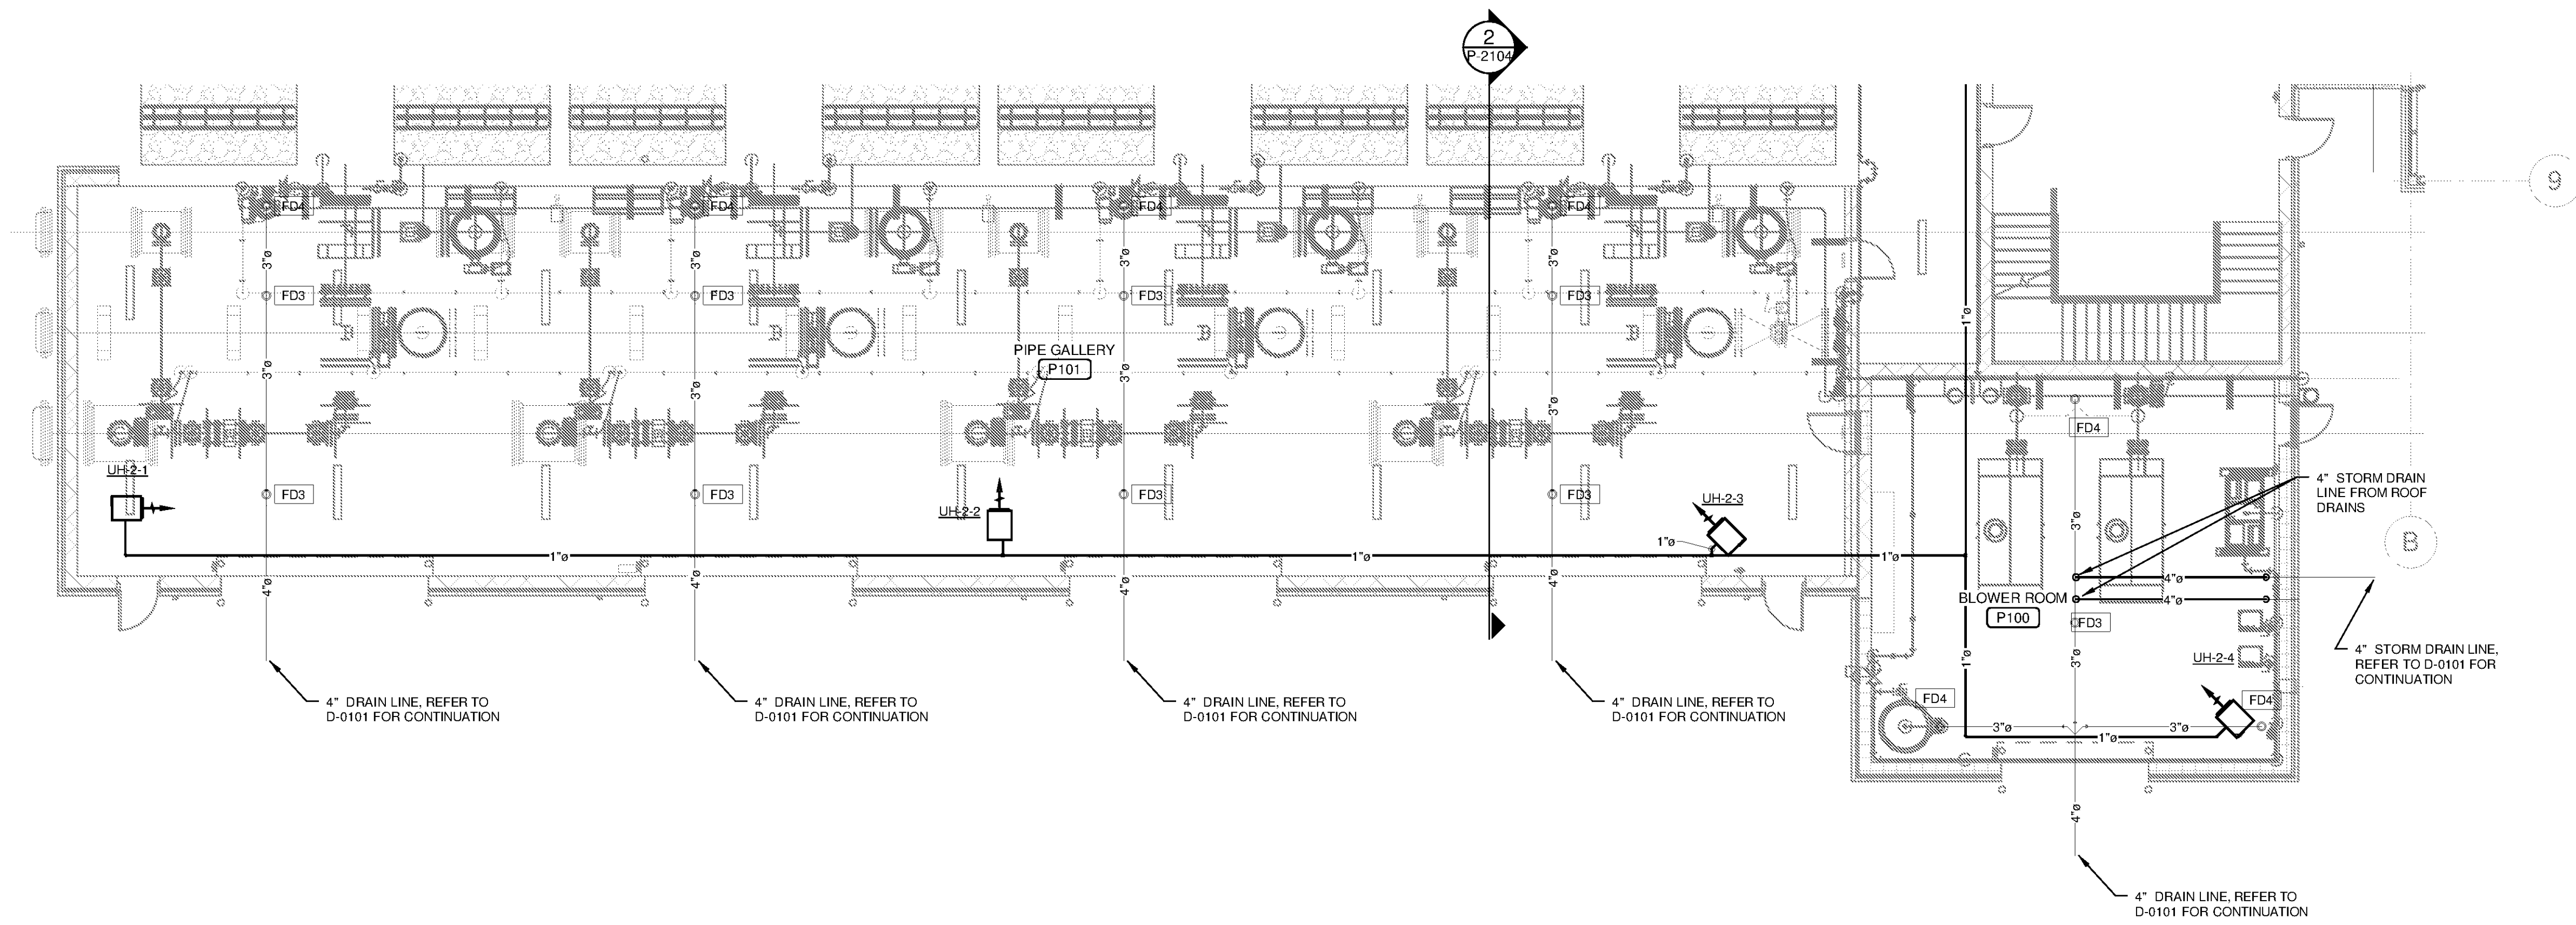


PIPE GALLERY PLUMBING PLAN
SCALE: 1/8" = 1'-0"

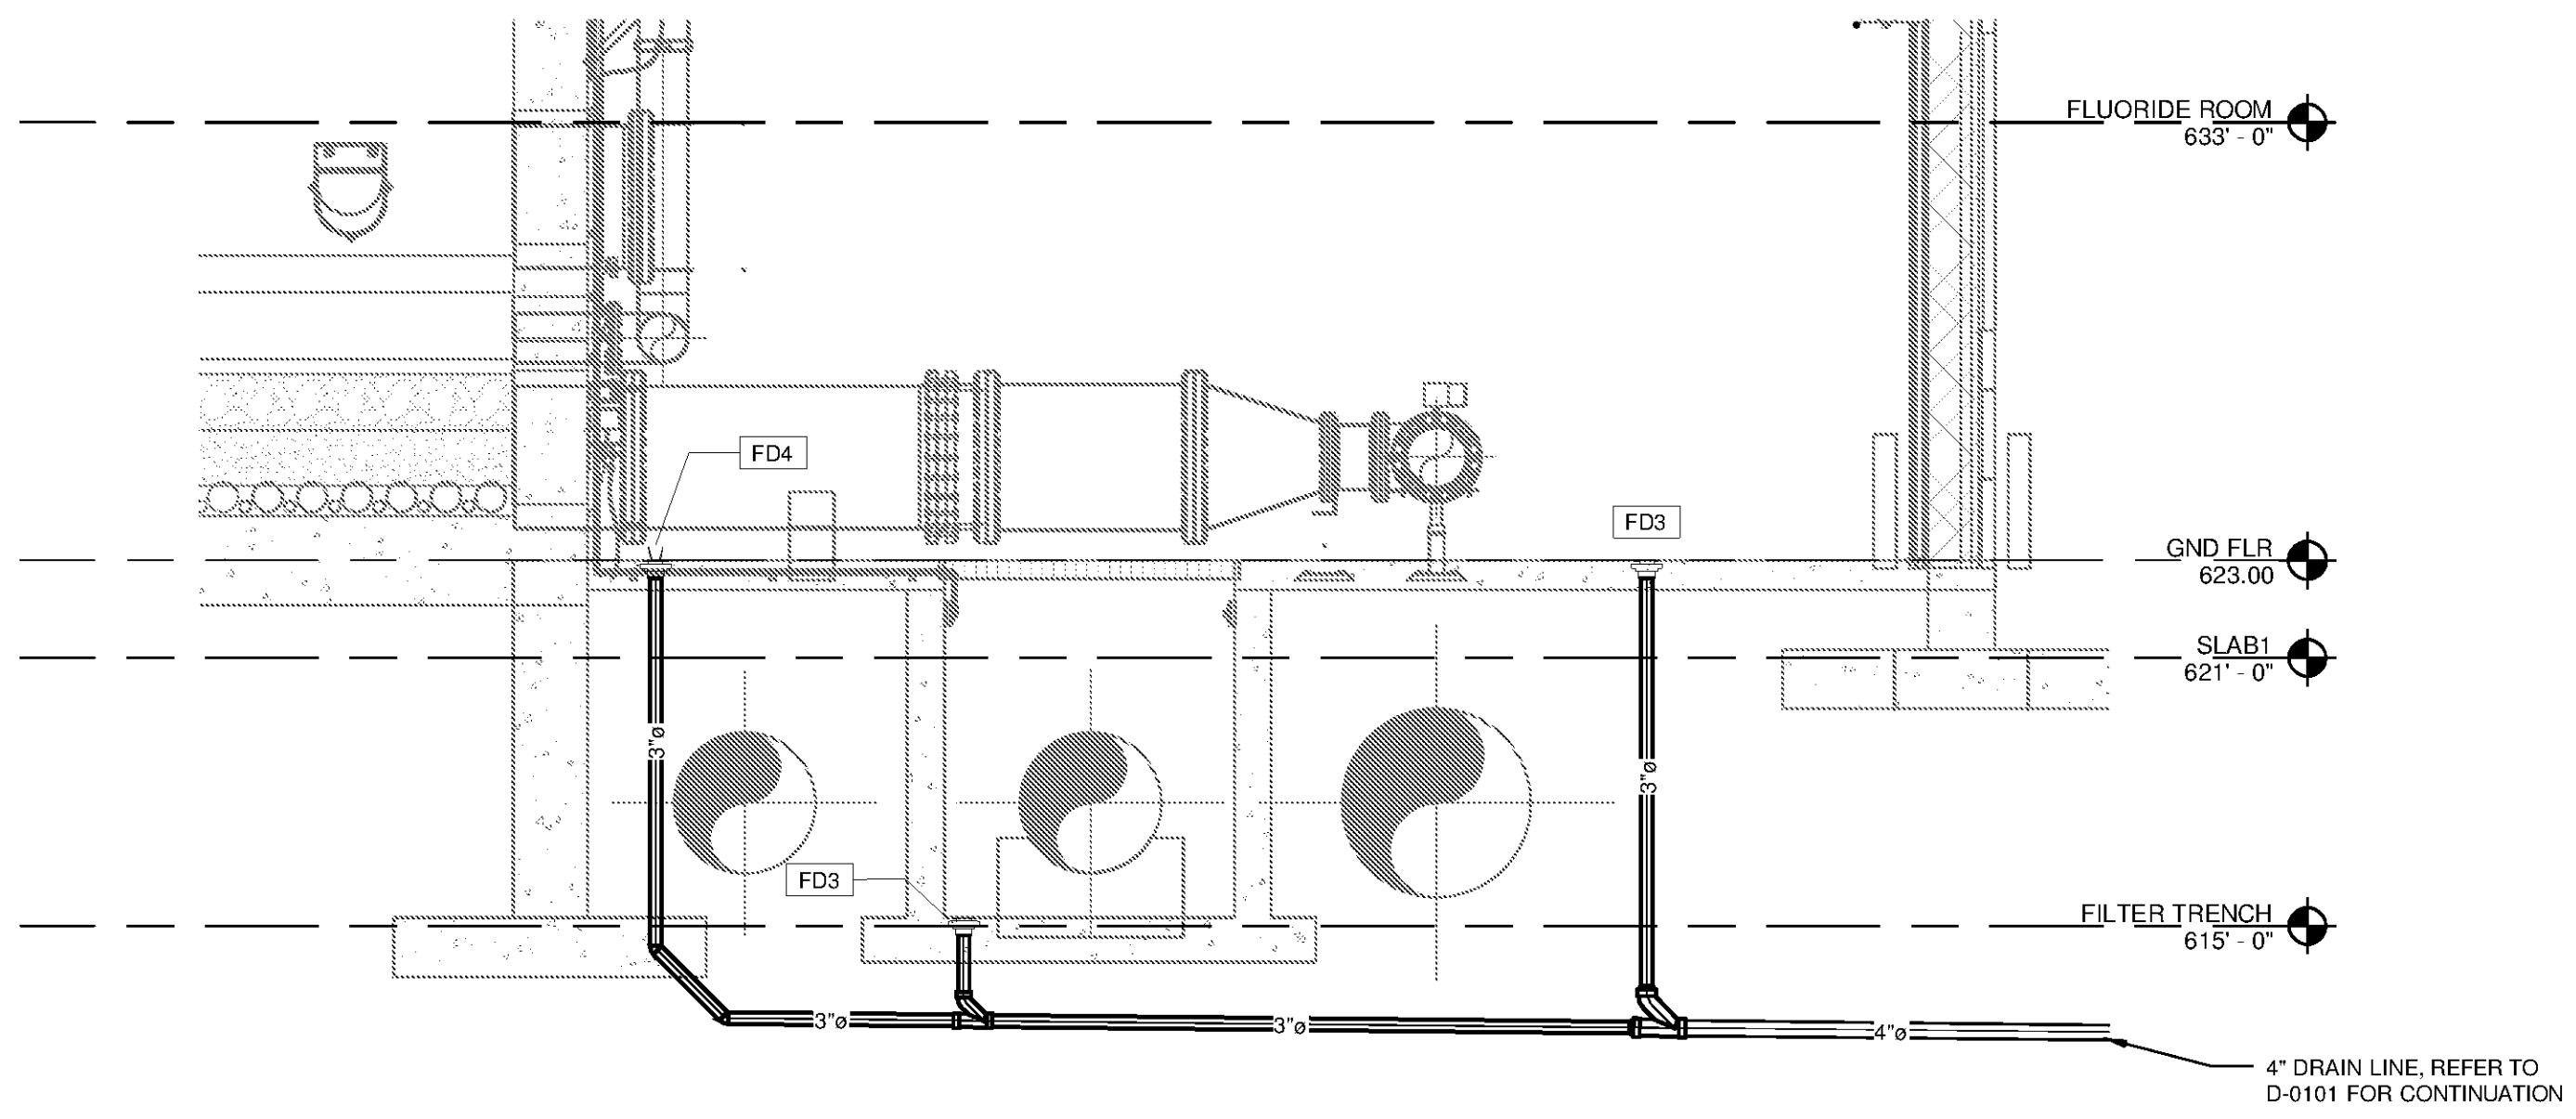

PIPE GALLERY SECTION
SCALE: 1/4" = 1'-0"

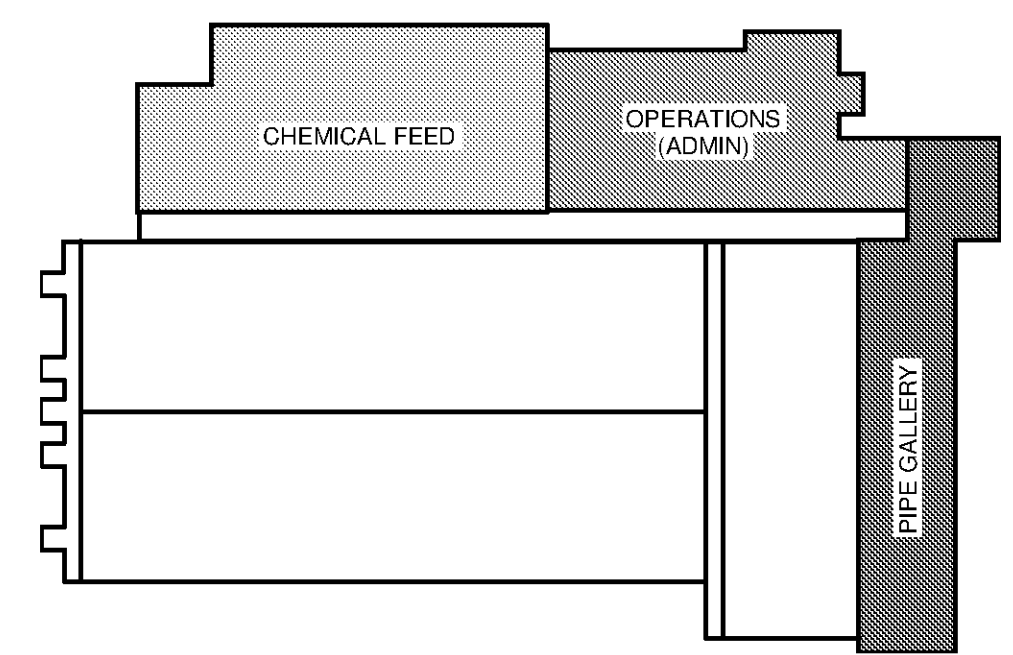

KEY PLAN

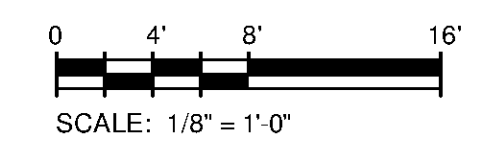

SCALE: 1/8" = 1'-0"

TETRA TECH
www.tetratech.com
101 QUALITY CIRCLE, SUITE 140
HUNTSVILLE, ALABAMA 35896
PHONE: (256) 424-4077 FAX: (256) 424-4097

BID SET
ALABAMA REGISTERED PROFESSIONAL ENGINEER
DONALD S. BOKER
No. 16553
11/24/2014

BY	MARK	DATE	DESCRIPTION

HUNTSVILLE UTILITIES
SOUTHEAST WATER TREATMENT PLANT
**MAIN PROCESS BUILDING
PIPE GALLERY PLUMBING
PLAN**

Project No.: 200-11740-10003
Designed By: JWM
Drawn By: JWM
Checked By: DSB

P-2104

Copyright Tetra Tech
Bar Measures 1 inch