



C:\Users\justin.marsh\Documents\WTP-11740-M-GACBAC_Justin.marsh.rvt

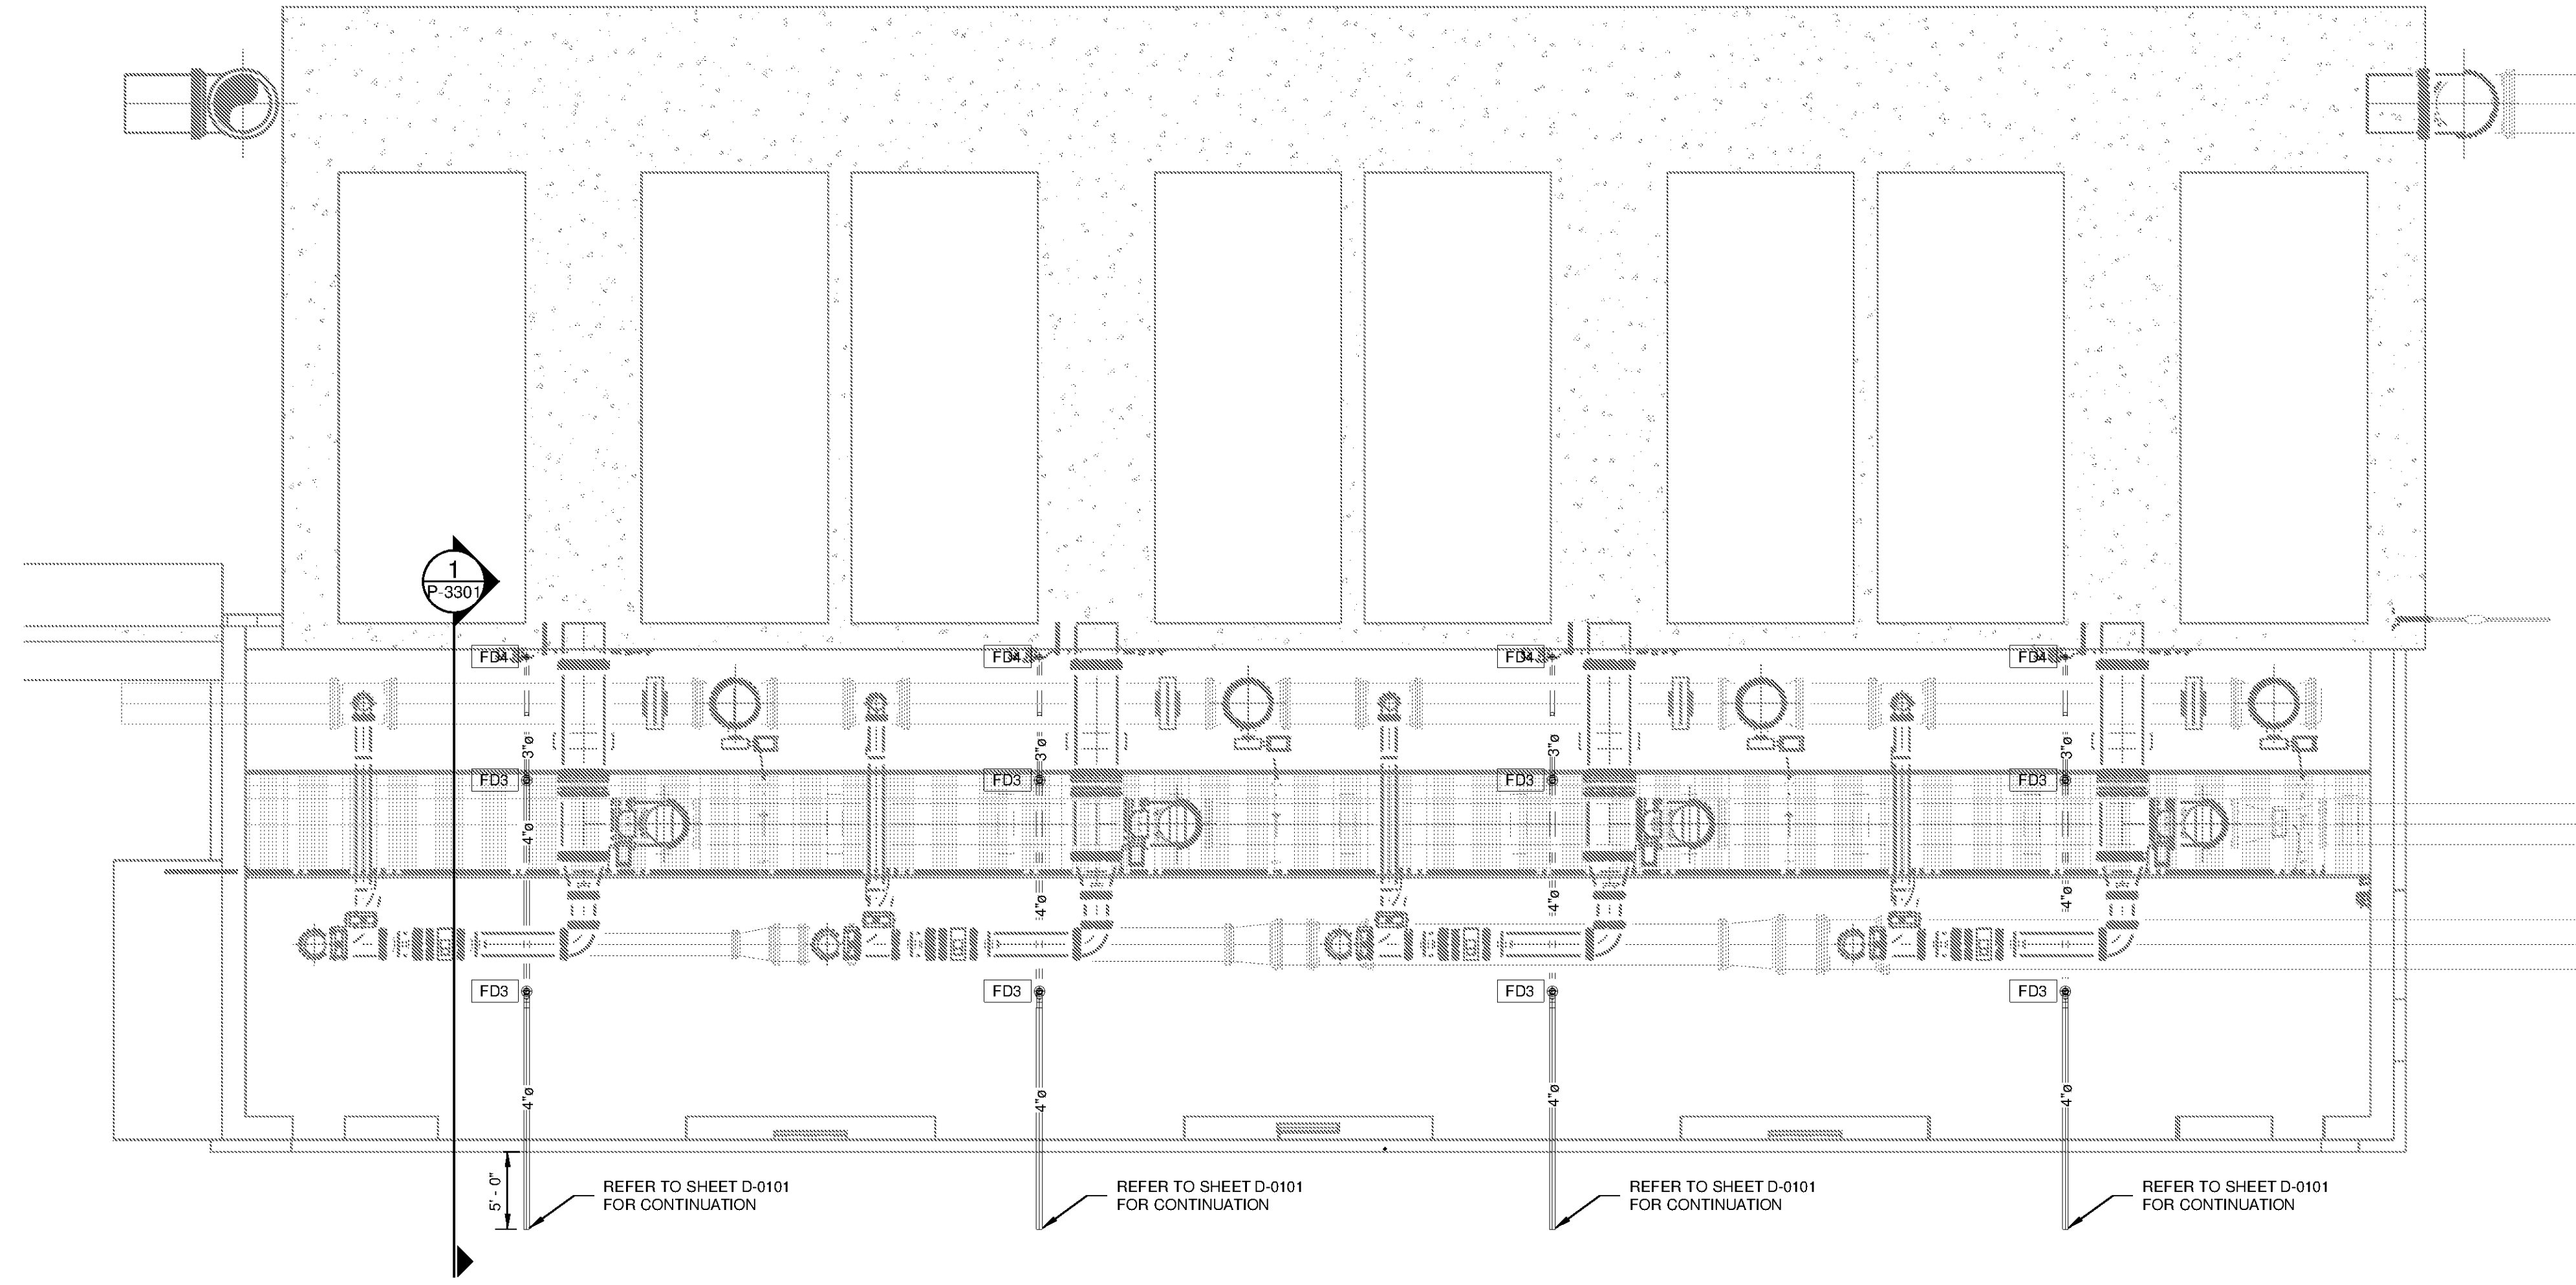

GAC/BAC FILTRATION BUILDING PLUMBING FLOOR PLAN
 SCALE: 1/8" = 1'-0"



BID SET

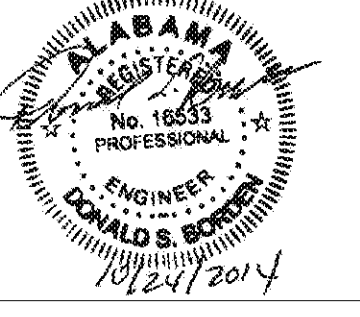

BY	MARK	DATE	DESCRIPTION

HUNTSVILLE UTILITIES
 SOUTHEAST WATER TREATMENT PLANT
GAC/BAC FILTRATION BUILDING PLUMBING PLAN

Project No.: 200-11740-10003
 Designed By: JWM
 Drawn By: JWM
 Checked By: DSB

P-3101

Copyright: Tetra Tech
 Bar Measures 1 inch