


10/1/2014 11:16:36 AM C:\Users\justin.marsh\Documents\WTP-11740-M-FINWTR\_justin.marsh.rvt


### FINISHED WATER PUMP STATION PLUMBING FLOOR PLAN

SCALE: 1/8" = 1'-0"

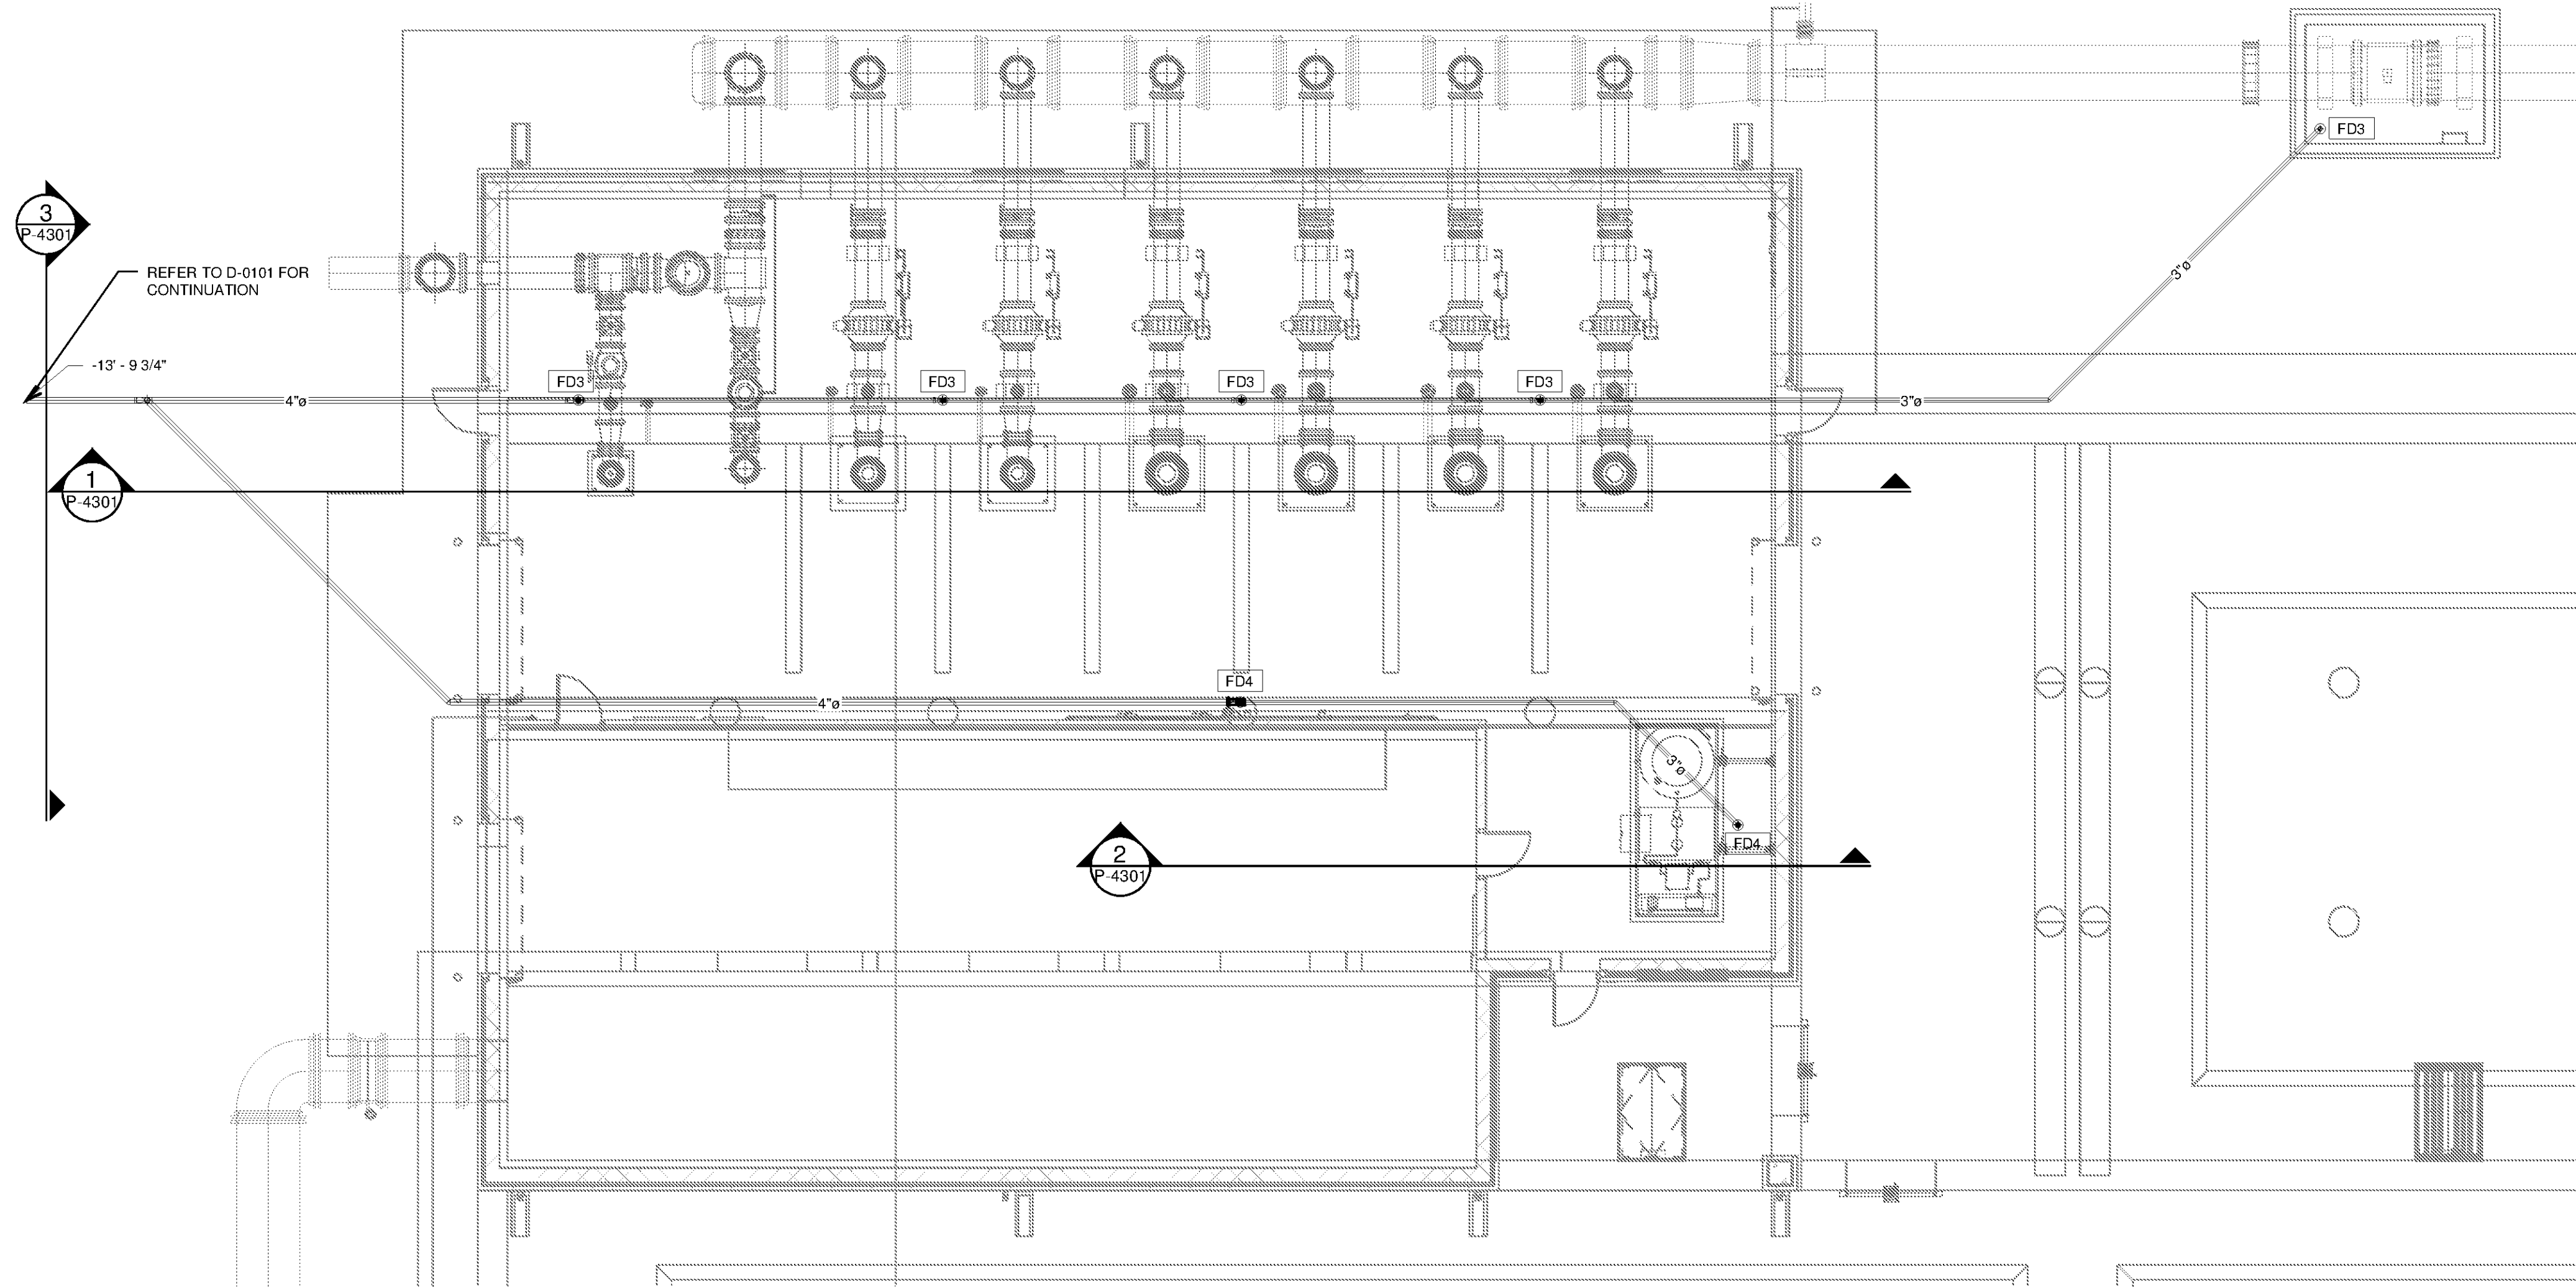

www.tetrattech.com  
 101 QUALITY CIRCLE, SUITE 140  
 HUNTSVILLE, ALABAMA 35896  
 PHONE: (256) 424-4077 FAX: (256) 424-4097

BID SET

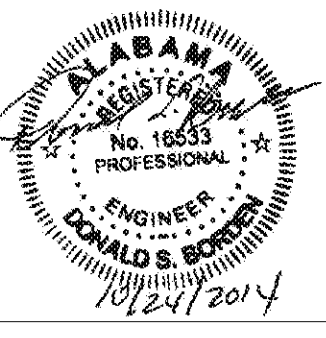

MARK	DATE	DESCRIPTION	BY

HUNTSVILLE UTILITIES  
 SOUTHEAST WATER TREATMENT PLANT  
**FINISHED WATER PUMP  
 STATION PLUMBING PLAN**

Project No.: 200-11740-10003  
 Designed By: JWM  
 Drawn By: JWM  
 Checked By: DSB

# P-4101

Copyright: Tetra Tech  
Bar Measures 1 inch