

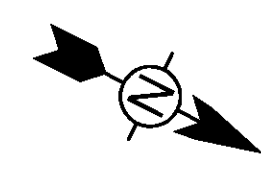


10/1/2014 11:4:05 PM C:\Users\justin.marsh\Documents\WTP-11740-GENATR\Cenral_justin.marsh.vvt

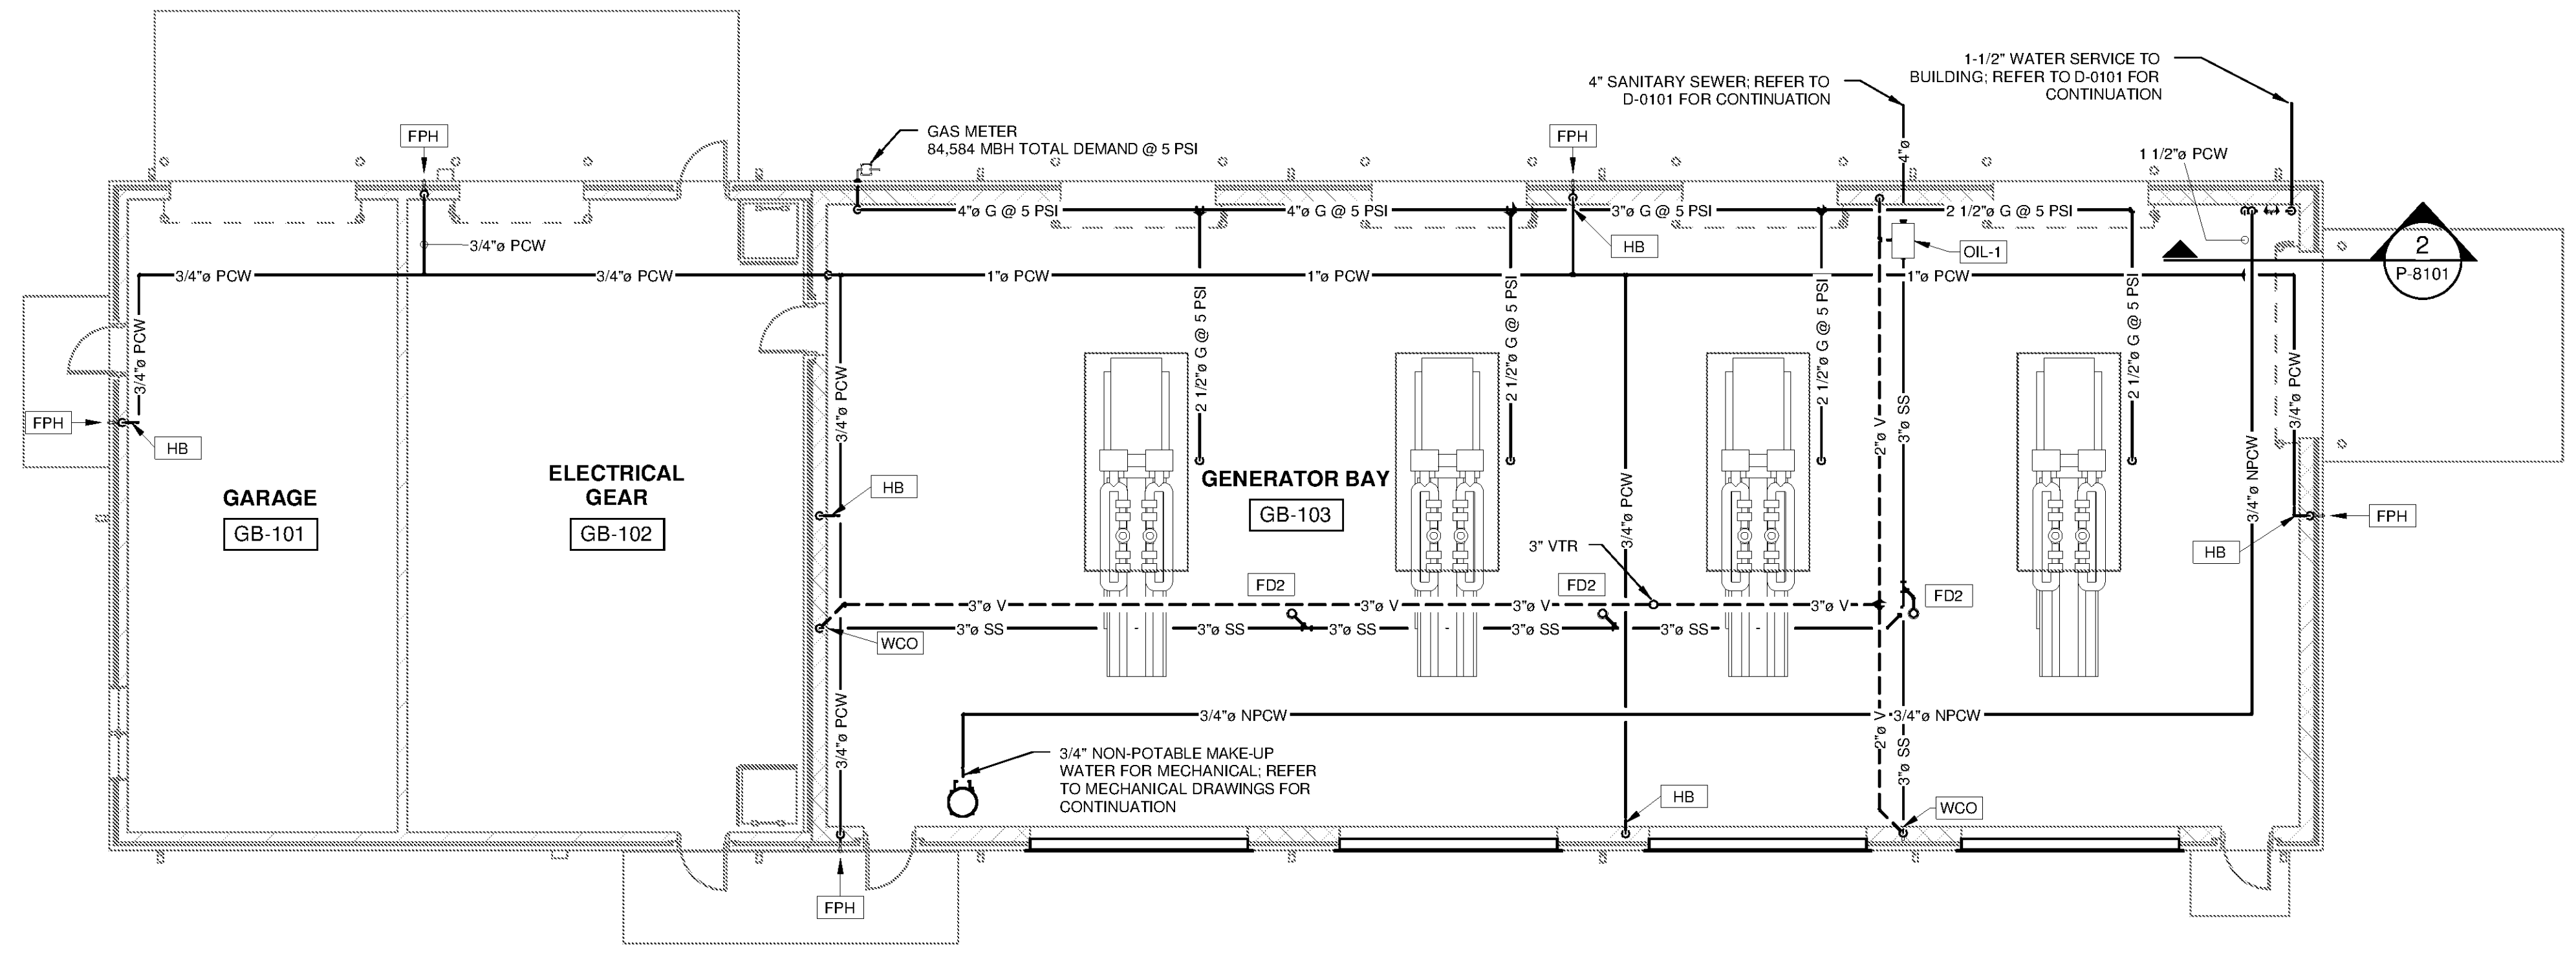

GENERATOR BUILDING PLUMBING PLAN
SCALE: 1/8" = 1'-0"

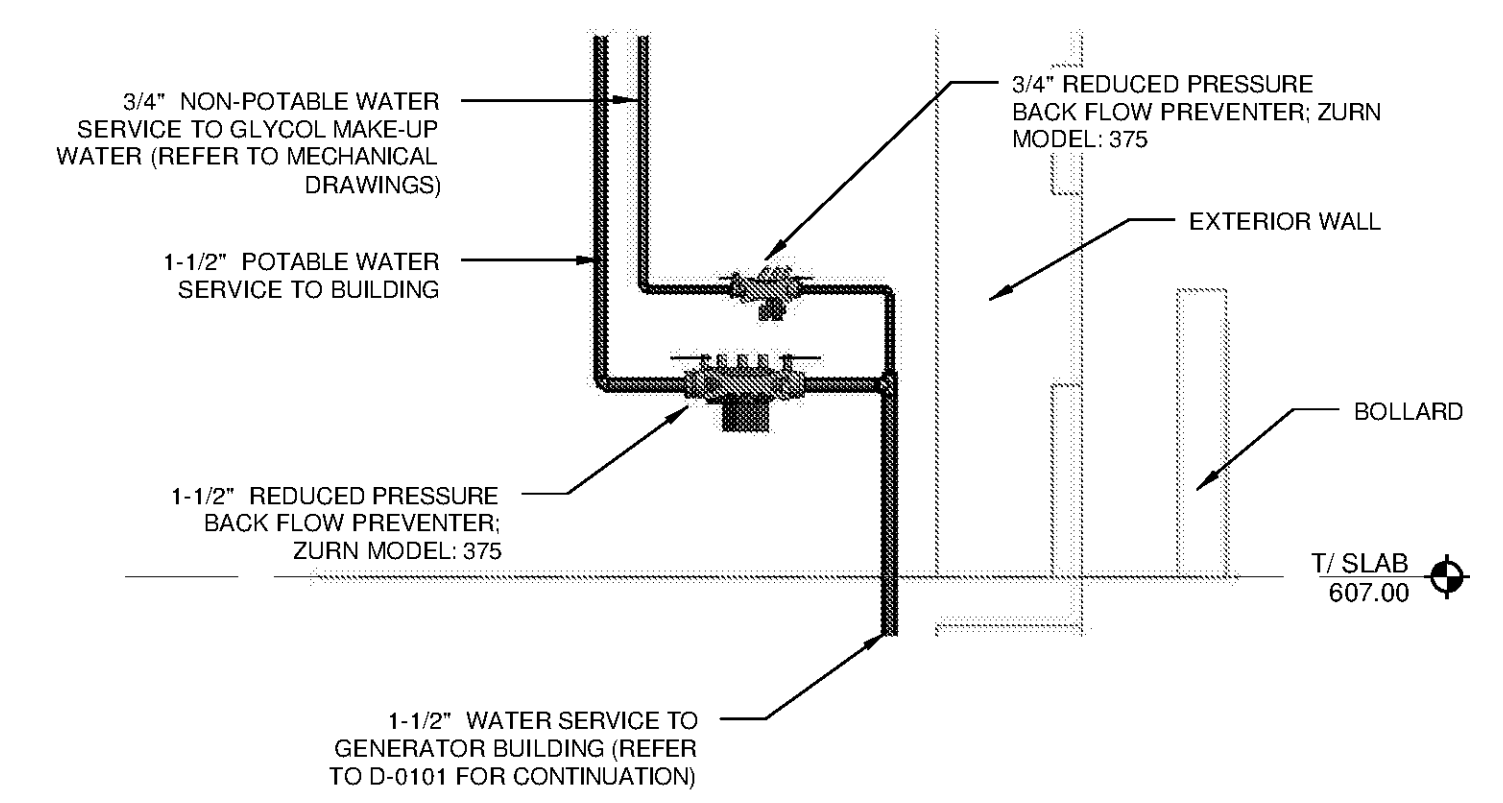

REDUCED PRESSURE BACK FLOW PREVENTER ELEVATION
SCALE: N.T.S.

TETRA TECH
www.tetrattech.com
101 QUALITY CIRCLE, SUITE 140
HUNTSVILLE, ALABAMA 35896
PHONE: (256) 424-4077 FAX: (256) 424-4097


BID SET
ALABAMA REGISTERED PROFESSIONAL ENGINEER
DONALD S. BOKER
No. 16553
12/24/2014

MARK	DATE	DESCRIPTION	BY

HUNTSVILLE UTILITIES
SOUTHEAST WATER TREATMENT PLANT
GENERATOR BUILDING PLUMBING PLAN

Project No.:	200-11740-10003
Designed By:	JWM
Drawn By:	JWM
Checked By:	DSB

P-8101

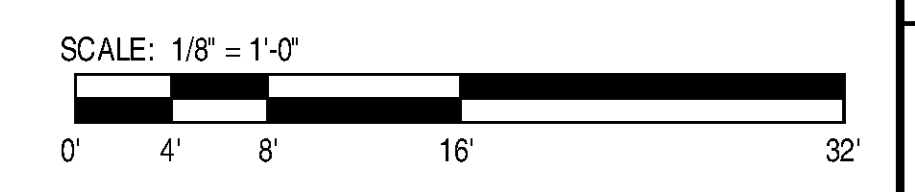

Copyright: Tetra Tech
Bar Measures 1 inch