


NOTE: LINE SIZES AS CALLED FOR ON SITE PLAN

1 GAS SERVICE CONNECTION DETAIL
SCALE: N.T.S.




2 GAS FIRED EQUIPMENT CONNECTION
SCALE: N.T.S.

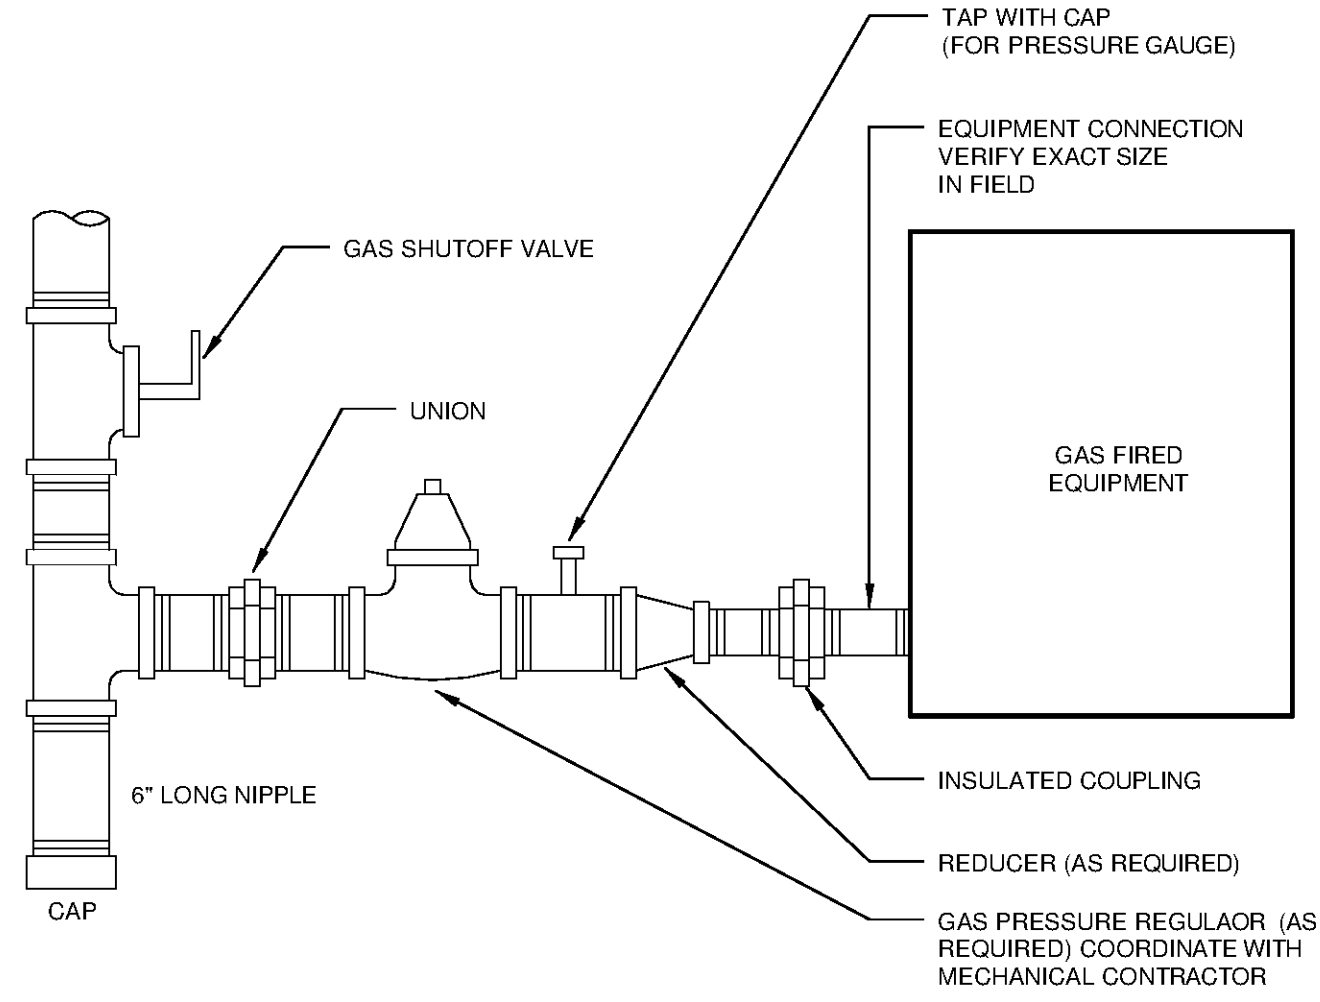

www.tetrattech.com
101 QUALITY CIRCLE, SUITE 140
HUNTSVILLE, ALABAMA 35896
PHONE: (256) 424-4077 FAX: (256) 424-4097

BID SET

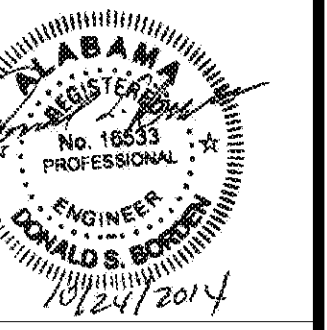

MARK	DATE	DESCRIPTION	BY

HUNTSVILLE UTILITIES
SOUTHEAST WATER TREATMENT PLANT
PLUMBING DETAILS

Project No.: 200-11740-10003
Designed By: JWM
Drawn By: JWM
Checked By: DSB

P-9502