
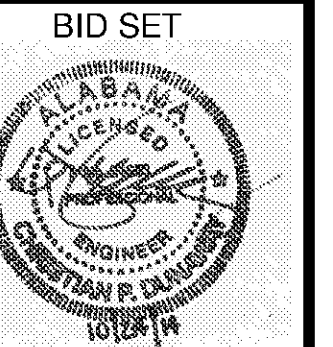
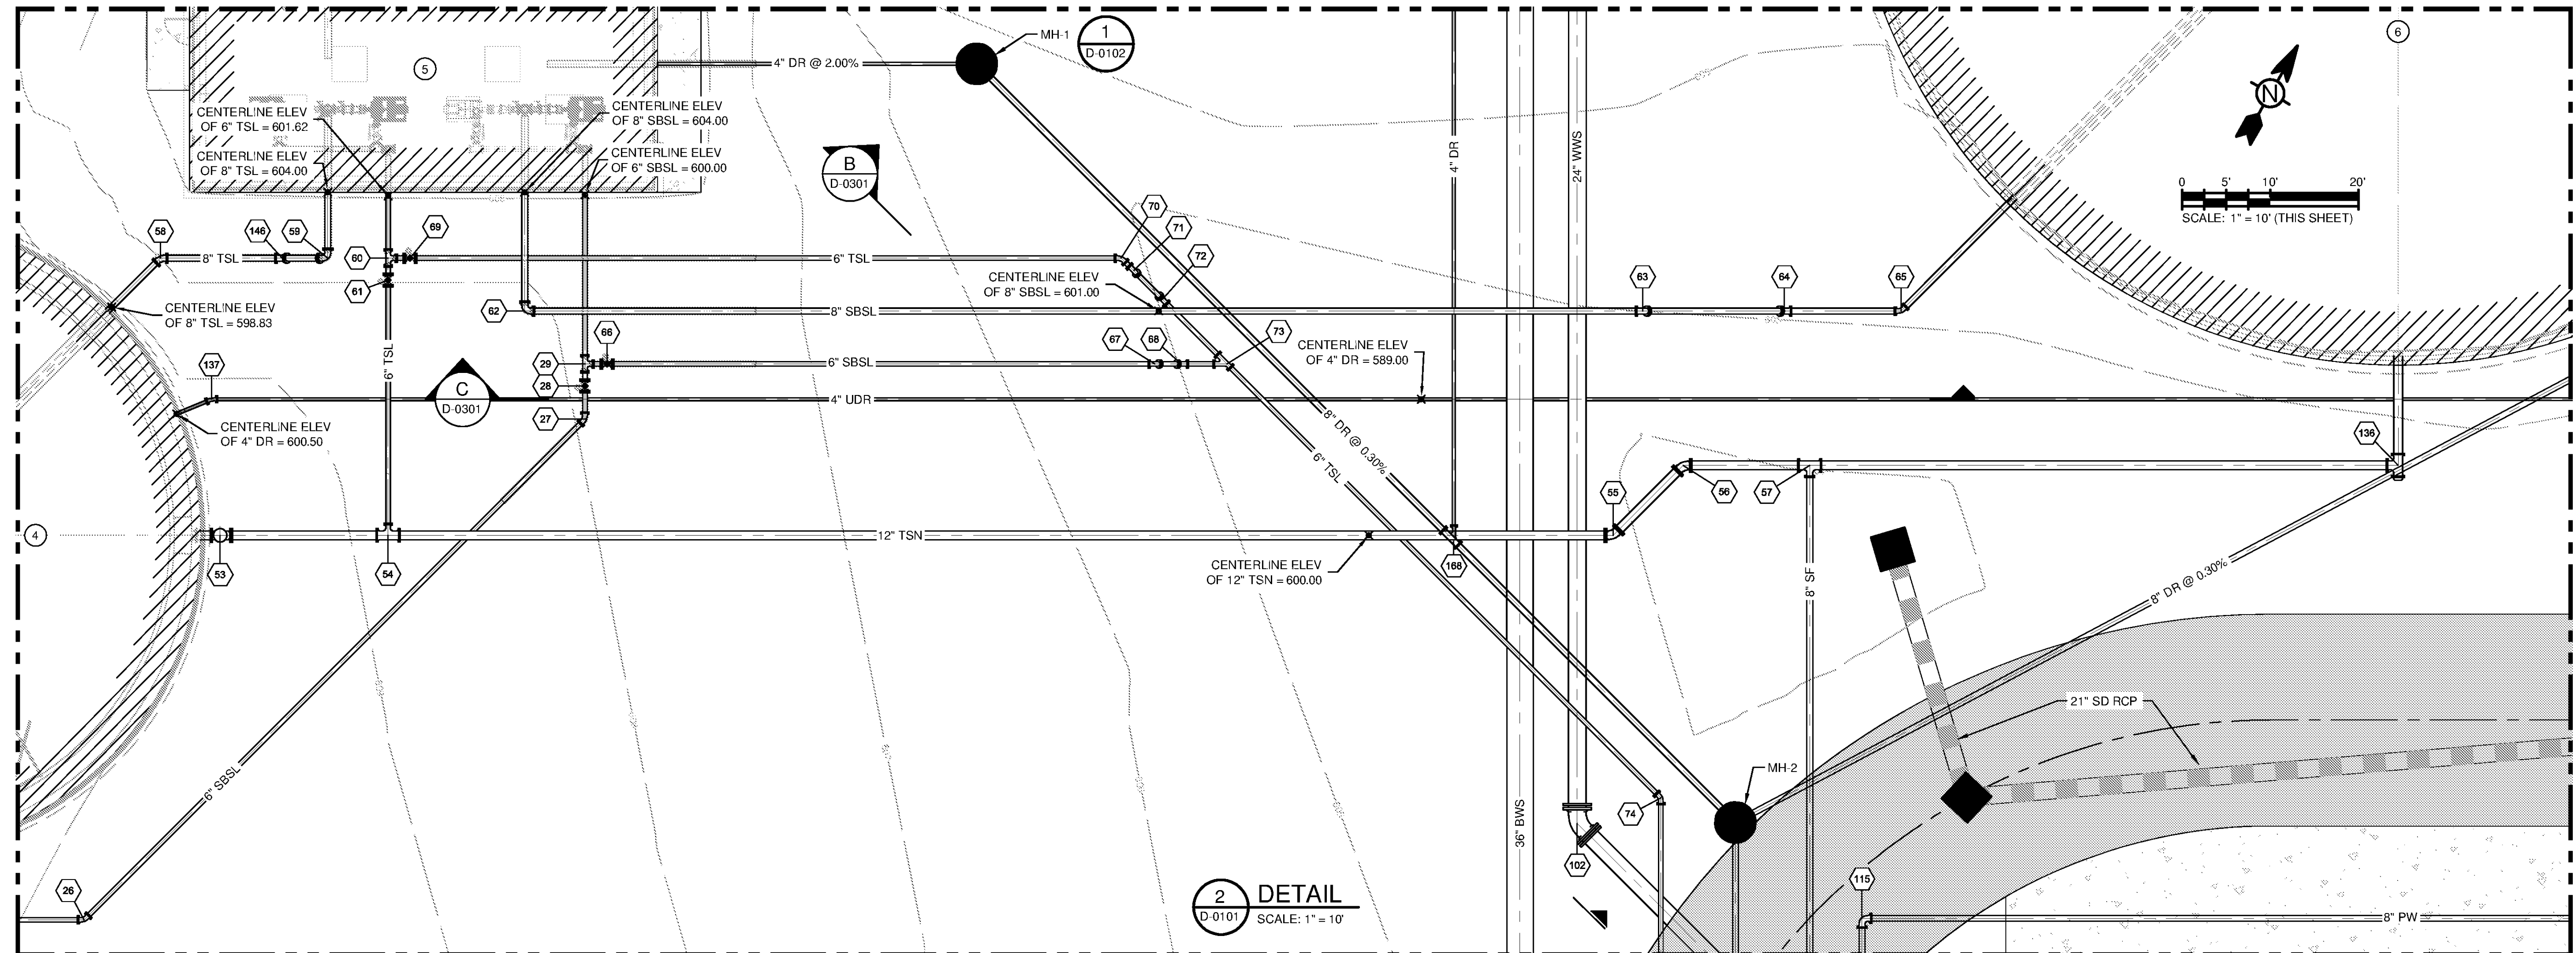


10/15/2014 9:52:38 AM \\SERVERS18\F51\PROJECTS\IER1740200-11740-10003\CAD\SHEETFILES\TREATMENT PLANT\WTP-D-0103\YARD PIPING PLANS.DWG SANFORD, CHADWICK

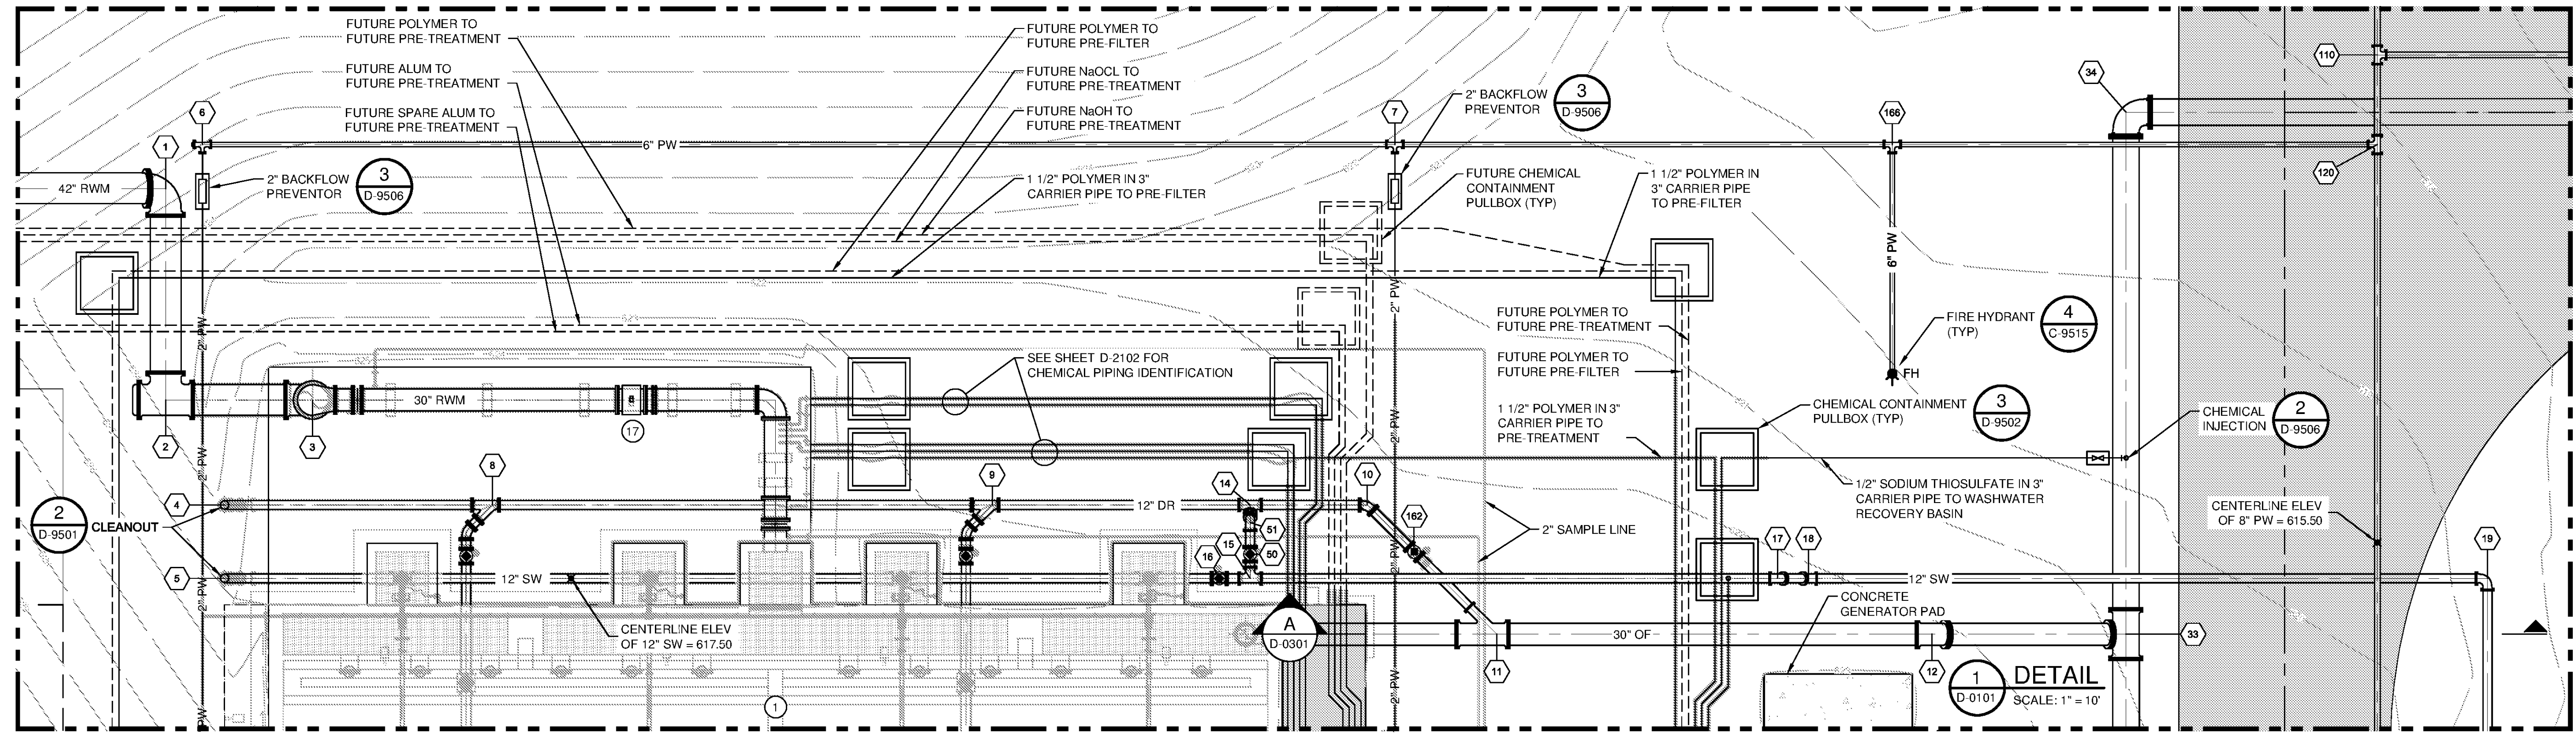

BID SET

BY	DATE	DESCRIPTION

MARK	DATE	DESCRIPTION

HUNTSVILLE UTILITIES  
 SOUTHEAST WATER TREATMENT PLANT  
 YARD PIPING  
 ENLARGED PLANS

Project No.: 200-11740-10003  
 Designed By: JPT  
 Drawn By: CIS  
 Checked By: JKK

D-0103

Copyright Tetra Tech  
 Bar Measures 1 inch