



10/15/2014 9:56:32 AM \\SERVERS18\FS1\PROJECTS\IER1740200-1174010003\CAD\SHETS\FILES\TREATMENT PLANT\WTP-D-010X YARD PIPING PLANS.DWG SANFORD, CHADWICK

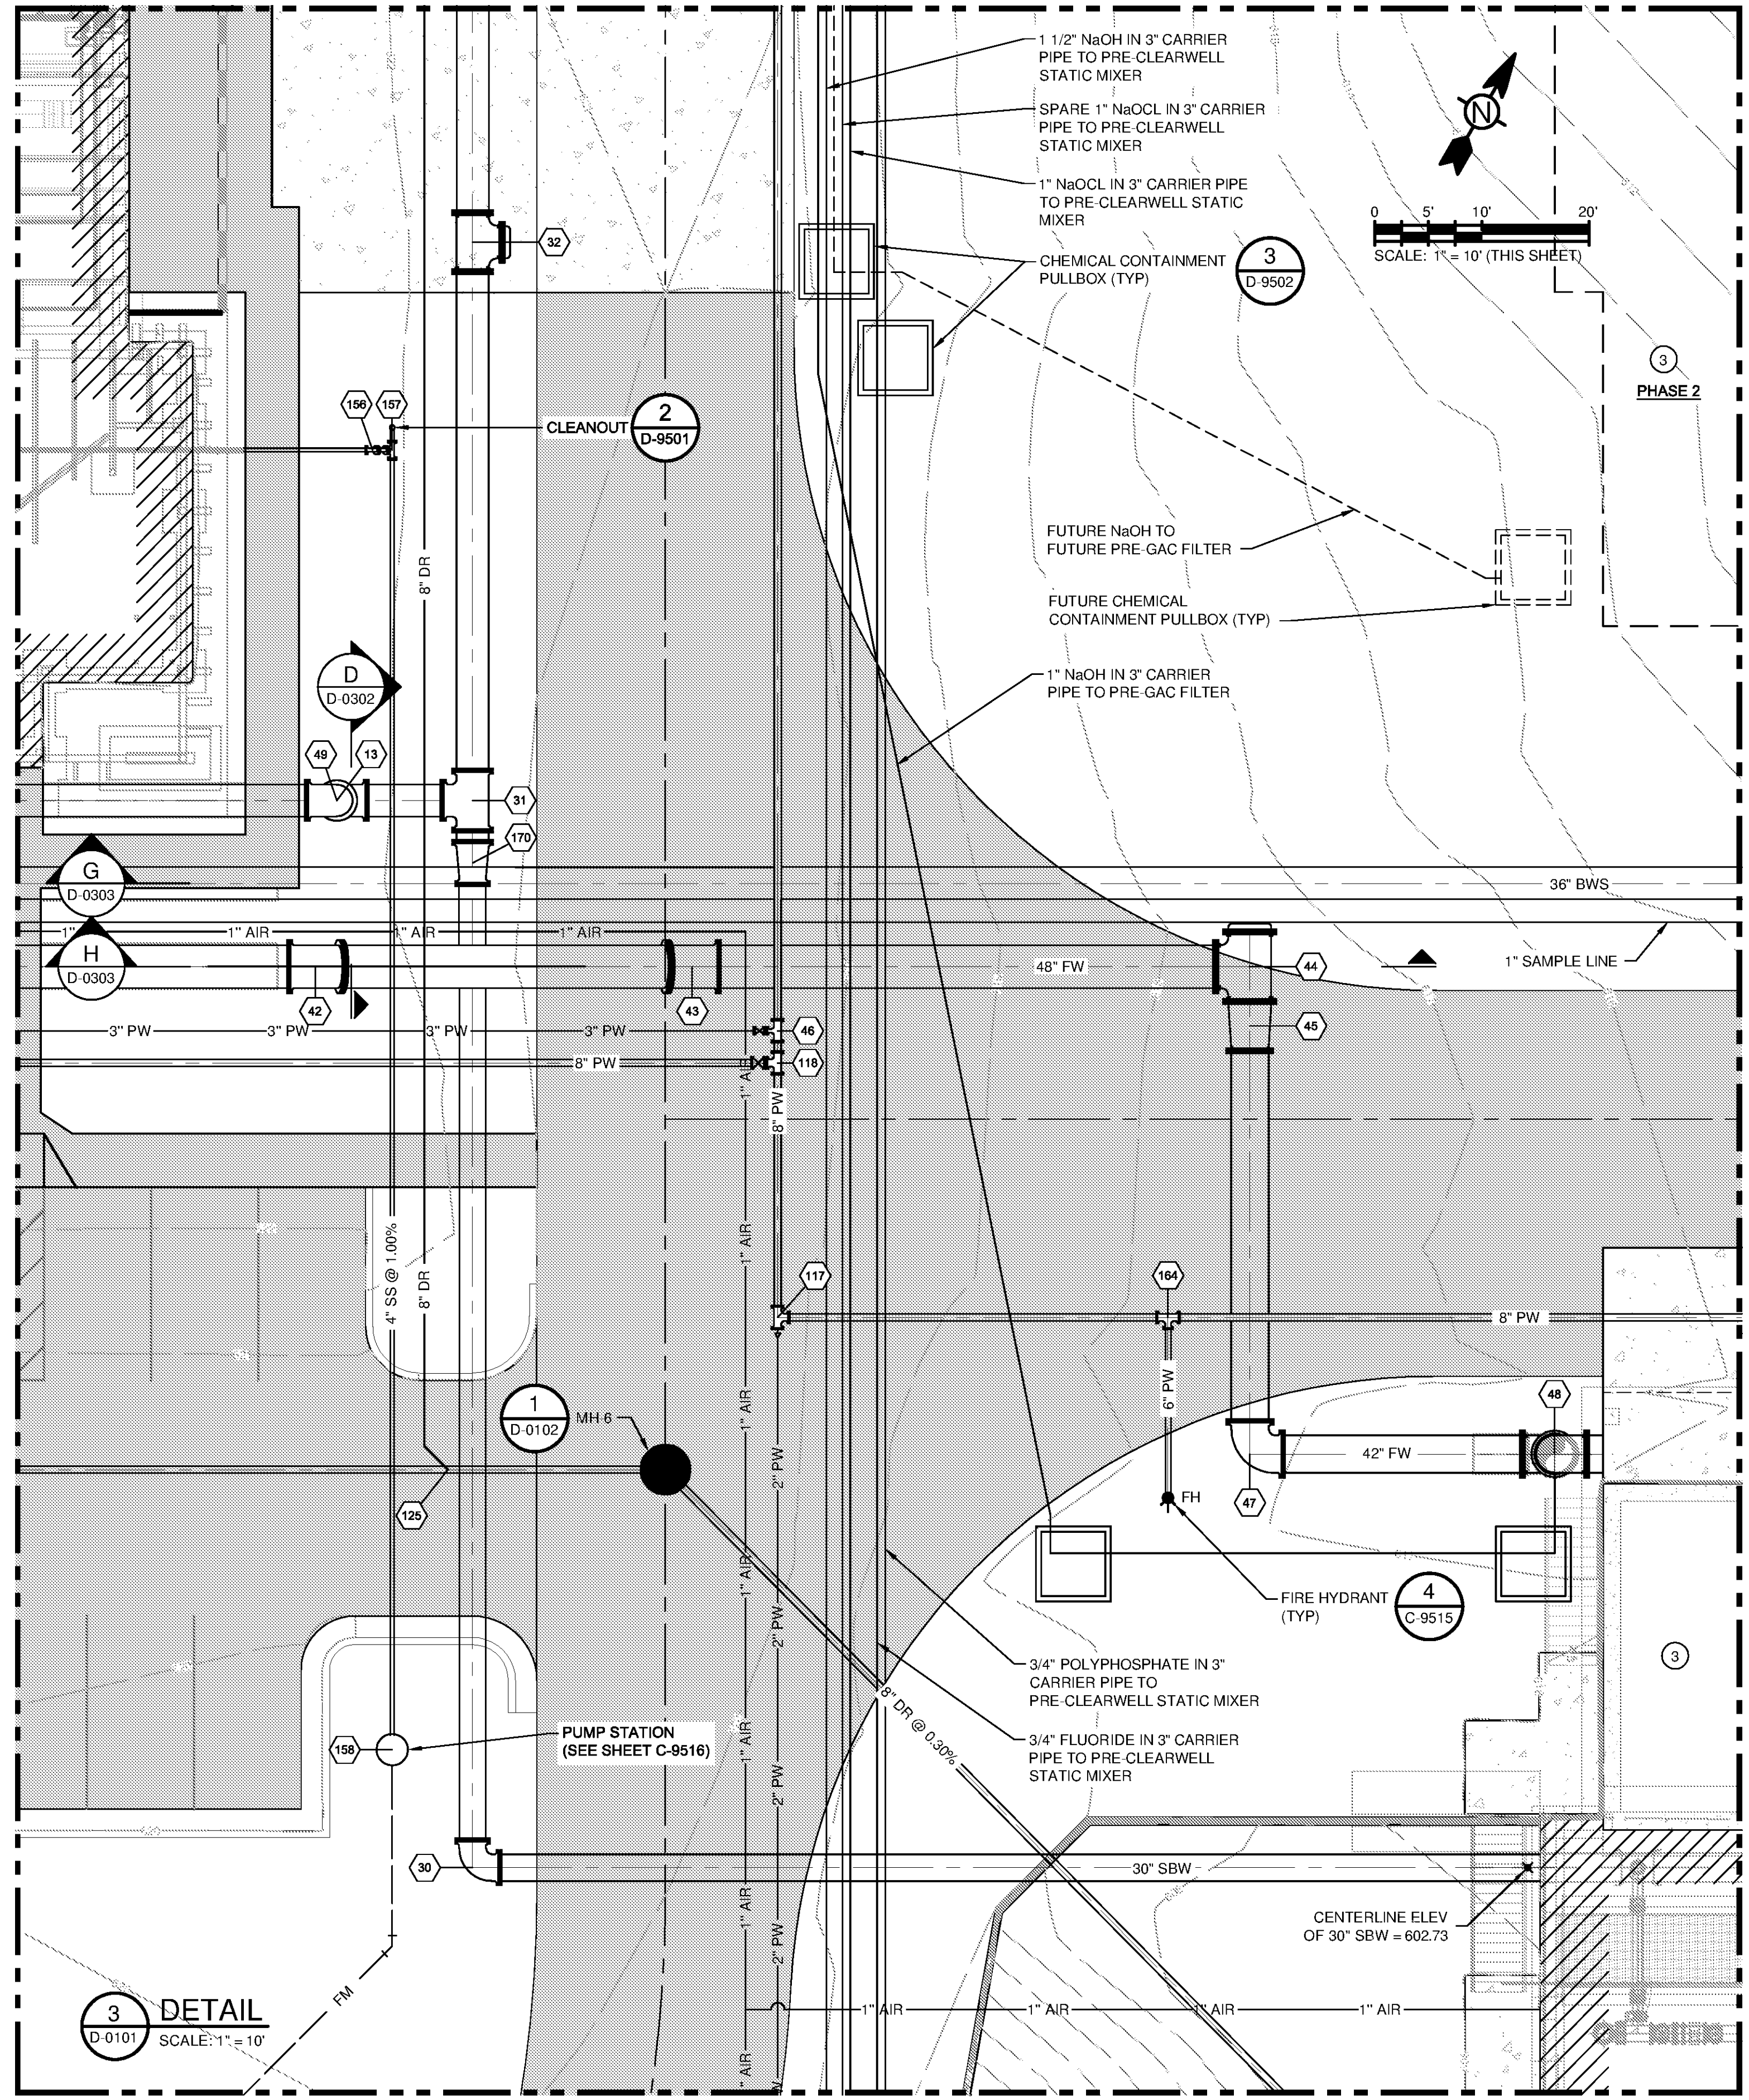

3 DETAIL
D-0101
SCALE: 1" = 10'

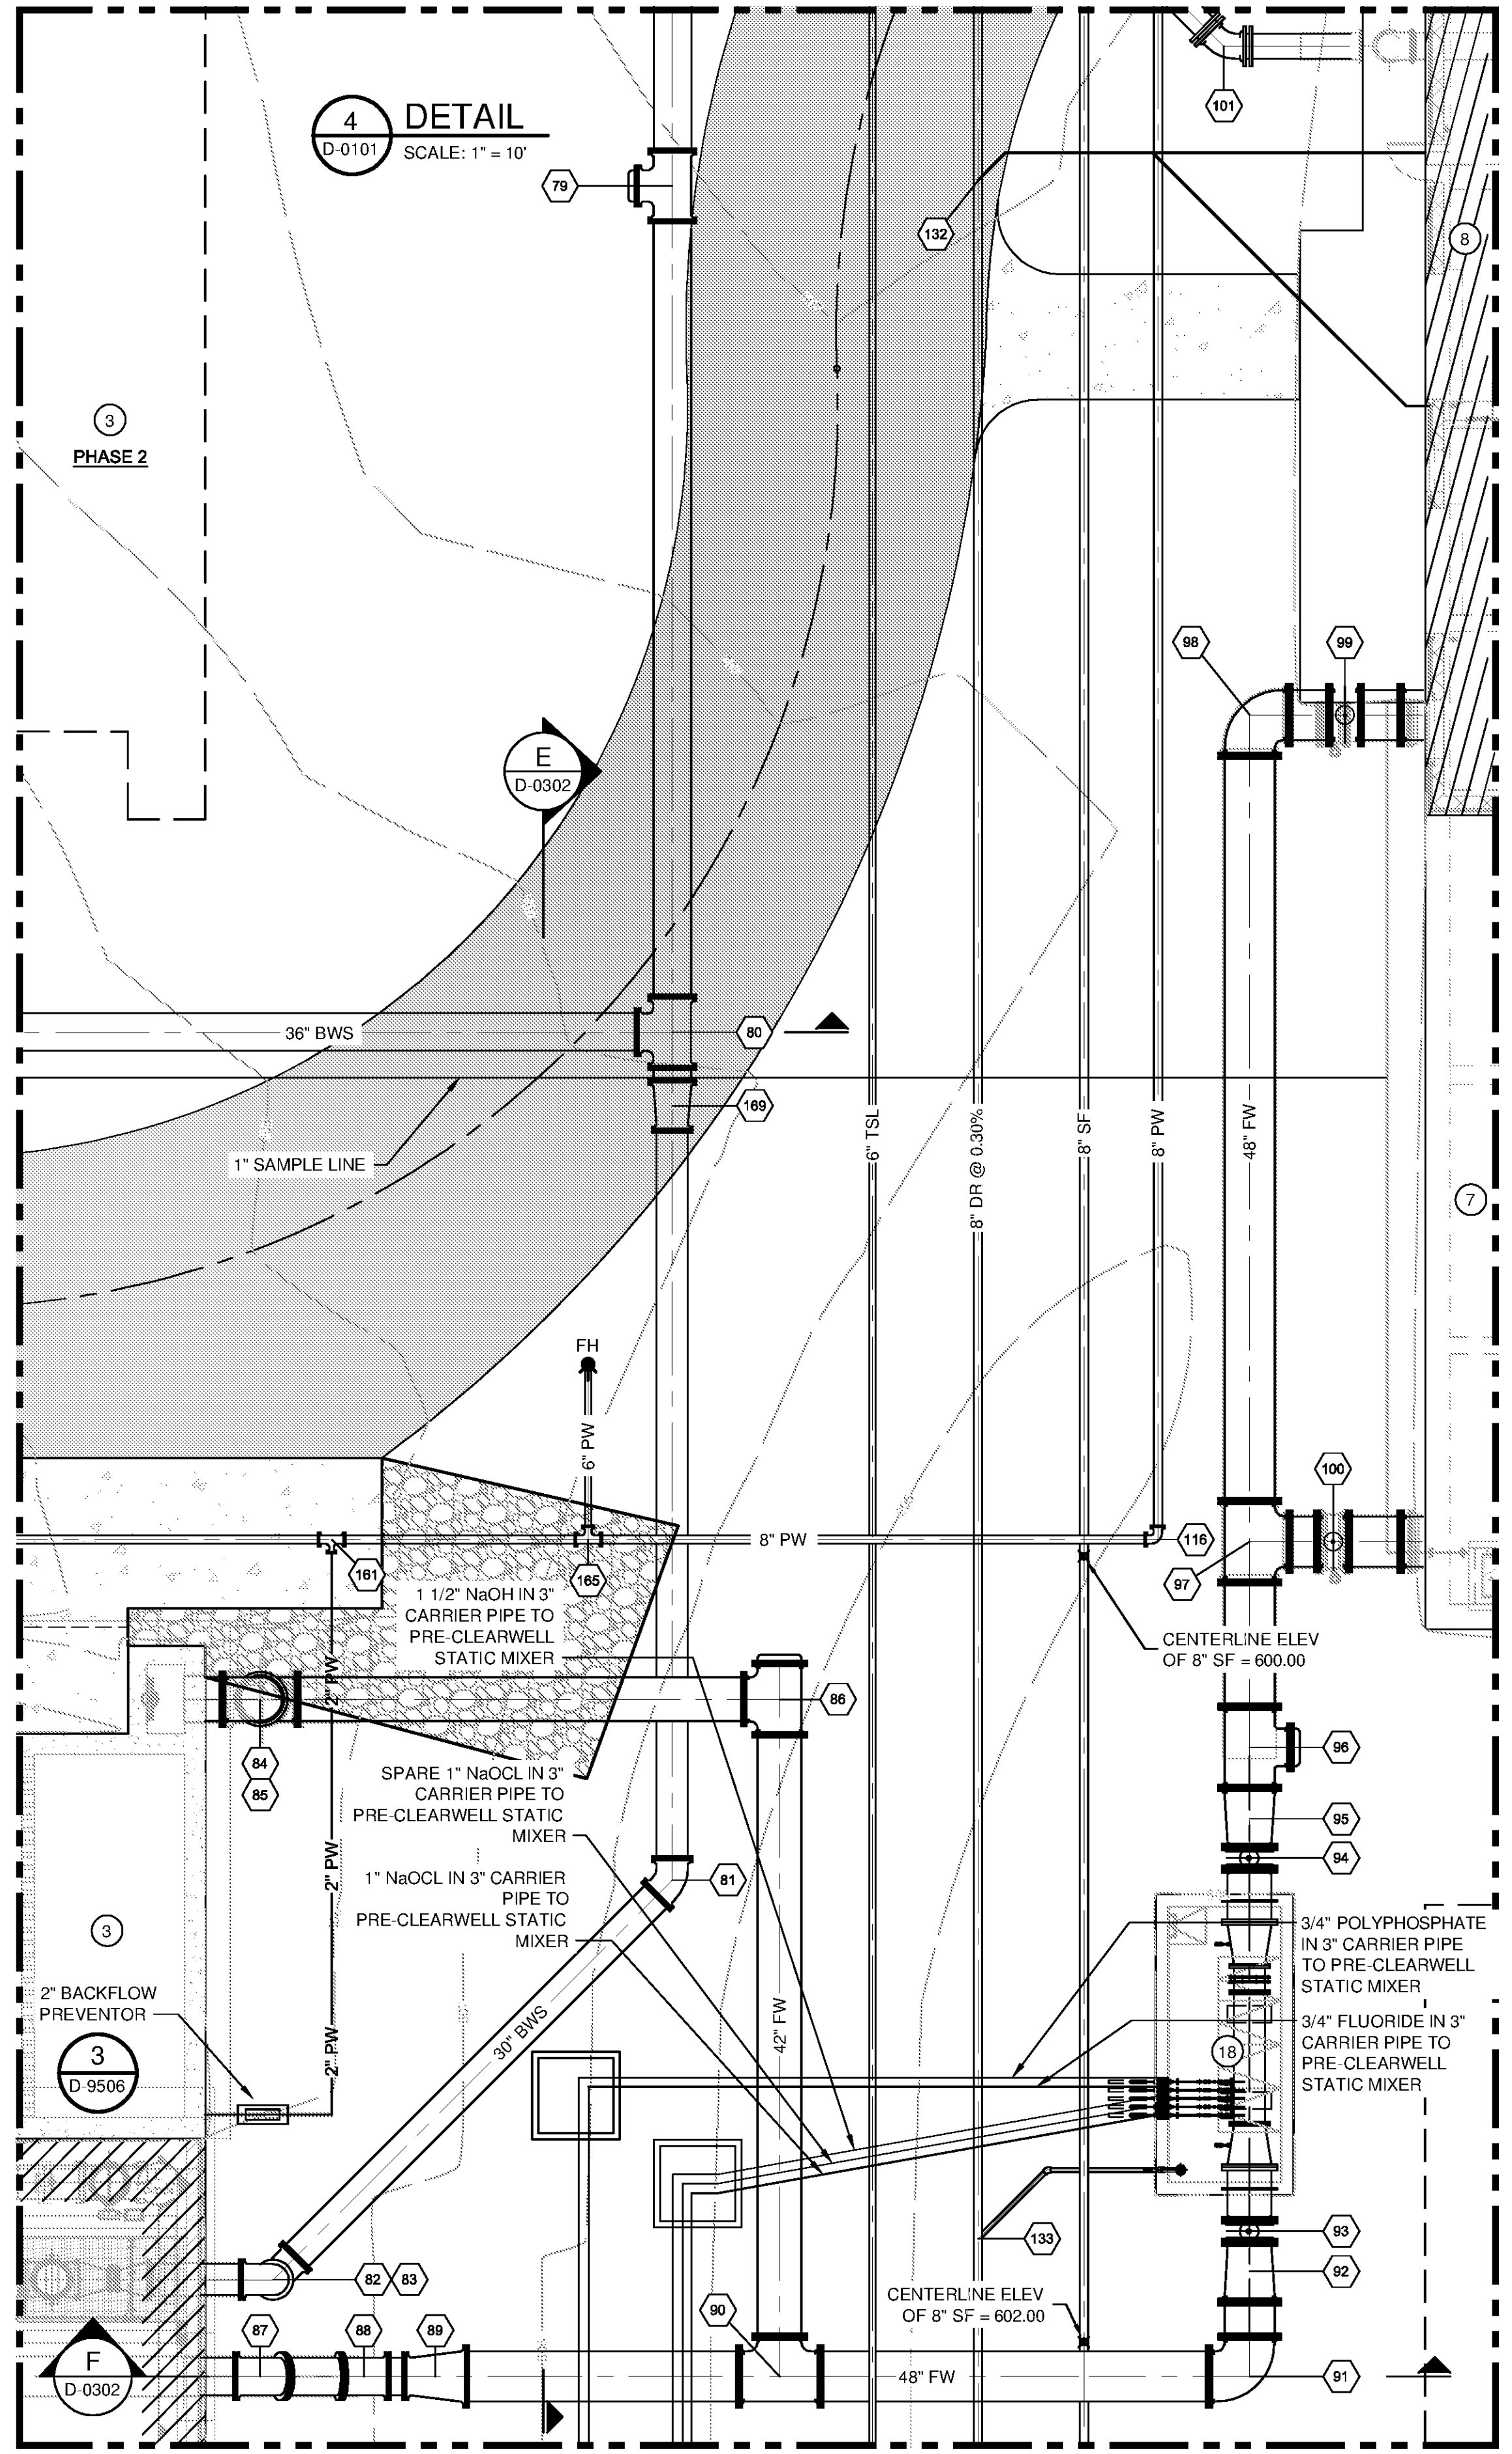

4 DETAIL
D-0101
SCALE: 1" = 10'

TETRA TECH		www.tetrattech.com 101 QUALITY CIRCLE, SUITE 140 HUNTSVILLE, ALABAMA 35806 PHONE: (256) 424-4077 FAX: (256) 424-4097
BID SET		
BY	DATE	DESCRIPTION
HUNTSVILLE UTILITIES SOUTHEAST WATER TREATMENT PLANT YARD PIPING ENLARGED PLANS		
Project No.: 200-11740-10003		
Designed By: JPT		
Drawn By: CIS		
Checked By: JKK		
D-0104		
Copyright Tetra Tech Bar Measures 1 inch		