
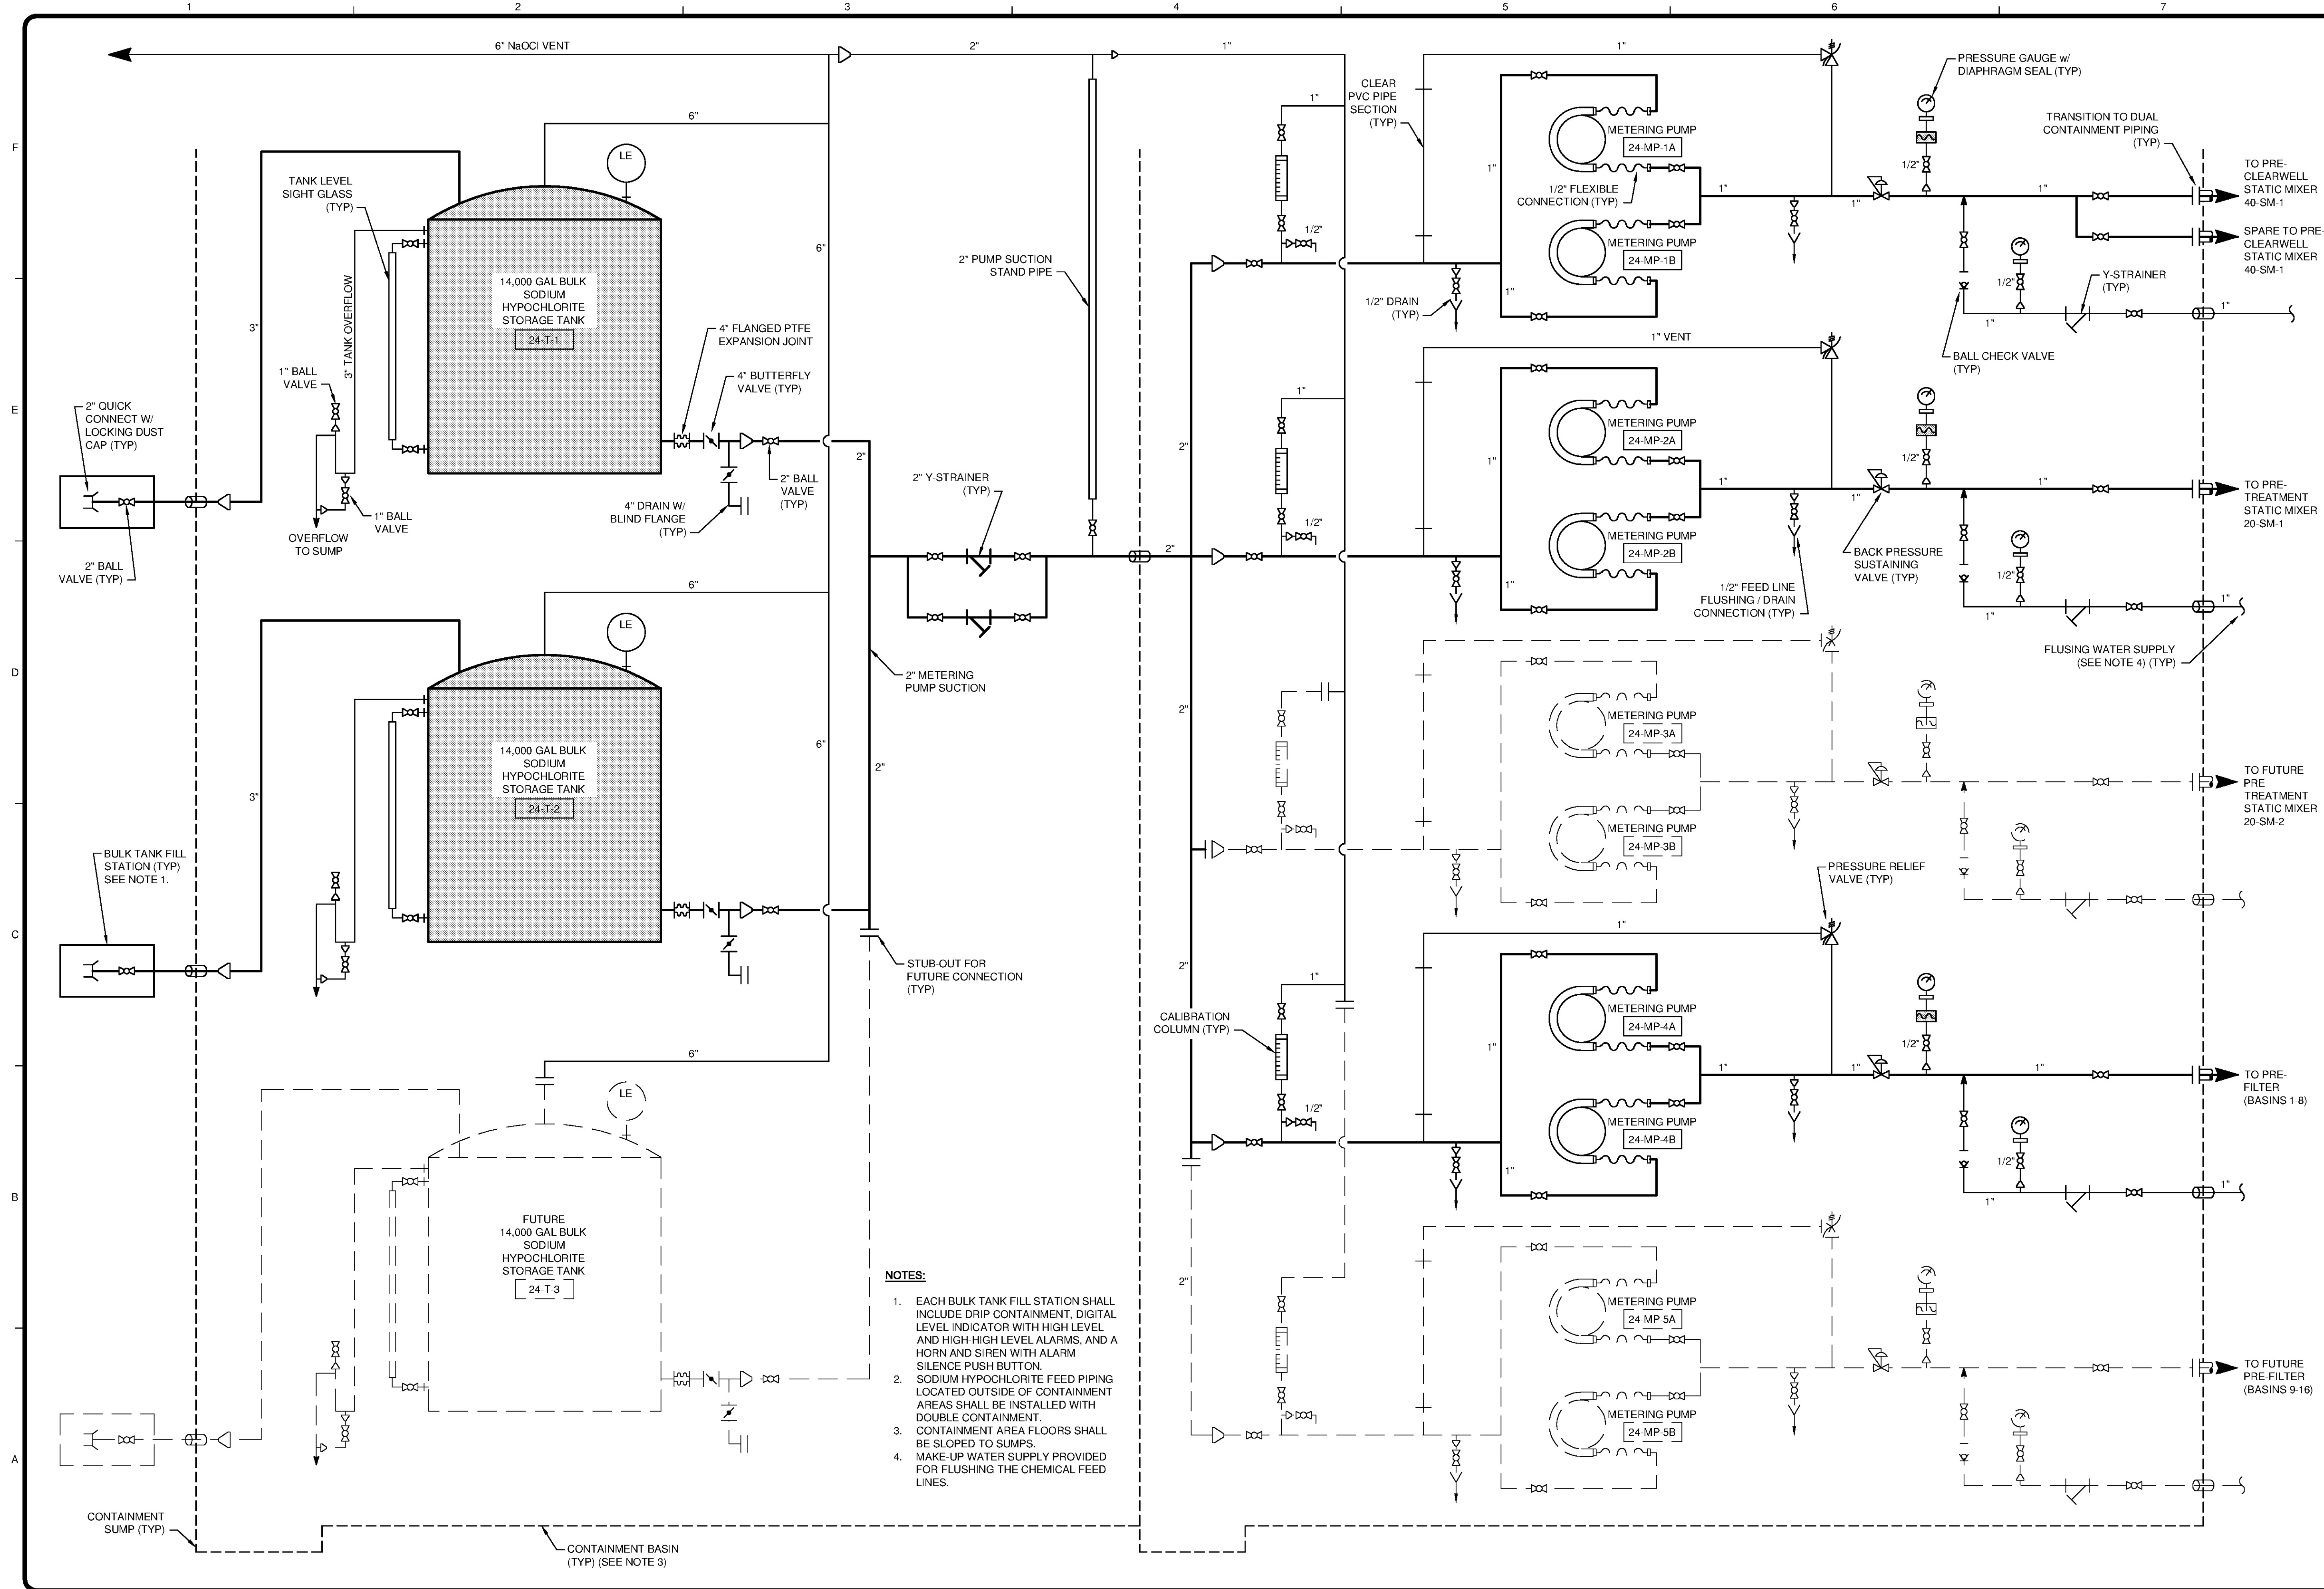


10/17/2014 3:46:39 PM P:\IER\11740200-11740-10003\CAD\SHEET\FILESTREATMENT PLANT\WTP-D-00XY PROCESS FLOW DIAGRAMS.DWG - EVANS, JON

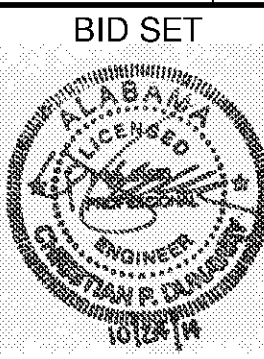

- NOTES:**
1. EACH BULK TANK FILL STATION SHALL INCLUDE DRIP CONTAINMENT, DIGITAL LEVEL INDICATOR WITH HIGH LEVEL AND HIGH-HIGH LEVEL ALARMS, AND A HORN AND SIREN WITH ALARM SILENCE PUSH BUTTON.
 2. SODIUM HYPOCHLORITE FEED PIPING LOCATED OUTSIDE OF CONTAINMENT AREAS SHALL BE INSTALLED WITH DOUBLE CONTAINMENT.
 3. CONTAINMENT AREA FLOORS SHALL BE SLOPED TO SUMPS.
 4. MAKE-UP WATER SUPPLY PROVIDED FOR FLUSHING THE CHEMICAL FEED LINES.

TETRA TECH		www.tetra-tech.com 101 QUALITY CIRCLE, SUITE 140 HUNTSVILLE, ALABAMA 35806 PHONE: (256) 424-4077 FAX: (256) 424-4097	
BID SET			
MARK	DATE	DESCRIPTION	BY
HUNTSVILLE UTILITIES SOUTHEAST WATER TREATMENT PLANT SODIUM HYPOCHLORITE FEED SYSTEM PROCESS PIPING SCHEMATIC			
Project No.: 200-11740-10003			
Designed By: JCB			
Drawn By: JTE			
Checked By: JEC			
D-2112		Copyright: Tetra Tech	
Bar Measures 1 inch			