



10/17/2014 3:46:51 PM P:\SERV\11740\200-11740-10003\CAD\SHEETFILES\TREATMENT PLANT\WTP-D-00X\PROCESS FLOW DIAGRAMS.DWG - EVANS, JON

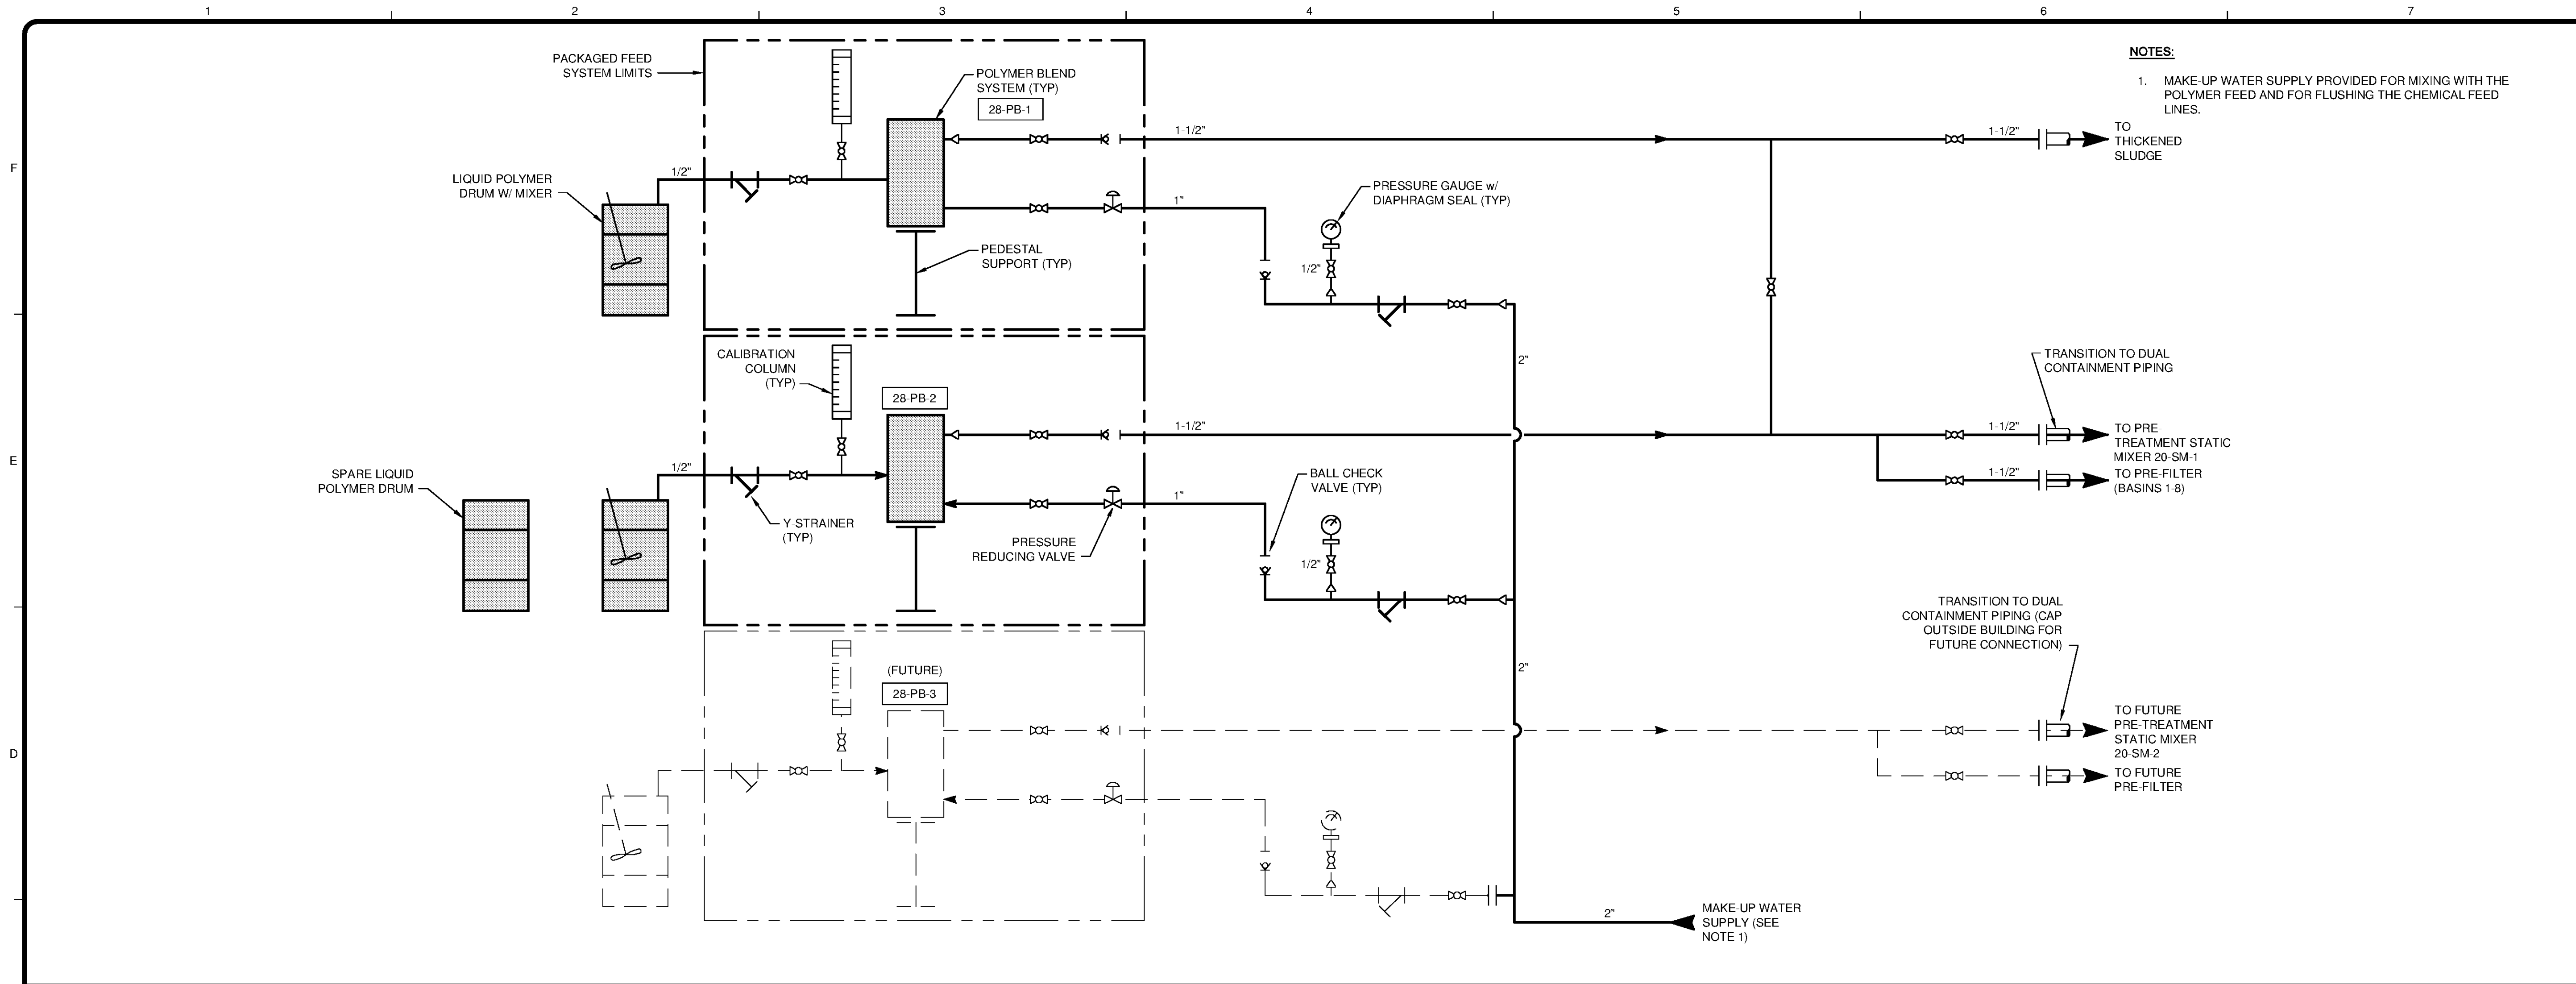

NOTES:

1. MAKE UP WATER SUPPLY PROVIDED FOR MIXING WITH THE POLYMER FEED AND FOR FLUSHING THE CHEMICAL FEED LINES.

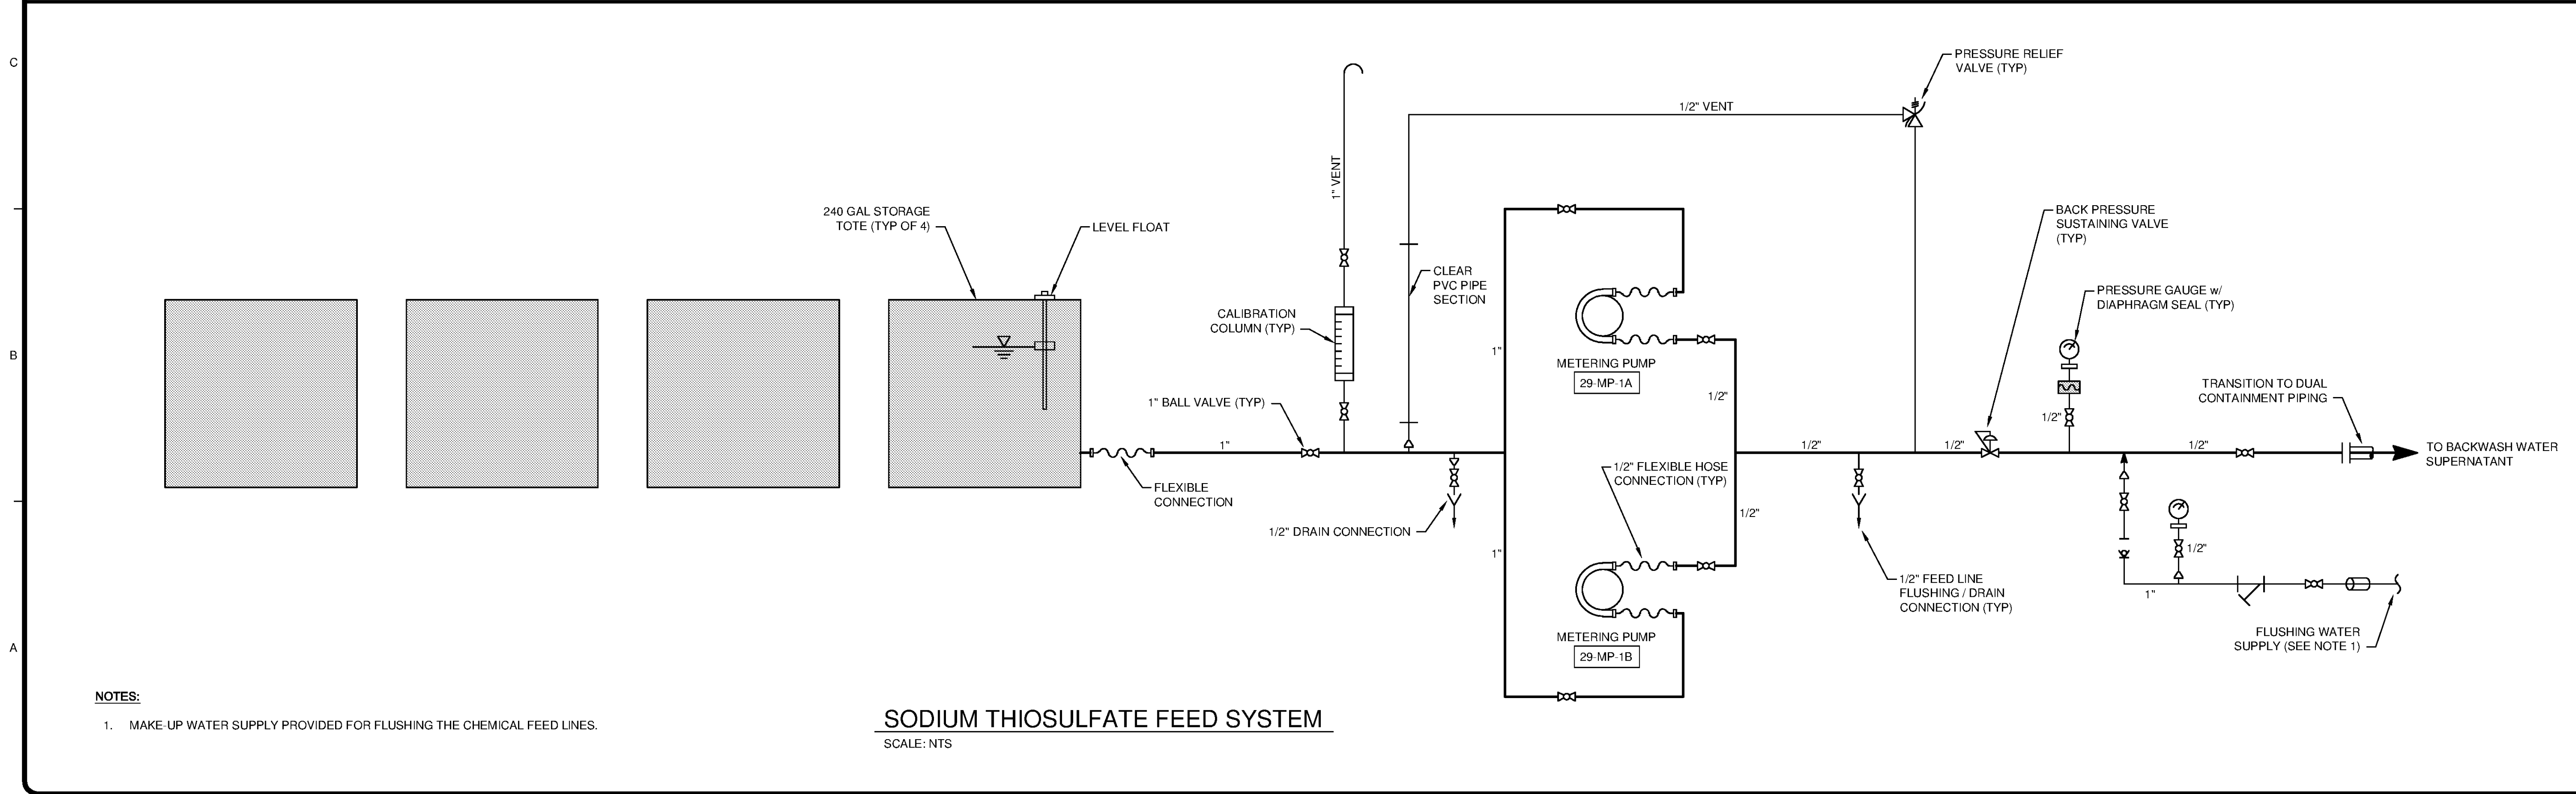

NOTES:

1. MAKE-UP WATER SUPPLY PROVIDED FOR FLUSHING THE CHEMICAL FEED LINES.

SODIUM THIOSULFATE FEED SYSTEM

SCALE: NTS

TETRA TECH

www.tetrattech.com

101 QUALITY CIRCLE, SUITE 140
HUNTSVILLE, ALABAMA 35806
PHONE: (256) 424-4077 FAX: (256) 424-4097

BID SET

BY

MARK

DATE

DESCRIPTION

HUNTSVILLE UTILITIES
SOUTHEAST WATER TREATMENT PLANT

POLYMER & SODIUM THIOSULFATE PROCESS PIPING SCHEMATIC

Project No.: 200-11740-10003
Designed By: JCB
Drawn By: JTE
Checked By: JEC

D-2120

Copyright: Tetra Tech

Bar Measures 1 inch