
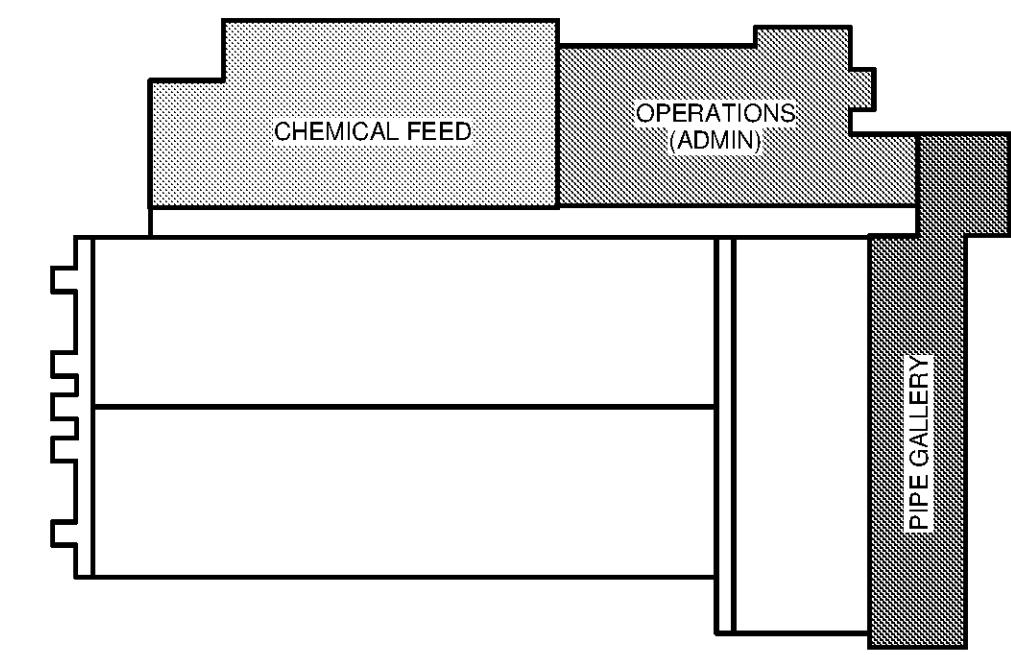


HVAC ROOF PLAN
SCALE: 1/16" = 1'-0"

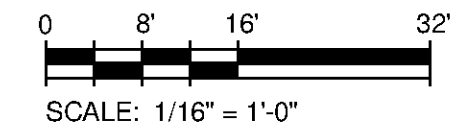

| MARK | DATE | DESCRIPTION | BY |
|------|------|-------------|----|
| | | | |
| | | | |
HUNTSVILLE UTILITIES
SOUTHEAST WATER TREATMENT PLANT
**MAIN PROCESS BUILDING
HVAC ROOF PLAN**

Project No.: 200-11740-10003
Designed By: SBR
Drawn By: SBR
Checked By: DSB

M-2107

TETRA TECH
www.tetra.tech.com
101 QUALITY CIRCLE, SUITE 140
HUNTSVILLE, ALABAMA 35895
PHONE: (256) 424-4077 FAX: (256) 424-4087

BID SET