


THICKENED SLUDGE PUMP STATION HVAC PLAN
 SCALE: 1/4" = 1'-0"

- KEYED NOTES:**
- 1 PROVIDE INSULATED BACKING ON ALL THERMOSTATS MOUNTED ON EXTERIOR WALLS.
 - 2 MOUNT ELECTRIC RADIANT HEATER AT OPTIMUM ANGLE TOWARD FLOOR TO MAXIMIZE FLOOR HEATING COVERAGE.

- GENERAL NOTES:**
- 1. SEE ARCHITECTURAL ELEVATIONS FOR LOUVER AND EXHAUST FAN PLACEMENT.
 - 2. ALL INTAKE LOUVERS SHALL BE PROVIDED WITH LOW-LEAKAGE MOTORIZED DAMPERS.

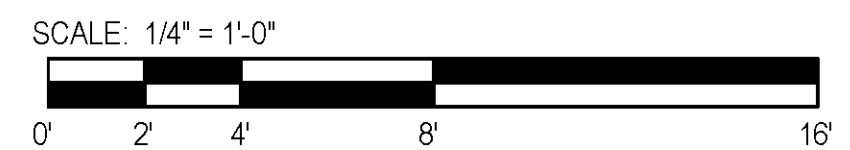

TETRA TECH

 www.tetratech.com
 101 QUALITY CIRCLE, SUITE 140
 HUNTSVILLE, ALABAMA 35895
 PHONE: (256) 424-4077 FAX: (256) 424-4097

BID SET

 DONALD S. BORER
 ENGINEER
 No. 16553
 PROFESSIONAL
 12/24/2014

MARK	DATE	DESCRIPTION	BY

HUNTSVILLE UTILITIES
 SOUTHEAST WATER TREATMENT PLANT
THICKENED SLUDGE PUMP STATION HVAC PLAN

Project No.: 200-11740-10003
 Designed By: SBR
 Drawn By: SBR
 Checked By: DSB

M-5101