
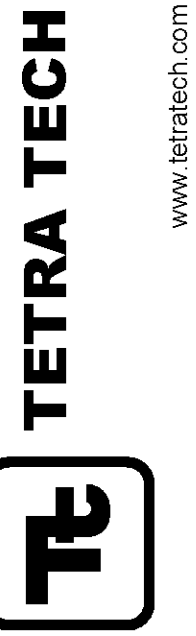



**GENERATOR BUILDING HVAC ROOF PLAN**

SCALE: 1/8" = 1'-0"

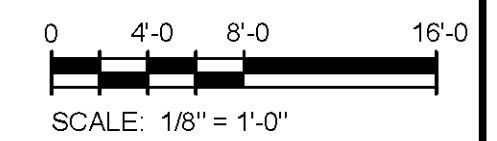

**TETRA TECH**  
www.tetrattech.com  
101 QUALITY CIRCLE, SUITE 140  
HUNTSVILLE, ALABAMA 35895  
PHONE: (256) 424-4077 FAX: (256) 424-4097

BID SET

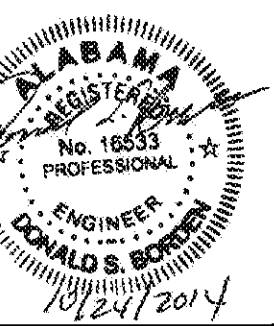

MARK	DATE	DESCRIPTION	BY

HUNTSVILLE UTILITIES  
SOUTHEAST WATER TREATMENT PLANT  
**GENERATOR BUILDING  
HVAC ROOF PLAN**

Project No.: 200-11740-10003  
Designed By: SBR  
Drawn By: MEL  
Checked By: DSB

**M-8102**