
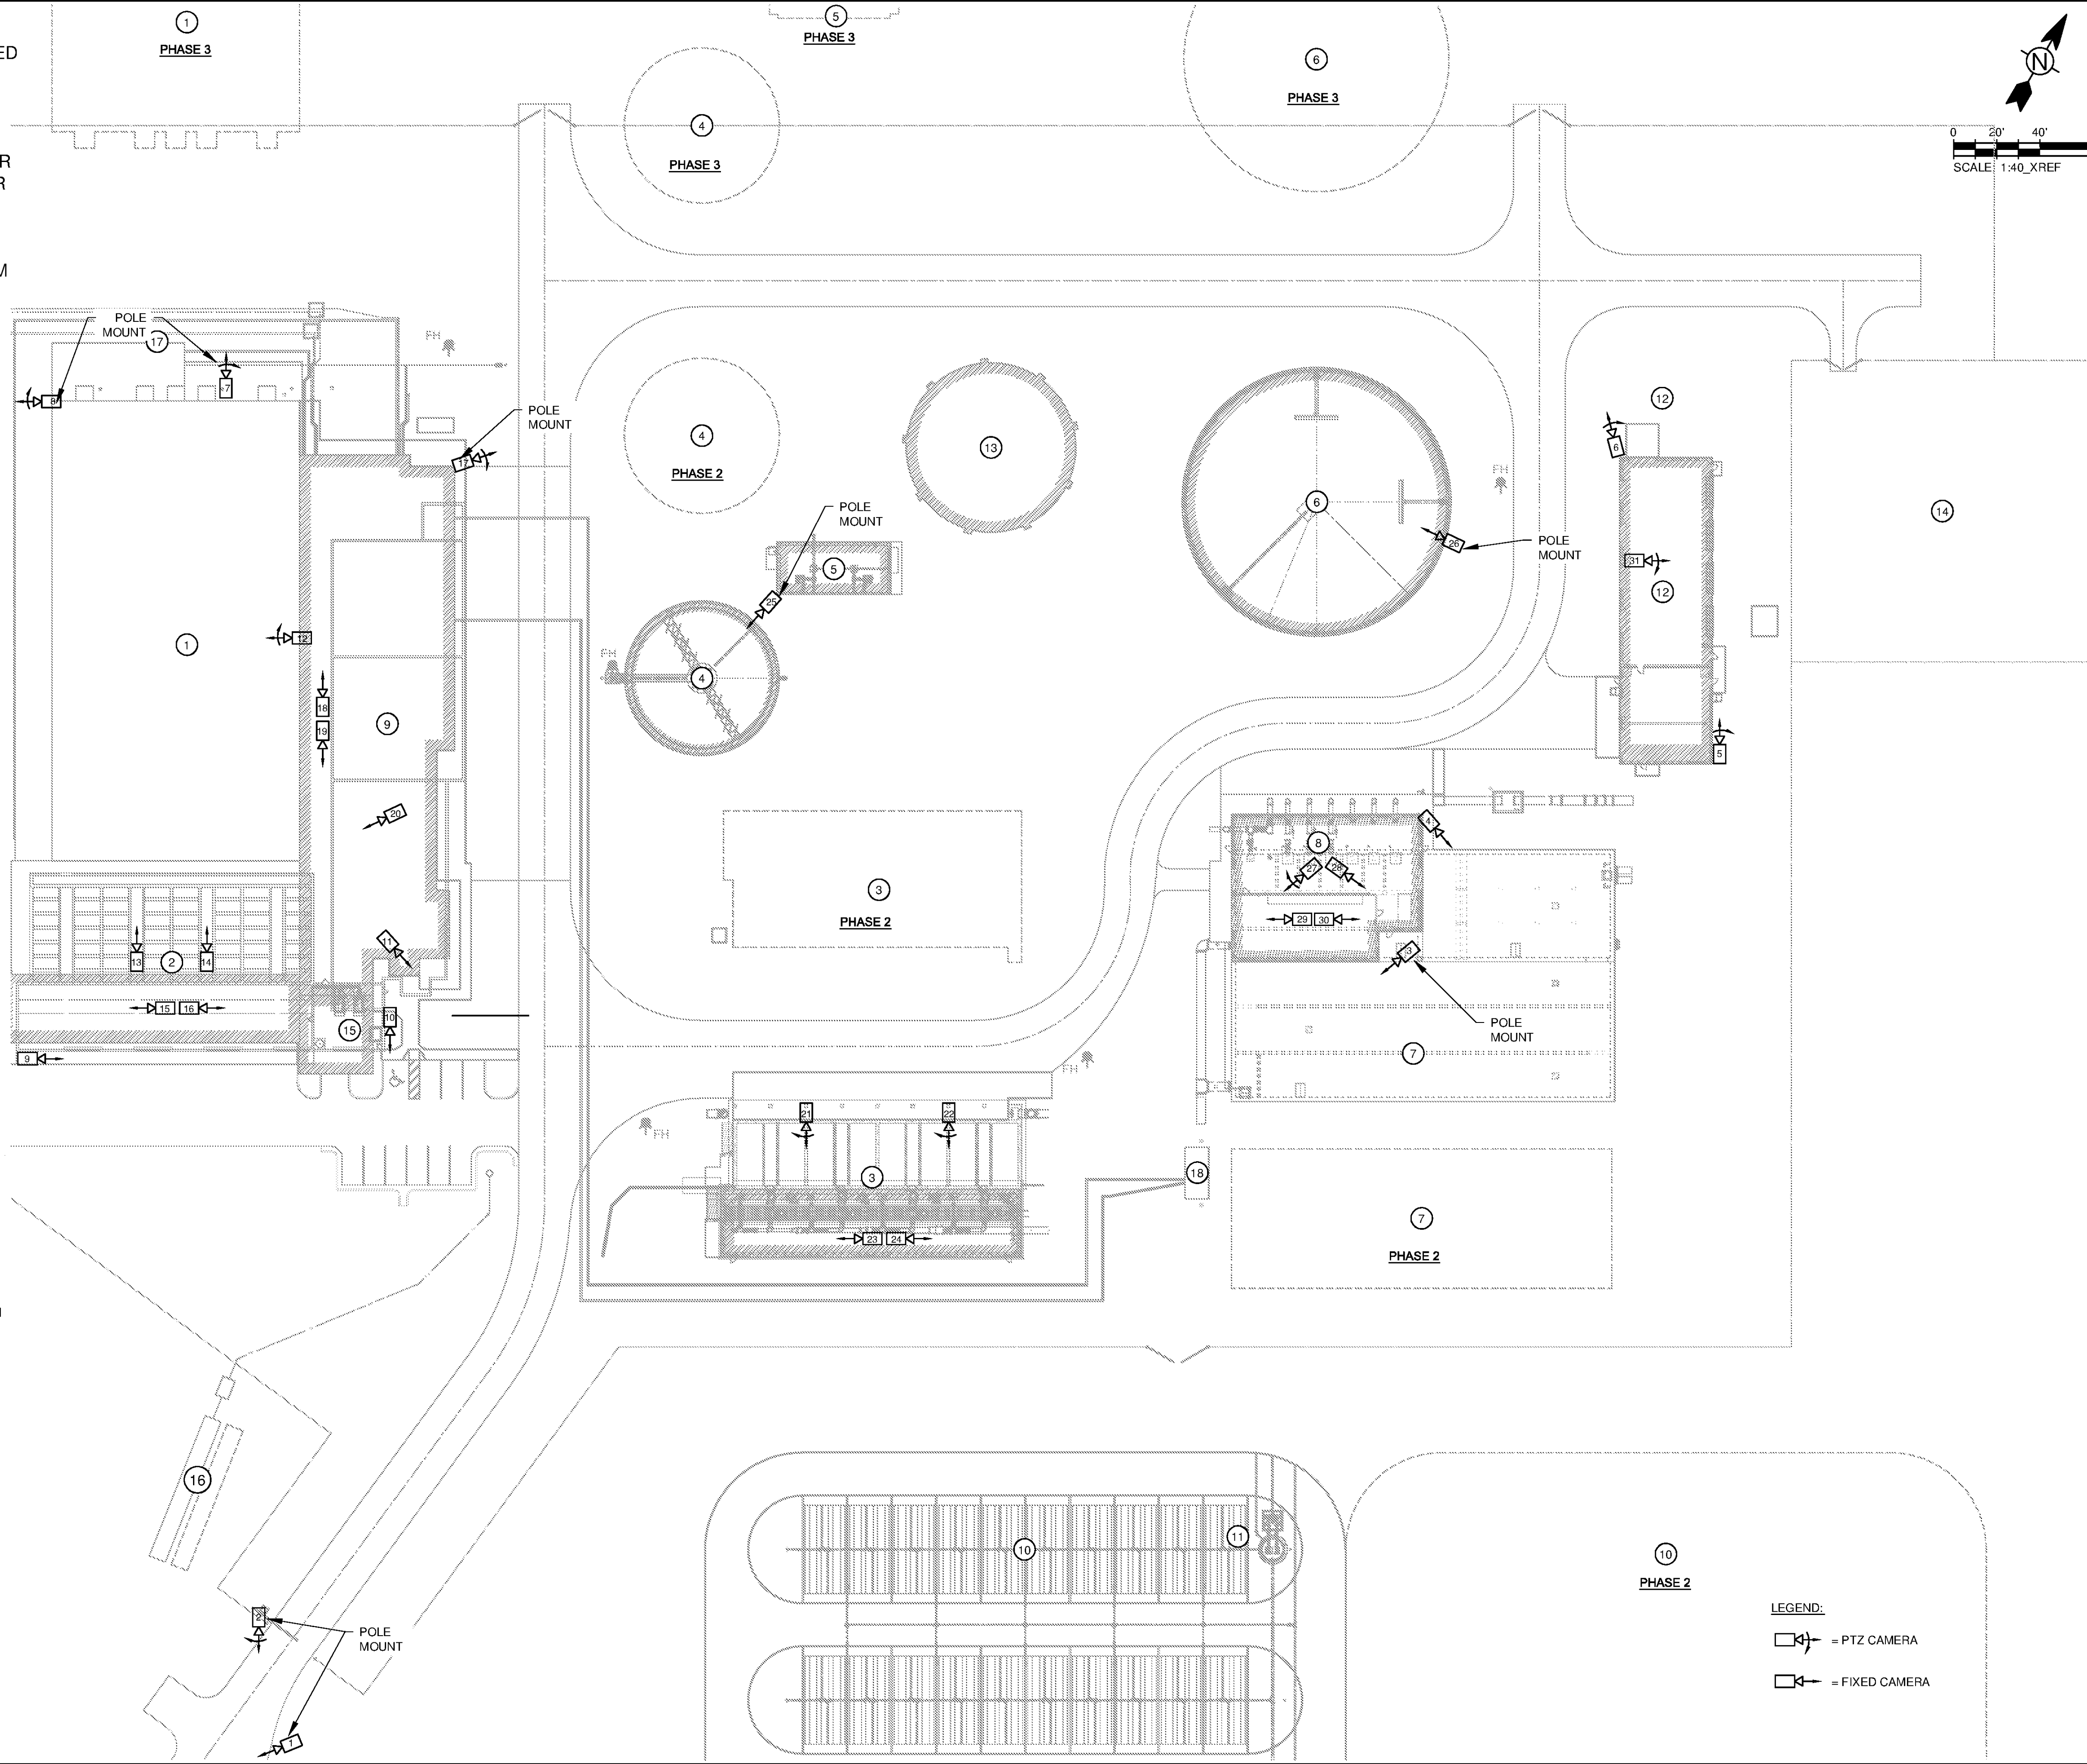


10/17/2014 10:51:48 AM - P:\IER\11740\200-11740-10003\CAD\SHEETFILES\TREATMENT PLANT\WP E-0107 SECURITY SITE PLAN.DWG - CALZARETTA, TIMOTHY

THE FOLLOWING ITEMS ARE NOT INCLUDED IN THE SCOPE OF WORK:

- WIRE/CABLE
- CAMERA (CONTRACTOR TO PROVIDE 4"X4" WEATHER TIGHT GANG BOX)
- MOUNTING HARDWARE (CONTRACTOR TO PROVIDE 24' POLE WITH BASE FOR POLE MOUNTED UNITS)
- COMPUTER/SERVER/RECORDER
- DISPLAY SCREENS
- CONFIGURATION OF CAMERA SYSTEM

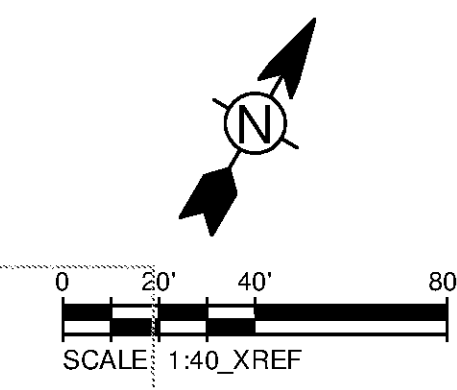

STRUCTURE LEGEND

- ① FLOCCULATION / SEDIMENTATION BASINS
- ② FILTERS
- ③ CARBON CONTACTORS
- ④ SLUDGE THICKENER
- ⑤ THICKENED SLUDGE / RECYCLE PUMP STATION
- ⑥ WASHWATER RECOVERY BASIN
- ⑦ FINISHED WATER STORAGE BASIN
- ⑧ FINISHED WATER PUMP STATION
- ⑨ CONTROL / CHEMICAL BUILDING
- ⑩ SLUDGE DRYING BEDS
- ⑪ SLUDGE FILTRATE PUMP STATION
- ⑫ GENERATOR BUILDING
- ⑬ ELEVATED WASHWATER STORAGE TANK
- ⑭ ELECTRIC SUBSTATION
- ⑮ BLOWER ROOM
- ⑯ ON-SITE SEWAGE TREATMENT AND DISPOSAL
- ⑰ PRE-TREATMENT STATIC MIXER
- ⑱ POST-TREATMENT STATIC MIXER

LEGEND:

- ☐➤ = PTZ CAMERA
- ☐• = FIXED CAMERA

TETRA TECH
www.tetrattech.com
101 QUALITY CIRCLE, SUITE 140
HUNTSVILLE, ALABAMA 35806
PHONE: (256) 424-4077 FAX: (256) 424-4097

BID SET
ALABAMA PROFESSIONAL ENGINEERING
No. 21939
PROFESSIONAL ENGINEER
1975
10 ANDRUS BLVD
HUNTSVILLE, ALABAMA 35894

MARK	DATE	DESCRIPTION	BY

HUNTSVILLE UTILITIES
SOUTHEAST WATER TREATMENT PLANT
SECURITY PLAN - SITE

Project No.: 200-11740-10003
Designed By: CSW
Drawn By: CSW
Checked By: DAB

E-0107