



10/17/2014 10:53:22 AM - P:\IER\11740\200-11740-10003\CAD\SHEETFILES\TREATMENT PLANT\WTP E 0109 LIGHTING SITE PLANDWG - CALZARETTA, TIMOTHY

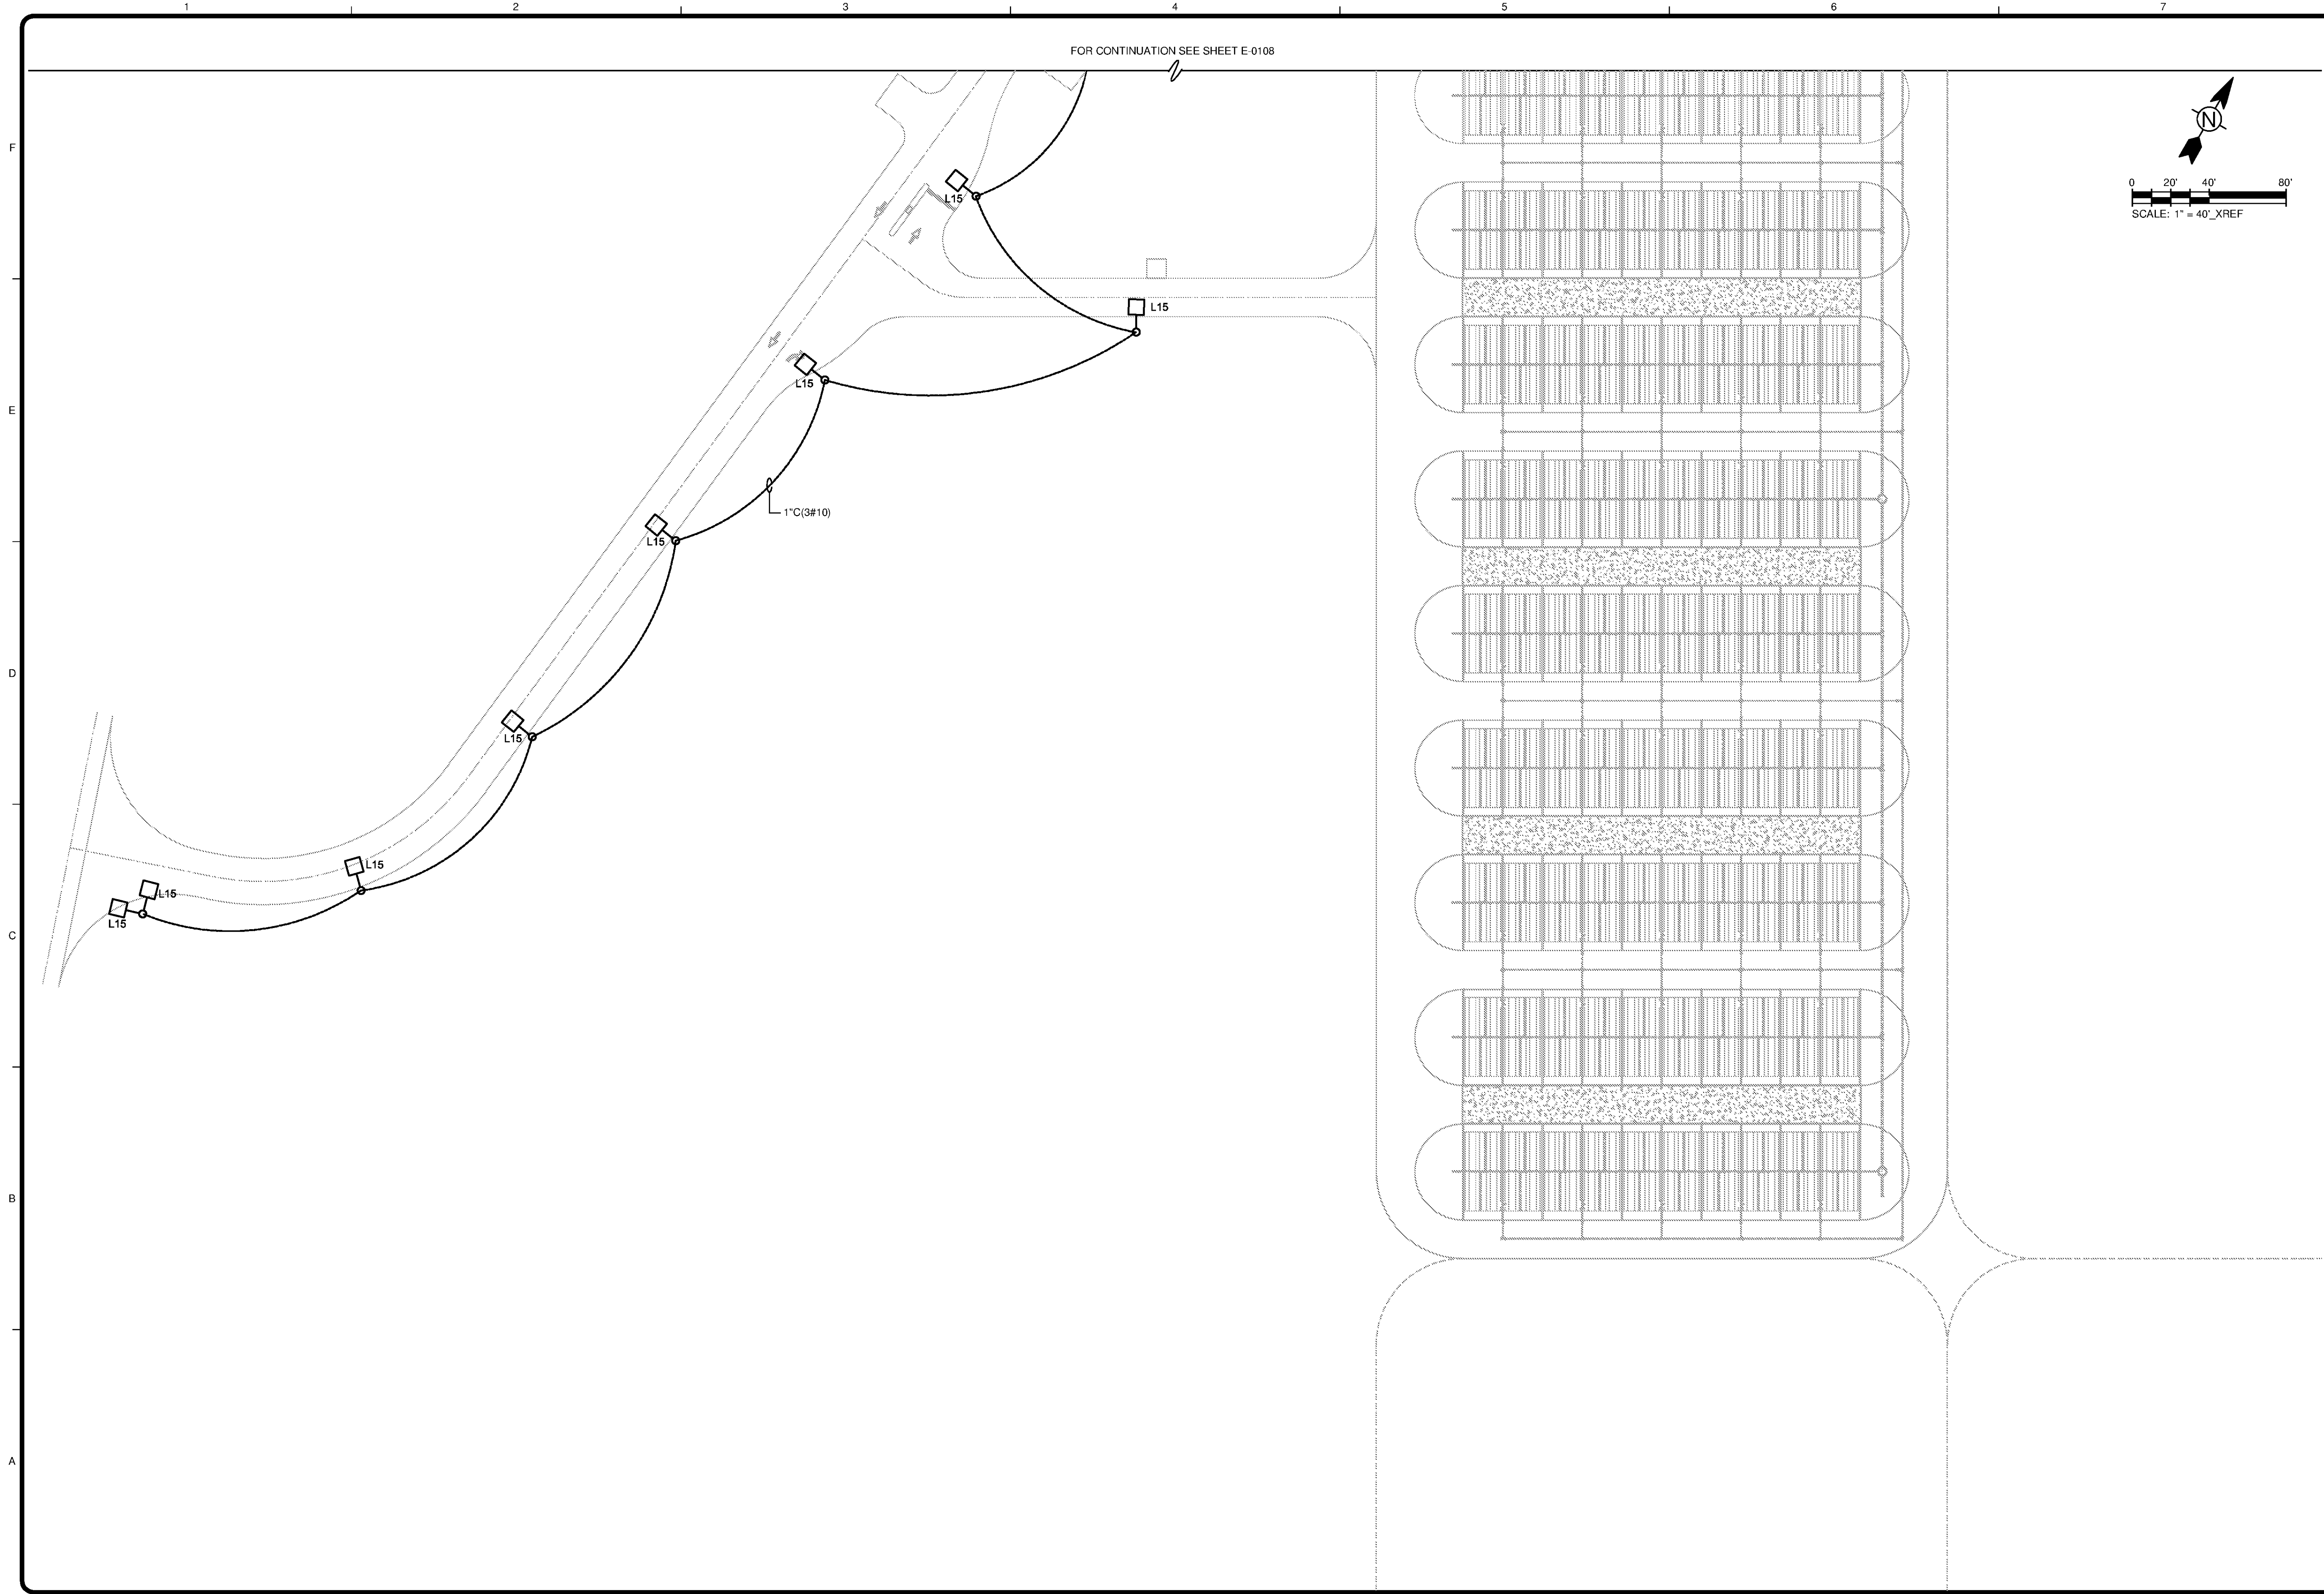

FOR CONTINUATION SEE SHEET E-0108

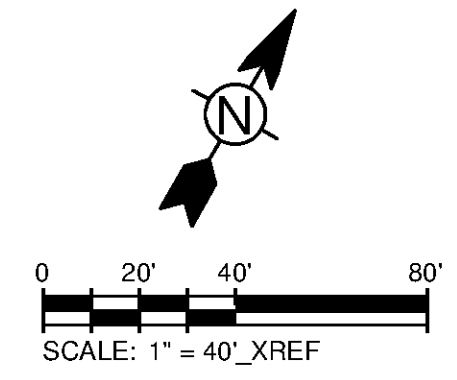

**TETRA TECH**  
www.tetrattech.com  
101 QUALITY CIRCLE, SUITE 140  
HUNTSVILLE, ALABAMA 35806  
PHONE: (256) 424-4077 FAX: (256) 424-4097

BID SET  
ALABAMA  
No. 21638  
PROFESSIONAL  
10/25/14  
TIMOTHY CALZARETTA  
REGISTERED PROFESSIONAL ENGINEER

MARK	DATE	DESCRIPTION	BY

HUNTSVILLE UTILITIES  
SOUTHEAST WATER TREATMENT PLANT  
LIGHTING  
SOUTH SITE PLAN

Project No.: 200-11740-10003  
Designed By: CSW  
Drawn By: TAC  
Checked By: DAB

**E-0109**

Copyright: Tetra Tech  
Bar Measures 1 inch