

TETRA TECH

www.tetratex.com

101 QUALITY CIRCLE, SUITE 140
HUNTSVILLE, ALABAMA 35806
PHONE: (256) 424-4077 FAX: (256) 424-4097

BID SET

ALABAMA
LICENSED PROFESSIONAL ENGINEER

BY	DATE	DESCRIPTION

MARK	DATE	DESCRIPTION

HUNTSVILLE UTILITIES
SOUTHEAST WATER TREATMENT PLANT




**ELECTRICAL PLAN -
FILTERS**

Project No.: 200-11740-10003
Designed By: CSW
Drawn By: CSW
Checked By: DAB

E-2402

Copyright Tetra Tech
Bar Measures 1 inch

10/17/2014 10:56:50 AM - P:\ER11740\200-11740-10003\CAD\FILES\TREATMENT PLANT\WTP E-2401_E-2404 MAIN PROCESS BUILDING.DWG - CALZARETTA, TIMOTHY

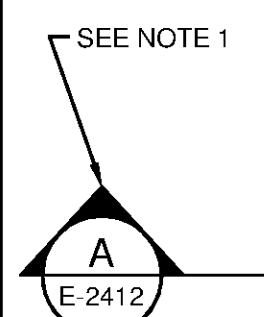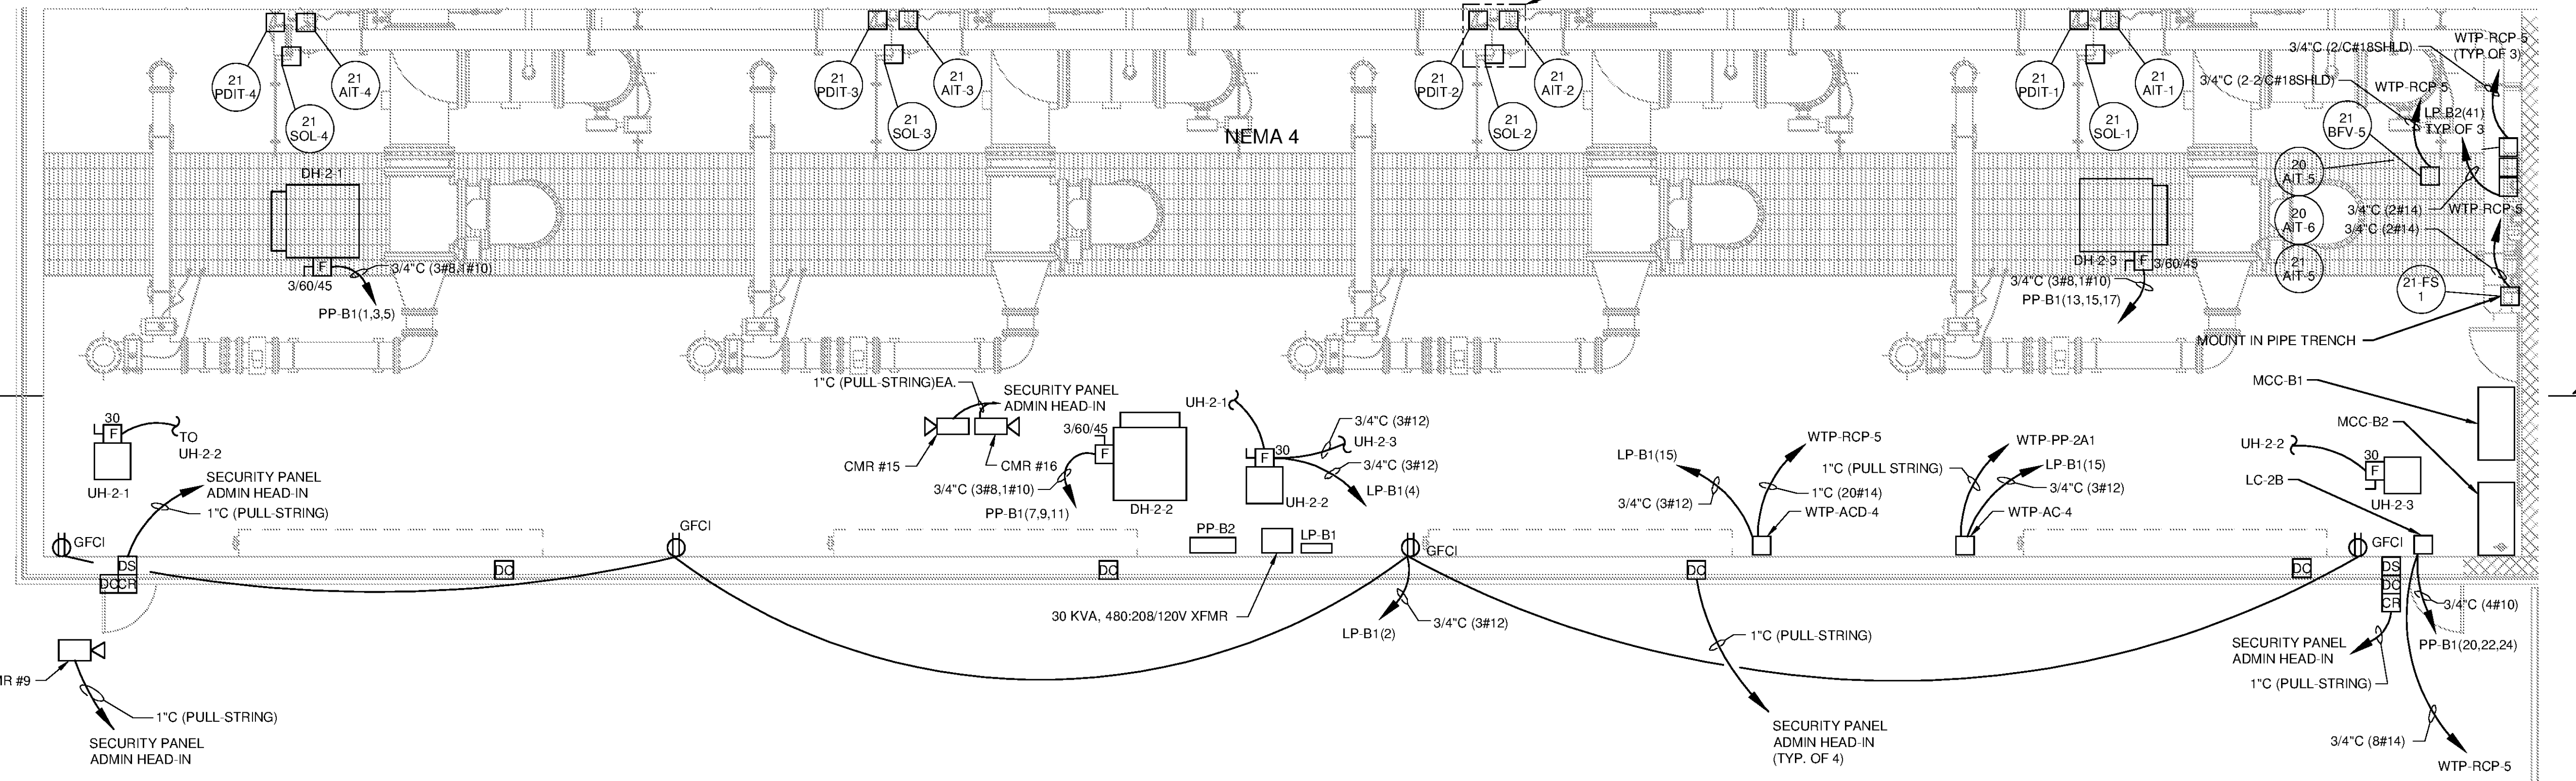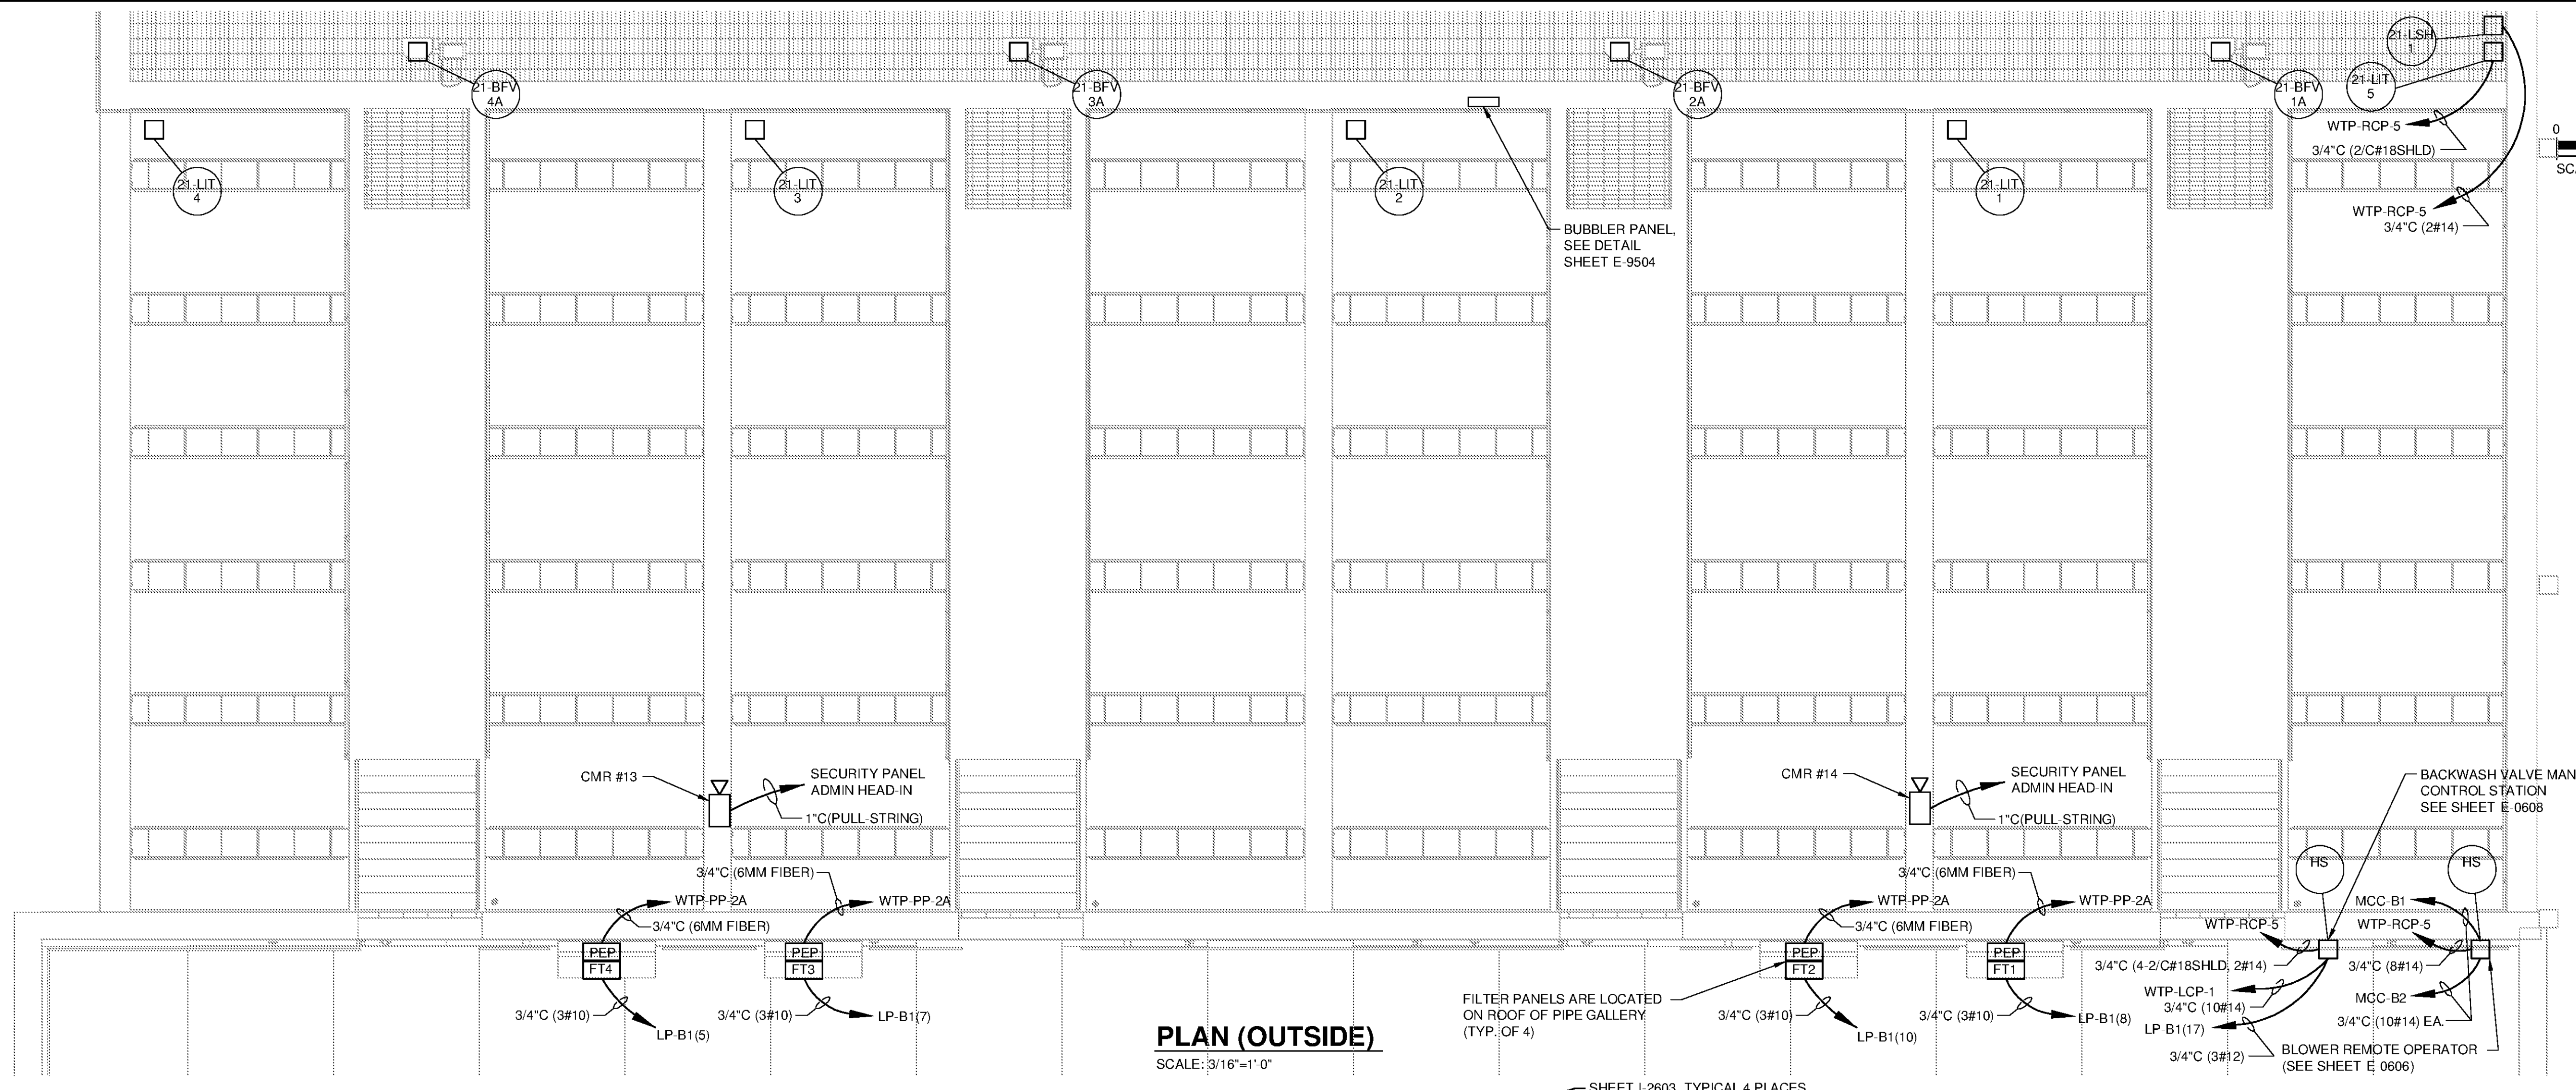

BUBBLER PANEL, SEE DETAIL SHEET E-9504

FILTER PANELS ARE LOCATED ON ROOF OF PIPE GALLERY (TYP. OF 4)

SHEET I-2603, TYPICAL 4 PLACES

PLAN (OUTSIDE)
SCALE: 3/16"=1'-0"

PLAN (INSIDE PIPE GALLERY)
SCALE: 3/16"=1'-0"