



10/17/2014 10:57:23 AM P:\SERV1\740\200-11740-10003\CAD\SHEETFILES\TREATMENT PLANT\WP E-2406 LIGHTING PLAN CHEMICAL FEED ROOM.DWG CALZARETTA, TIMOTHY

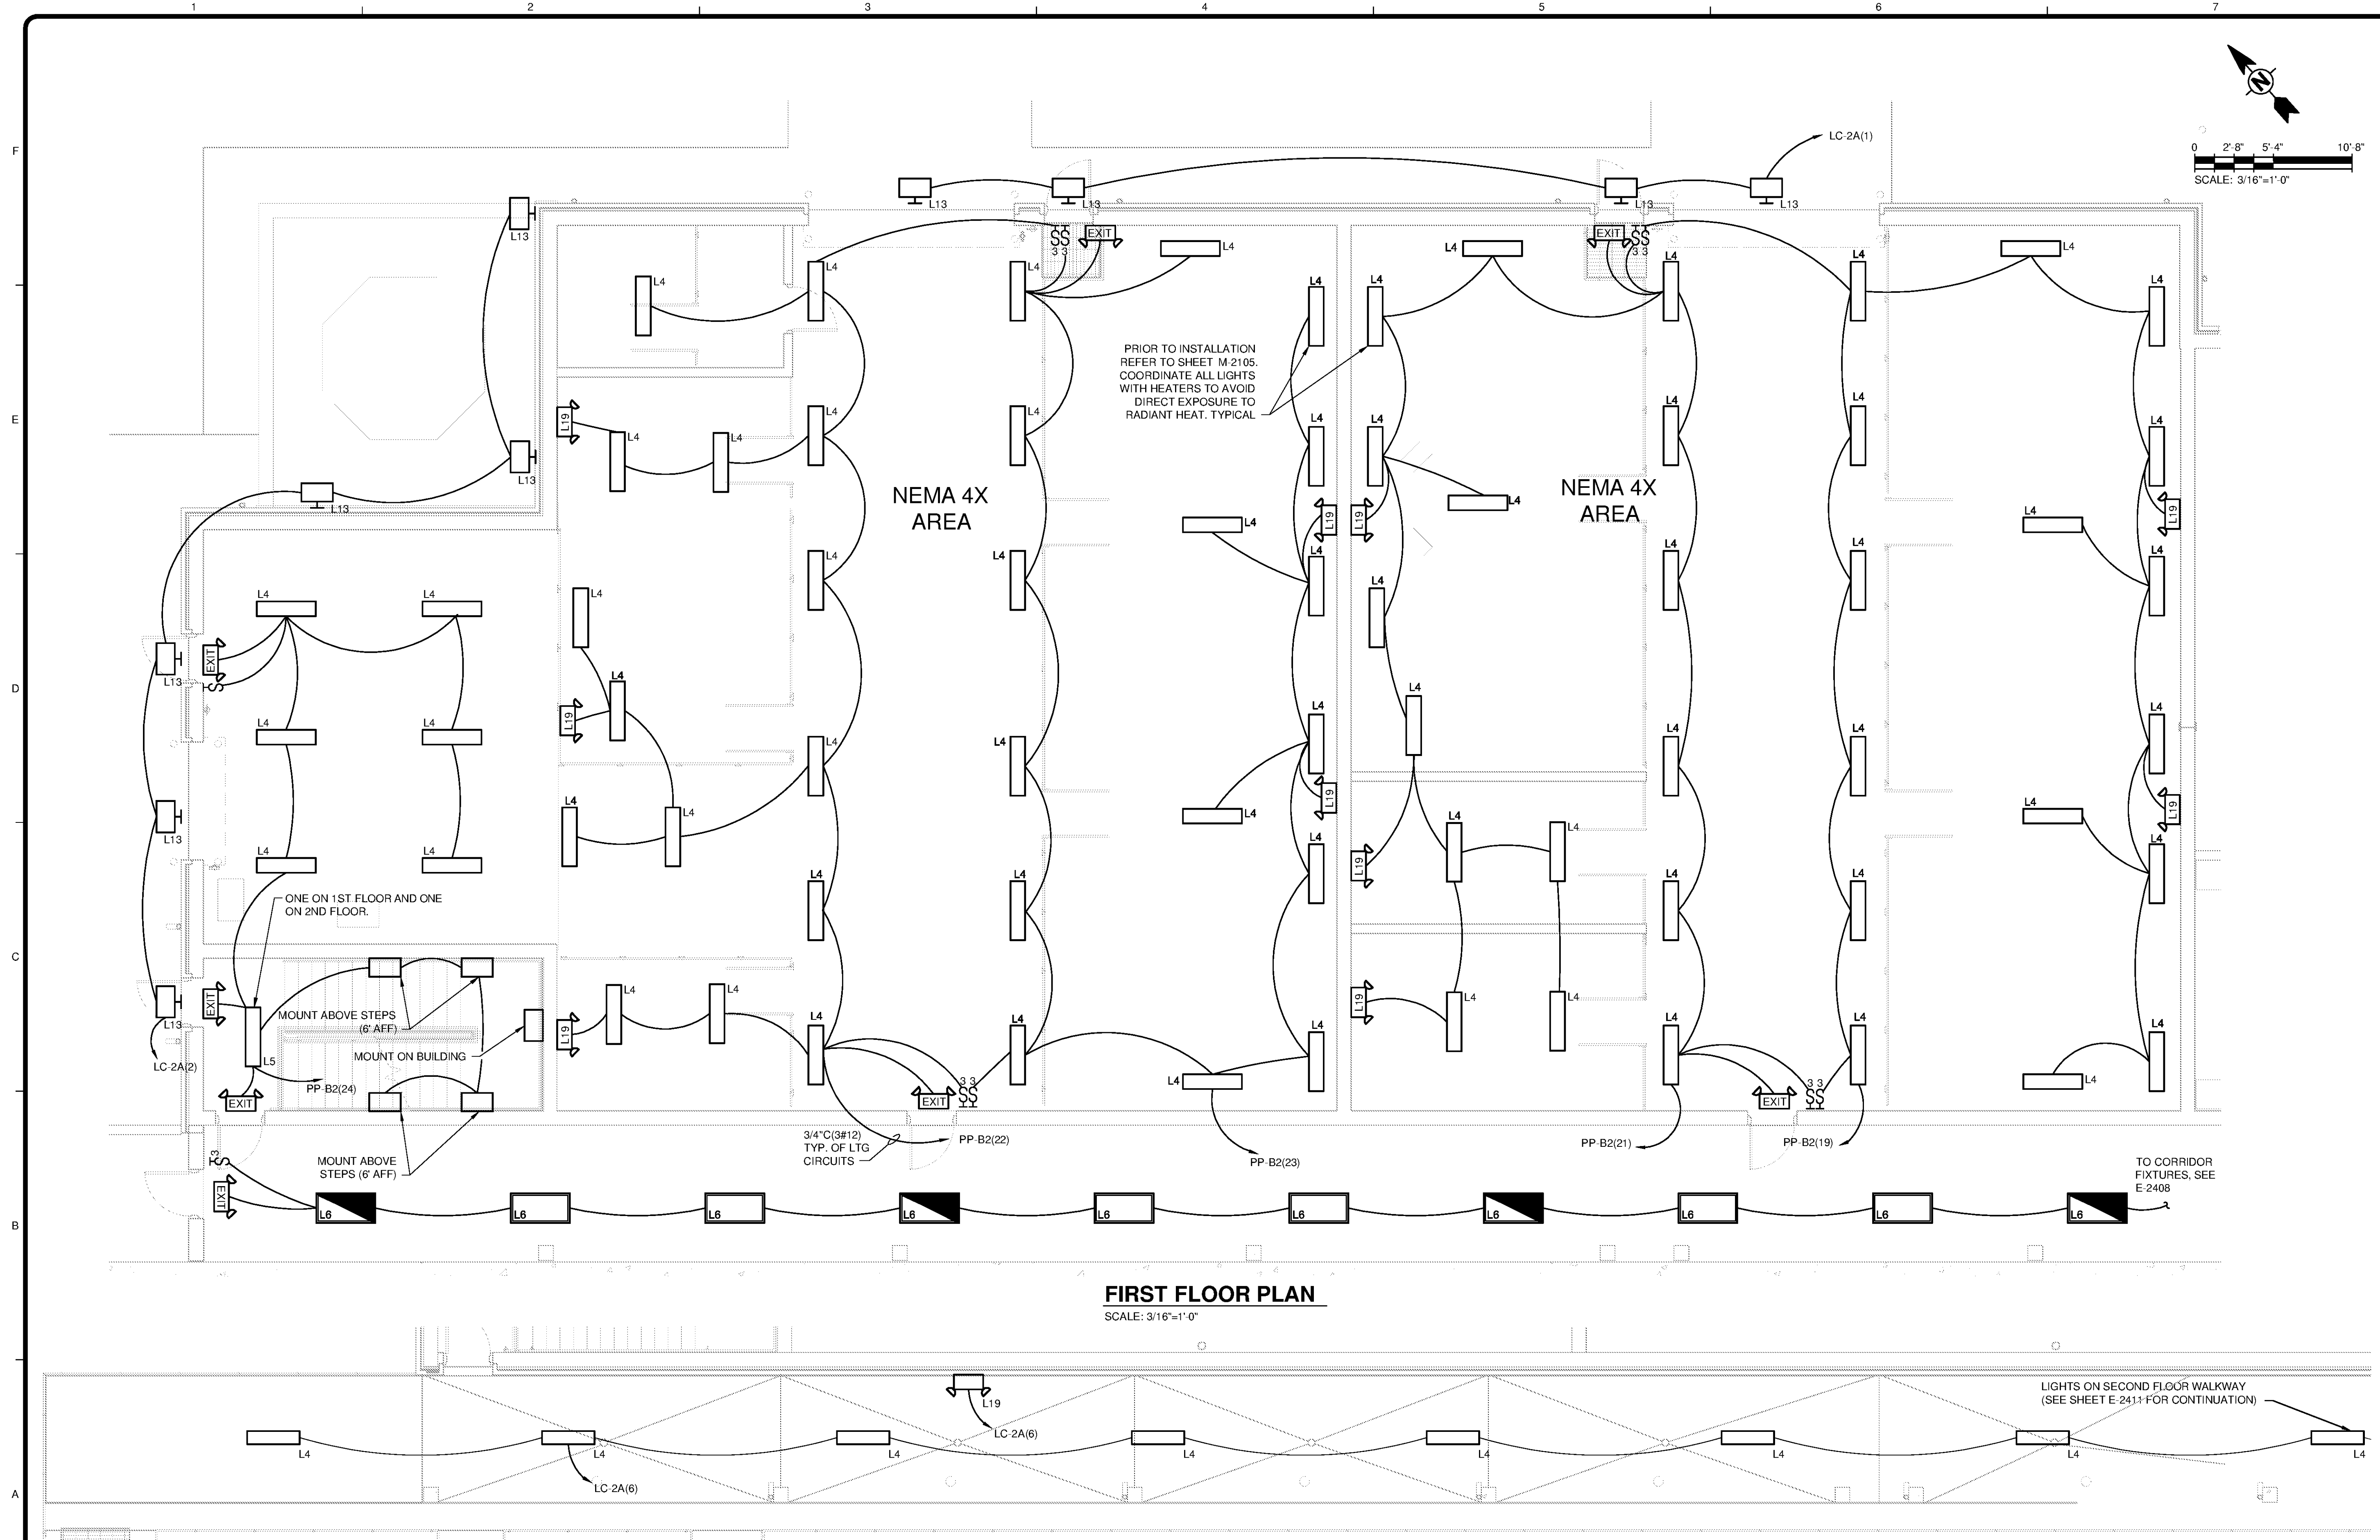

FIRST FLOOR PLAN
SCALE: 3/16"=1'-0"

SECOND FLOOR CORRIDOR PLAN
SCALE: 3/16"=1'-0"

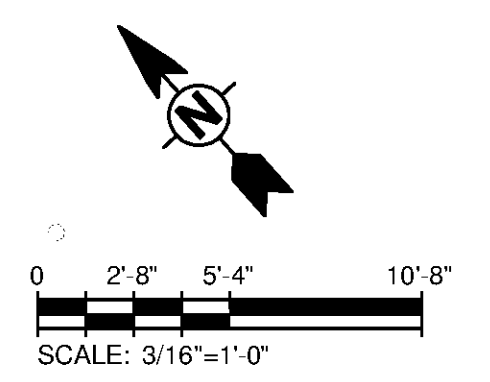

TETRA TECH
www.tetrattech.com
101 QUALITY CIRCLE, SUITE 140
HUNTSVILLE, ALABAMA 35806
PHONE: (256) 424-4077 FAX: (256) 424-4097

BID SET

| MARK | DATE | DESCRIPTION | BY |
|------|------|-------------|----|
| | | | |
| | | | |
HUNTSVILLE UTILITIES
SOUTHEAST WATER TREATMENT PLANT
**LIGHTING PLAN -
CHEMICAL FEED ROOM**

Project No.: 200-11740-10003
Designed By: CSW
Drawn By: TAC
Checked By: DAB

E-2406

NOTES:
1. INSTALL FIRE STOPPING ON WALL PENETRATIONS.