


10/17/2014 10:57:41 AM - P:\IER11740\200-11740-10003\CAD\SHEETFILES\TREATMENT PLANT\WTP-E-2408 LIGHTING PLAN - MAIN PROCESS 1ST FLOOR.DWG - CALZARETTA, TIMOTHY

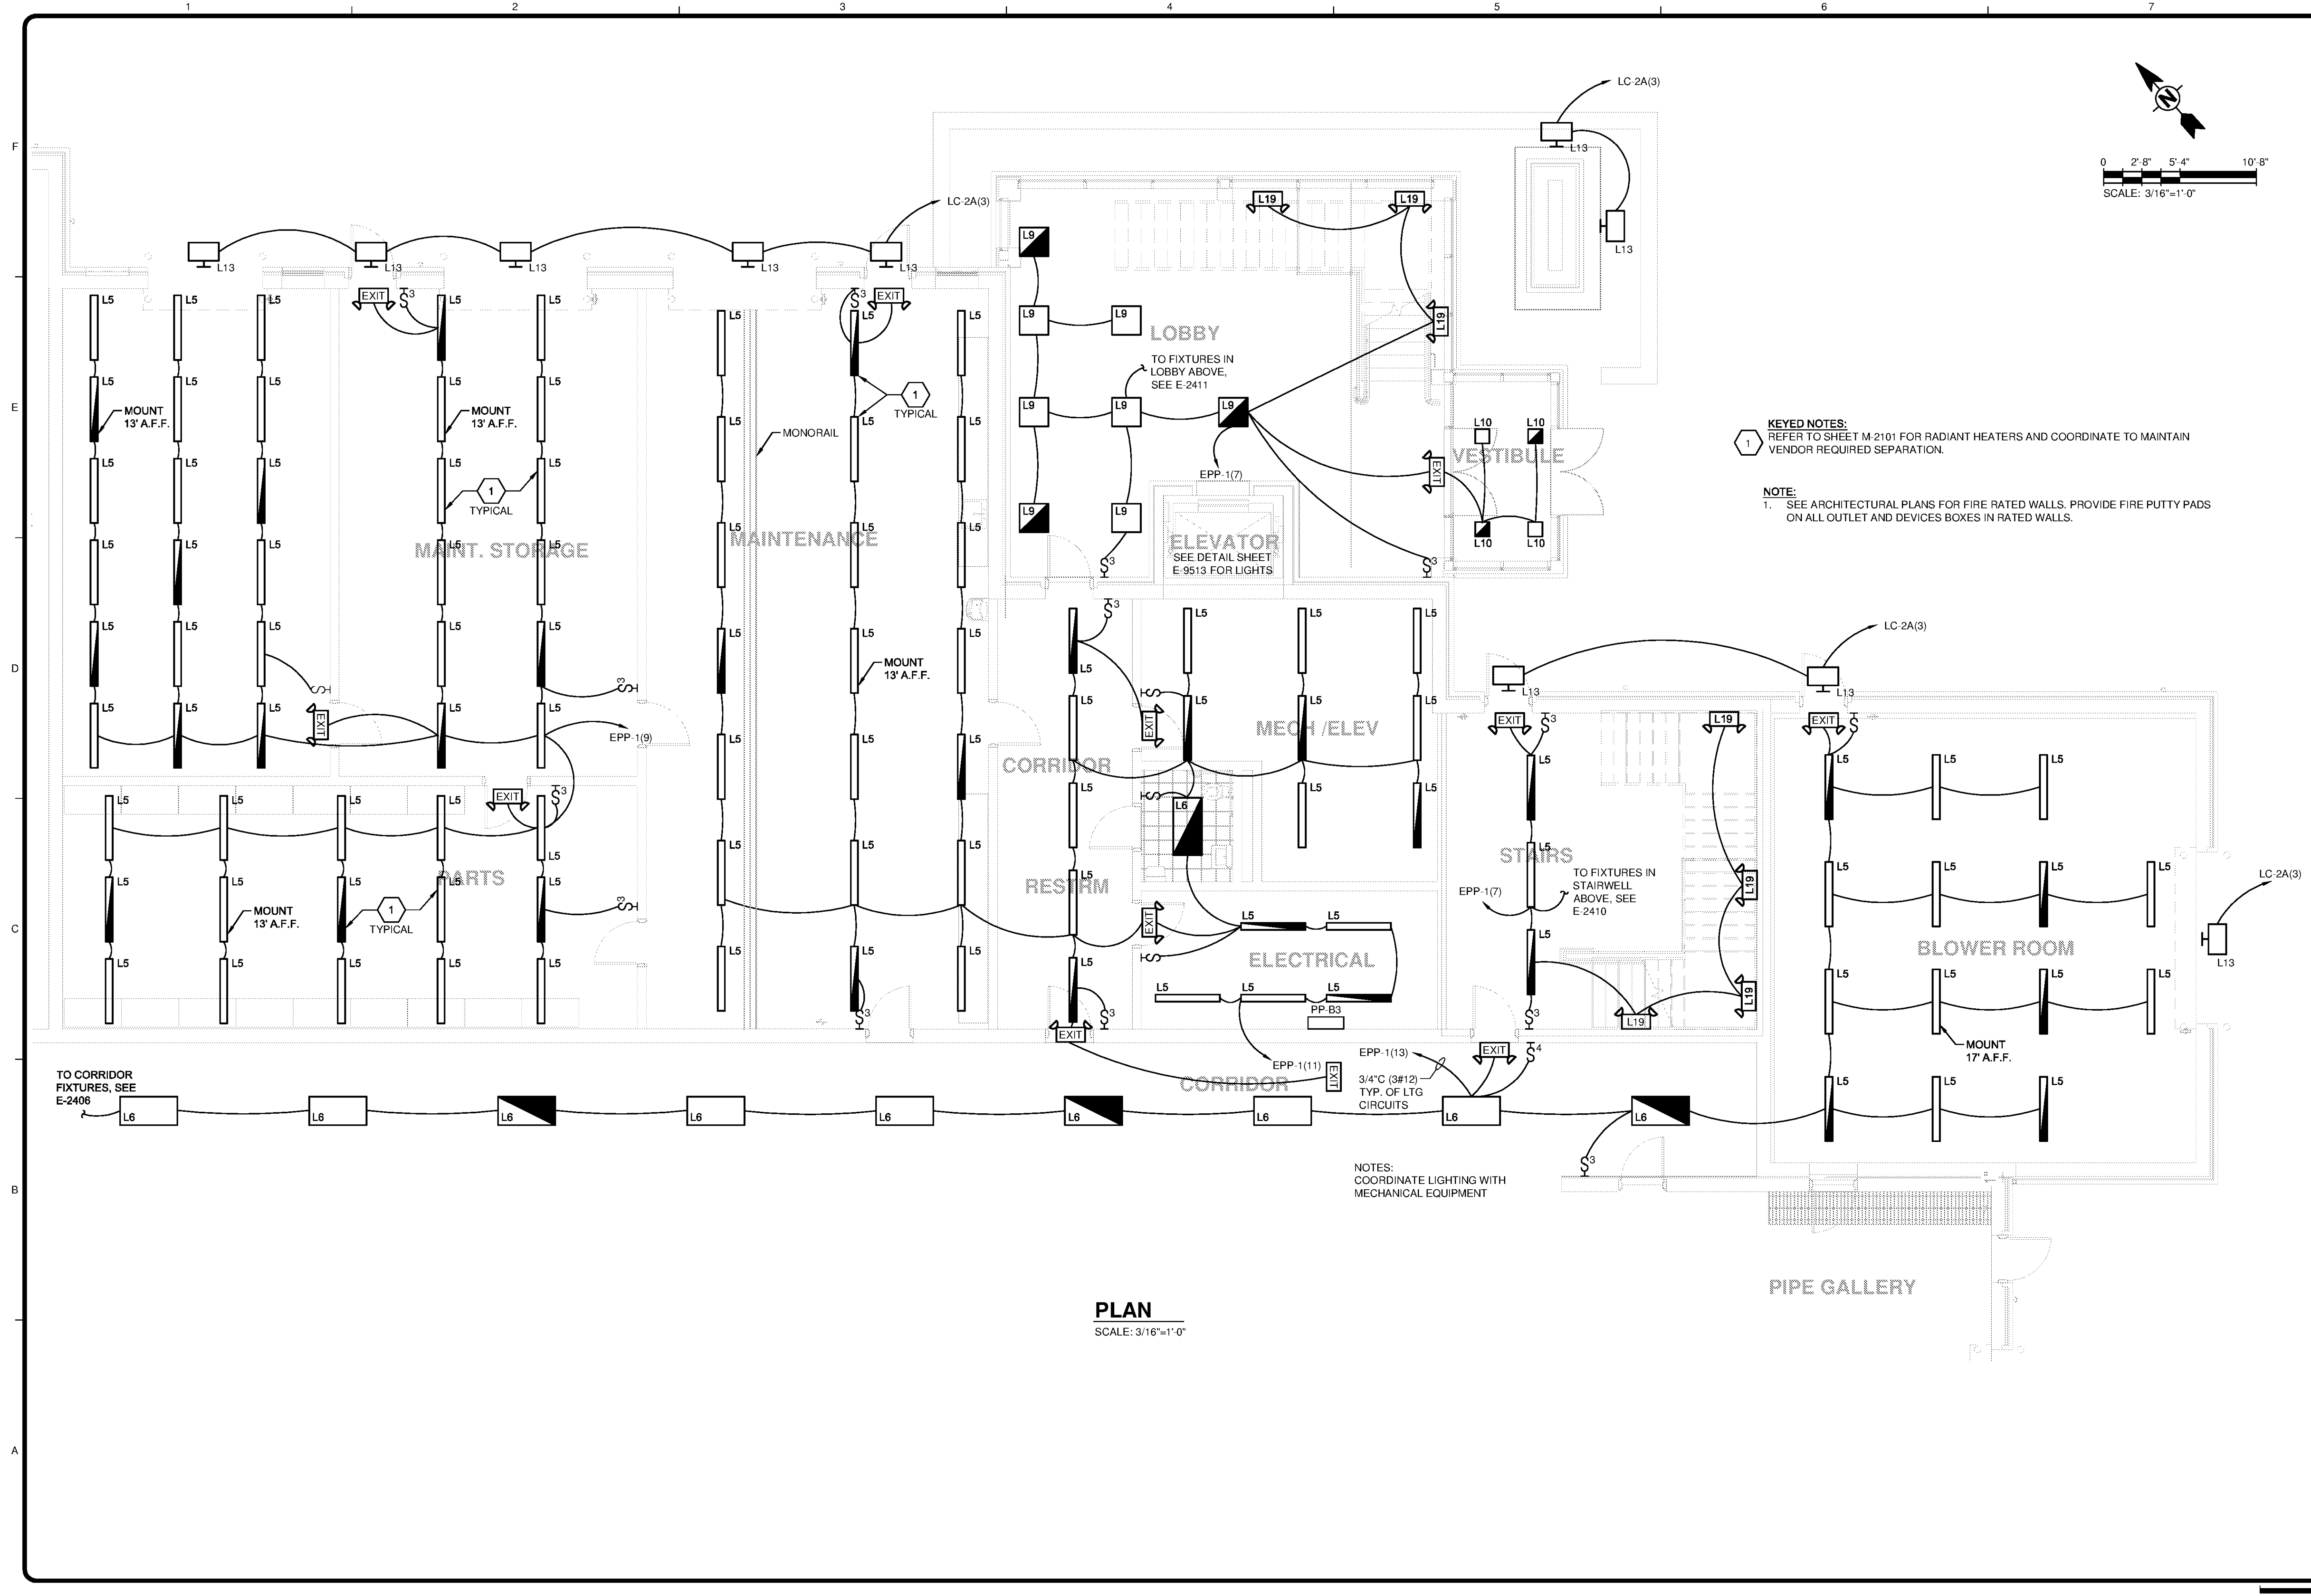

KEYED NOTES:
 REFER TO SHEET M-2101 FOR RADIANT HEATERS AND COORDINATE TO MAINTAIN VENDOR REQUIRED SEPARATION.

NOTE:
 1. SEE ARCHITECTURAL PLANS FOR FIRE RATED WALLS. PROVIDE FIRE PUTTY PADS ON ALL OUTLET AND DEVICES BOXES IN RATED WALLS.

NOTES:
 COORDINATE LIGHTING WITH MECHANICAL EQUIPMENT

PLAN
 SCALE: 3/16"=1'-0"

TETRA TECH

www.tetrattech.com
 101 QUALITY CIRCLE, SUITE 140
 HUNTSVILLE, ALABAMA 35806
 PHONE: (256) 424-4077 FAX: (256) 424-4097

BID SET

BY

MARK

DATE

DESCRIPTION

HUNTSVILLE UTILITIES
 SOUTHEAST WATER TREATMENT PLANT

LIGHTING PLAN -
 MAIN PROCESS 1ST FLOOR

Project No.: 200-11740-10003

Designed By: CSW

Drawn By: TAC

Checked By: DAB

E-2408

Copyright: Tetra Tech
 Bar Measures 1 inch