




10/17/2014 10:59:22 AM - P:\IER\11740\200-11740-10003\CAD\SHEETFILES\TREATMENT PLANT\WTP E-3402 GAC-BAC_PLAN LIGHTING PLAN.DWG - CALZARETTA, TIMOTHY

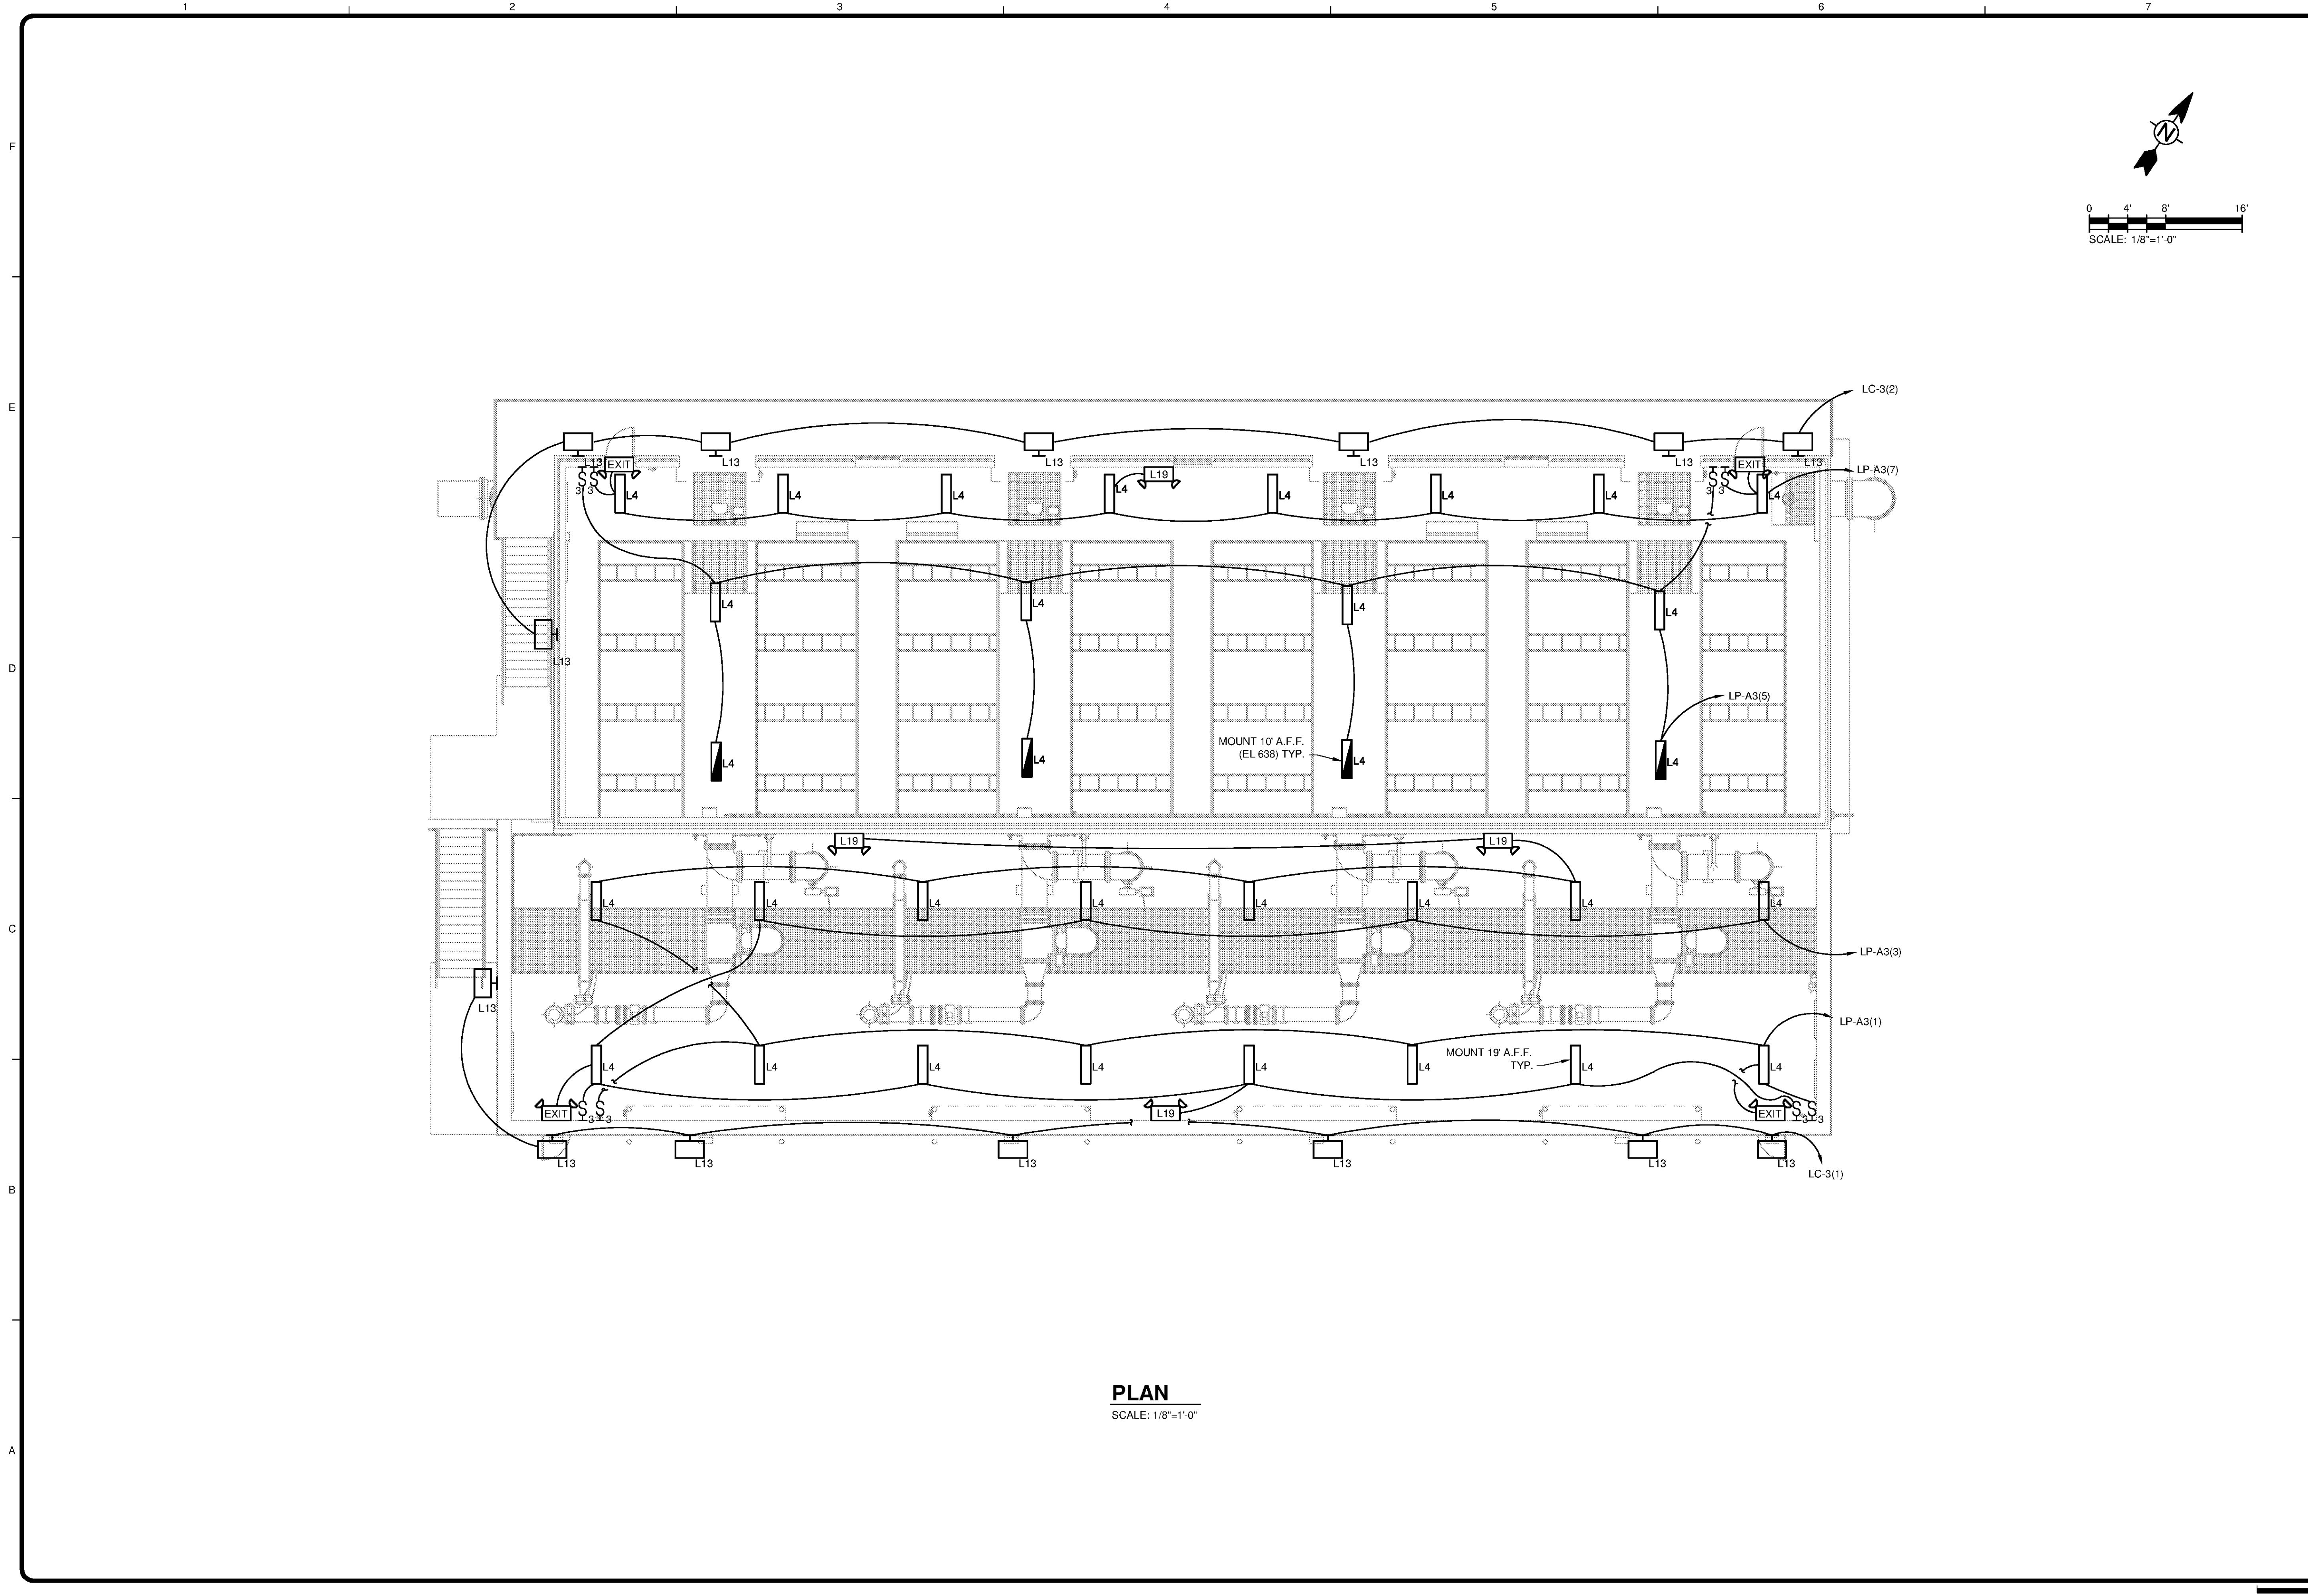

PLAN
SCALE: 1/8"=1'-0"

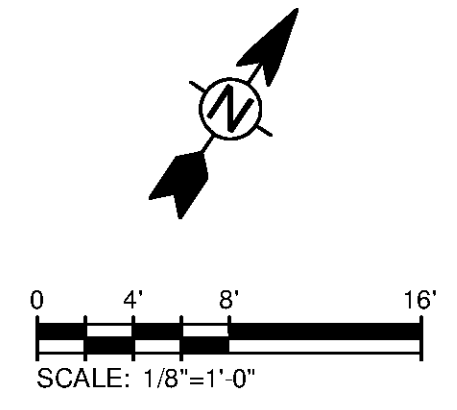

www.tetrattech.com
101 QUALITY CIRCLE, SUITE 140
HUNTSVILLE, ALABAMA 35806
PHONE: (256) 424-4077 FAX: (256) 424-4097

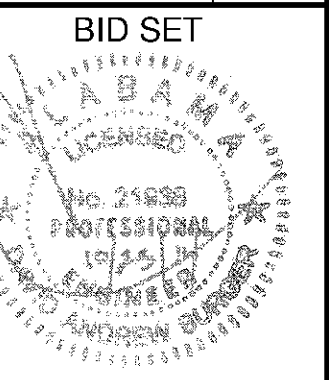

BID SET

| MARK | DATE | DESCRIPTION | BY |
|------|------|-------------|----|
| | | | |
| | | | |
HUNTSVILLE UTILITIES
SOUTHEAST WATER TREATMENT PLANT
**LIGHTING PLAN -
GAC-BAC
FILTER BUILDING**

Project No.: 200-11740-10003
Designed By: CSW
Drawn By: TAC
Checked By: DAB

E-3402

Copyright: Tetra Tech
Bar Measures 1 inch