

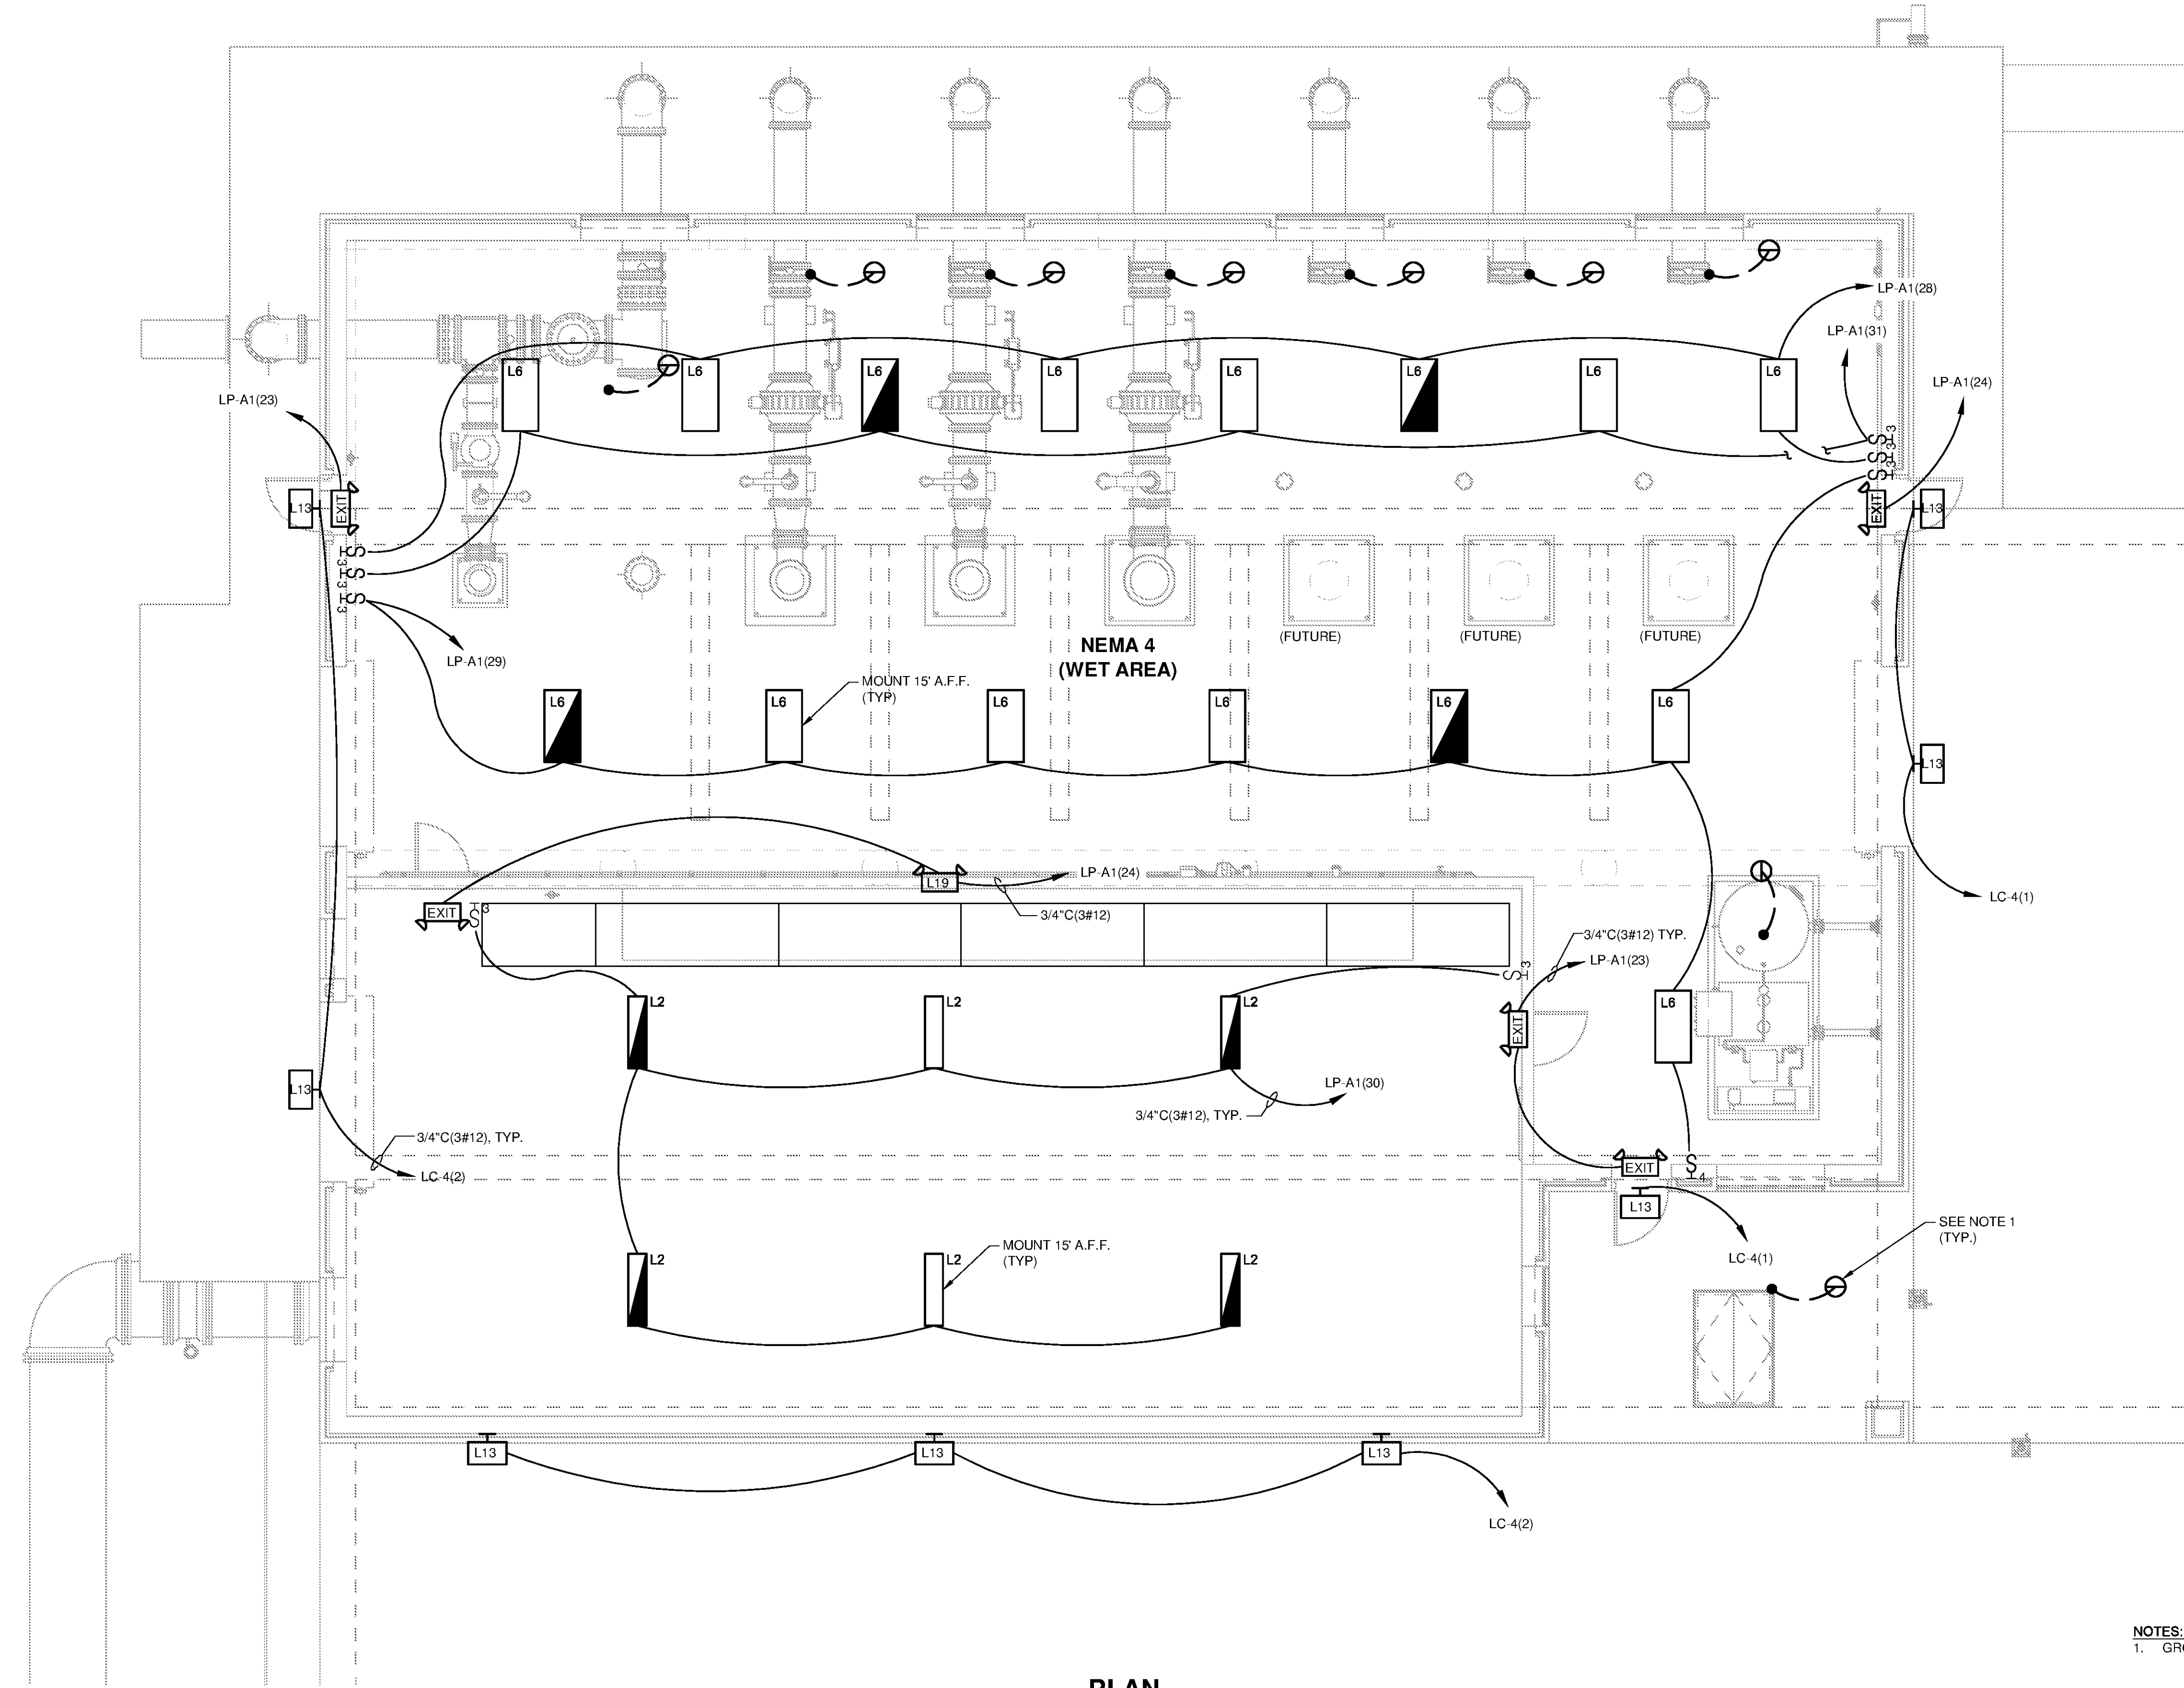


10/17/2014 11:00:02 AM - P:\IER\1740\200-11740-10003\CAD\SHEETFILES\TREATMENT PLANT\WTP-E-4402 LIGHTING PLAN - FINISHED WATER PUMP STATION.DWG - CALZARETTA, TIMOTHY

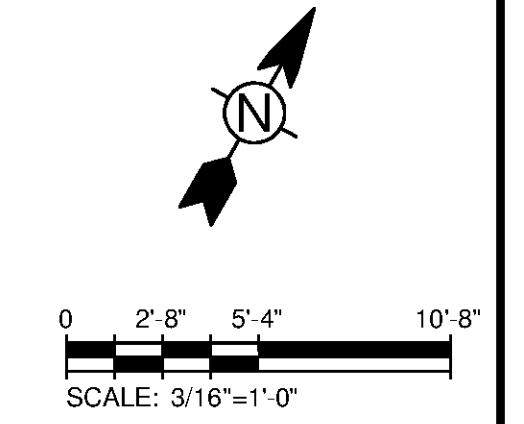

PLAN
SCALE: 3/16"=1'-0"

NOTES:
1. GROUND FRAME TO REBAR.

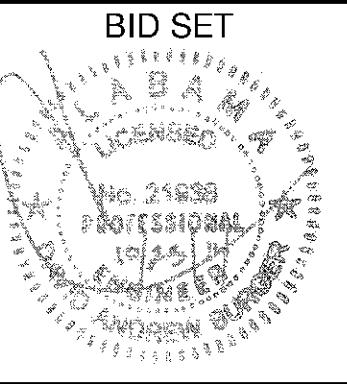

BY	DATE	DESCRIPTION

HUNTSVILLE UTILITIES
SOUTHEAST WATER TREATMENT PLANT
**LIGHTING PLAN -
FINISHED WATER
PUMP STATION**

Project No.: 200-11740-10003
Designed By: CSW/AJK
Drawn By: TAC
Checked By: DAB

E-4402

Bar Measures 1 inch

Copyright: Tetra Tech